



MILVERTON APARTMENT BUILDING

MURRAY COURT - BLOCK 17

MILVERTON ONTARIO

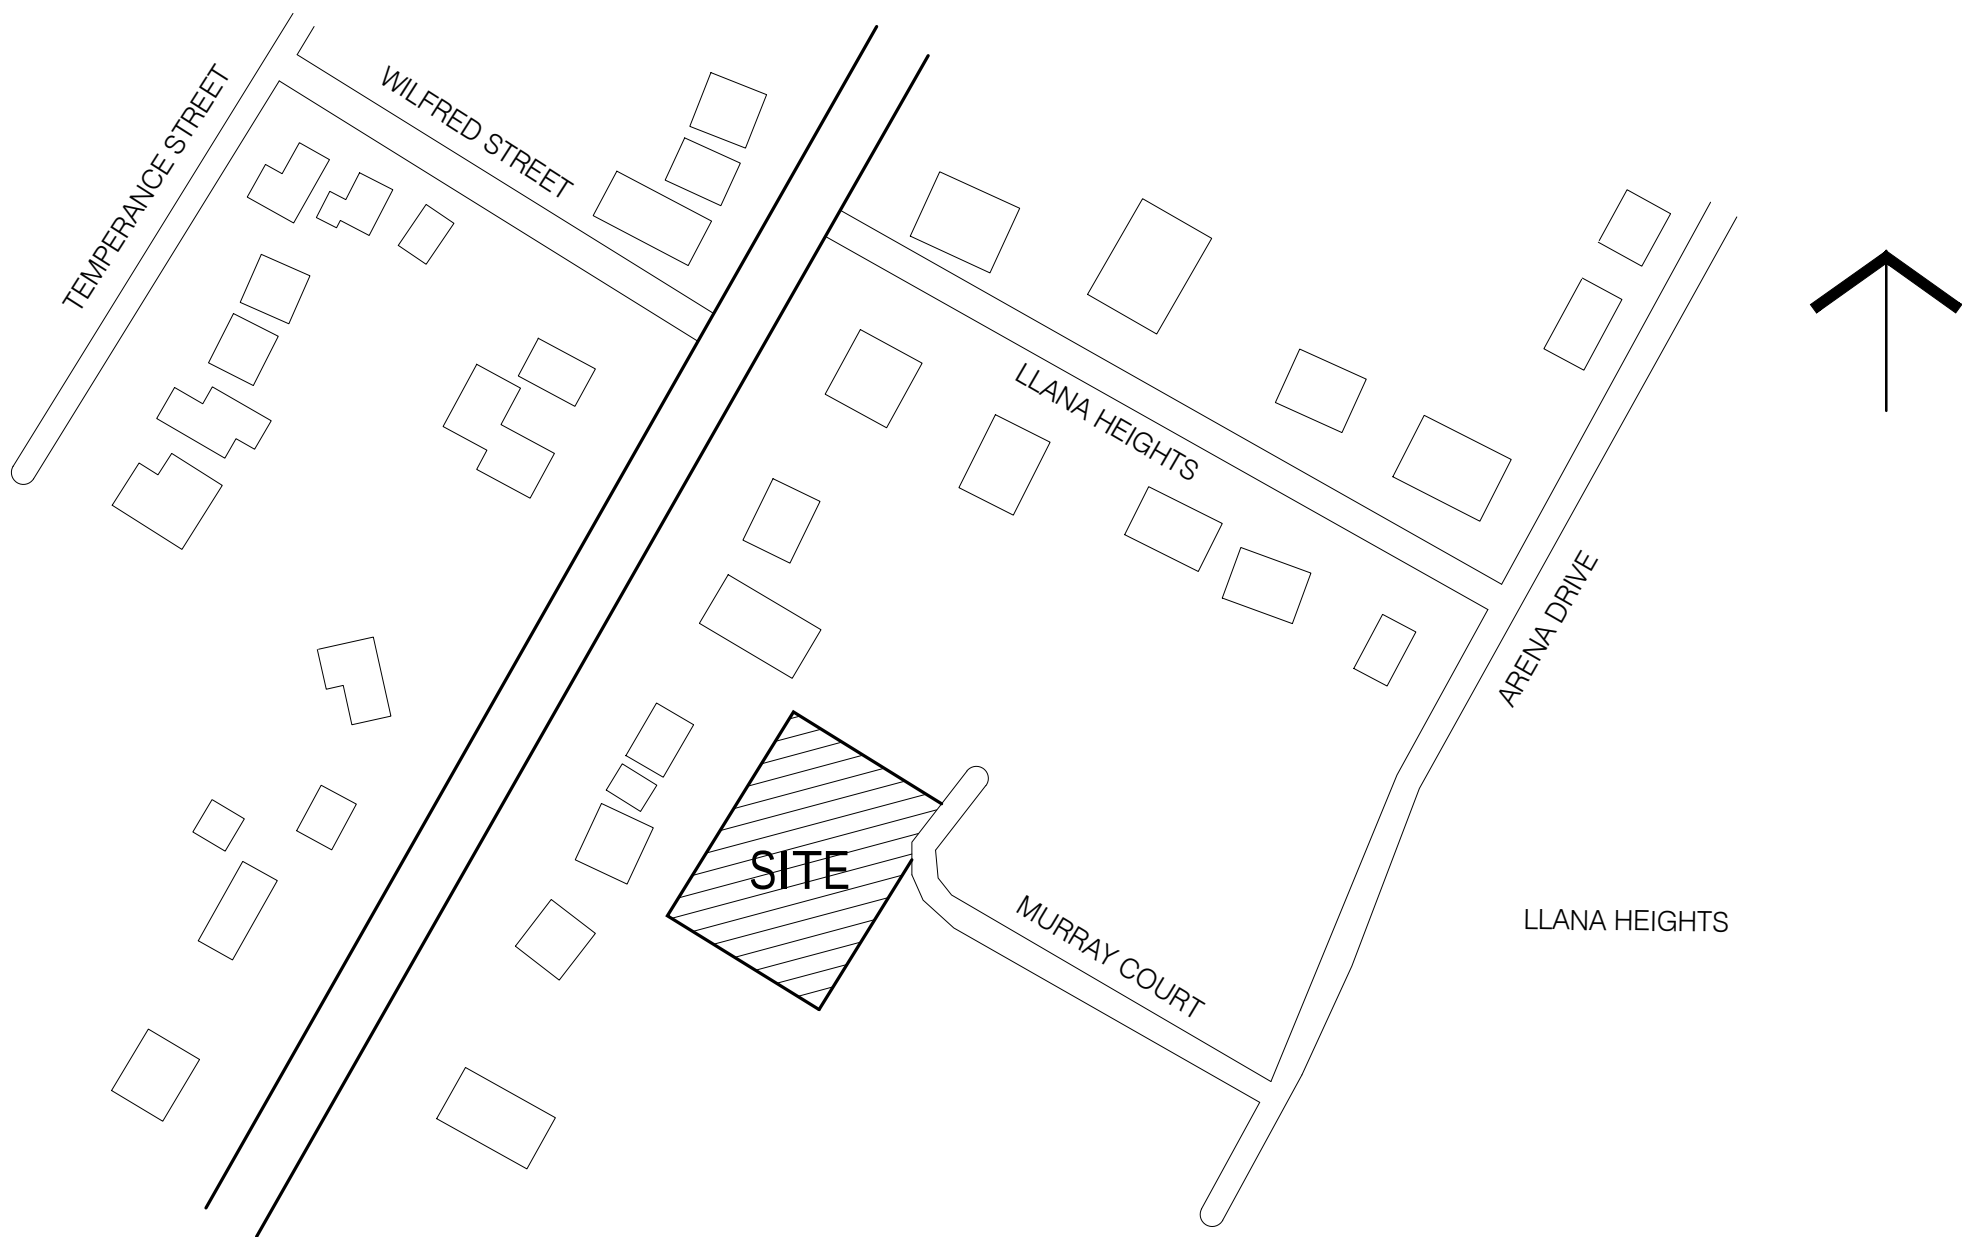

SITE KEY MAP

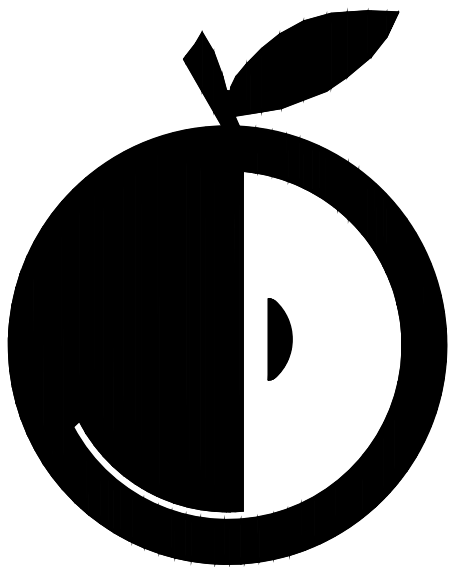

ORCHARD
DESIGN STUDIO INC.

gb architect inc.

Meritech Engineering
GSP Group
Centric Engineering Corporation
Collins Engineering Group Incorporated
Mighton Engineering Ltd.

INDEX TO DRAWINGS

CIVIL

4366.17-1 SHEET 1 of 2	LEGEND, DETAILS & PROJECT NOTES
4366.17-1 SHEET 2 of 2	BLOCK 17 - SITE GRADING AND SERVICING PLAN

LANDSCAPE

TO FOLLOW - SUBMISSION DATE TO BE DETERMINED

ARCHITECTURAL

A2.1	BLOCK 17 FOUNDATION FLOOR PLAN, MAIN FLOOR PLAN
A2.2	BLOCK 17 SECOND/THIRD FLOOR PLAN, ROOF PLAN
A3.1	BLOCK 17 NORTH ELEVATION
A3.2	BLOCK 17 WEST ELEVATION
A3.3	BLOCK 17 EAST ELEVATION
A3.3	BLOCK 17 SOUTH ELEVATION
A4.1	BLOCK 17 ENLARGED SUITE PLANS
A4.2	BLOCK 17 ENLARGED SUITE PLANS
A4.3	BLOCK 17 ENLARGED SUITE PLANS
A5.1	BLOCK 17 STAIR PLANS & SECTIONS
A6.1	BLOCK 17 WALL SECTIONS
A6.2	BLOCK 17 WALL SECTIONS

ARCHITECTURAL SPECIFICATIONS

D0	INFORMATION
D1	CONSTRUCTION ASSEMBLIES
D2	SITE DETAILS
D2	SITE DETAILS

STRUCTURAL

TO FOLLOW - SUBMISSION DATE TO BE DETERMINED

MECHANICAL


M1.1A	BLOCK 17 BASEMENT PLUMBING PLAN
M1.1B	BLOCK 19 BASEMENT PLUMBING PLAN
M1.2	BLOCK 17/19 GROUND FLOOR PLUMBING
M1.3	BLOCK 17/19 2ND & 3RD FLOOR PLUMBING
M2.1A	BLOCK 17 BASEMENT HVAC PLAN
M2.1B	BLOCK 19 BASEMENT HVAC PLAN
M2.2	BLOCK 17/19 GROUND FLOOR HVAC
M2.3	BLOCK 17/19 2ND & 3RD FLOOR HVAC
M3.1	BLOCK 17/19 PLUMBING NOTES, DETAILS, SCHEDULES & SPECIFICATIONS
M3.2	BLOCK 17/19 HVAC NOTES, DETAILS & SCHEDULES

ELECTRICAL

E1.1	SITE PLAN
E2.1	BASEMENT FLOOR LIGHTING & LIFE SAFETY PLAN
E2.2	FIRST FLOOR LIGHTING & LIFE SAFETY PLAN
E2.3	SECOND FLOOR LIGHTING & LIFE SAFETY PLAN
E2.4	THIRD FLOOR LIGHTING & LIFE SAFETY PLAN
E3.1	BASEMENT FLOOR POWER & COMMUNICATION PLAN
E3.2	FIRST FLOOR POWER & COMMUNICATION PLAN
E3.3	SECOND FLOOR POWER & COMMUNICATION PLAN
E3.4	THIRD FLOOR POWER & COMMUNICATION PLAN
E4.1	SCHEDULES & DETAILS
E4.2	SCHEDULES & SPECIFICATIONS

SET No. 14705-21.12.13-R6-BLK 17

ISSUED: BUILDING PERMIT SET - 2021-12-13

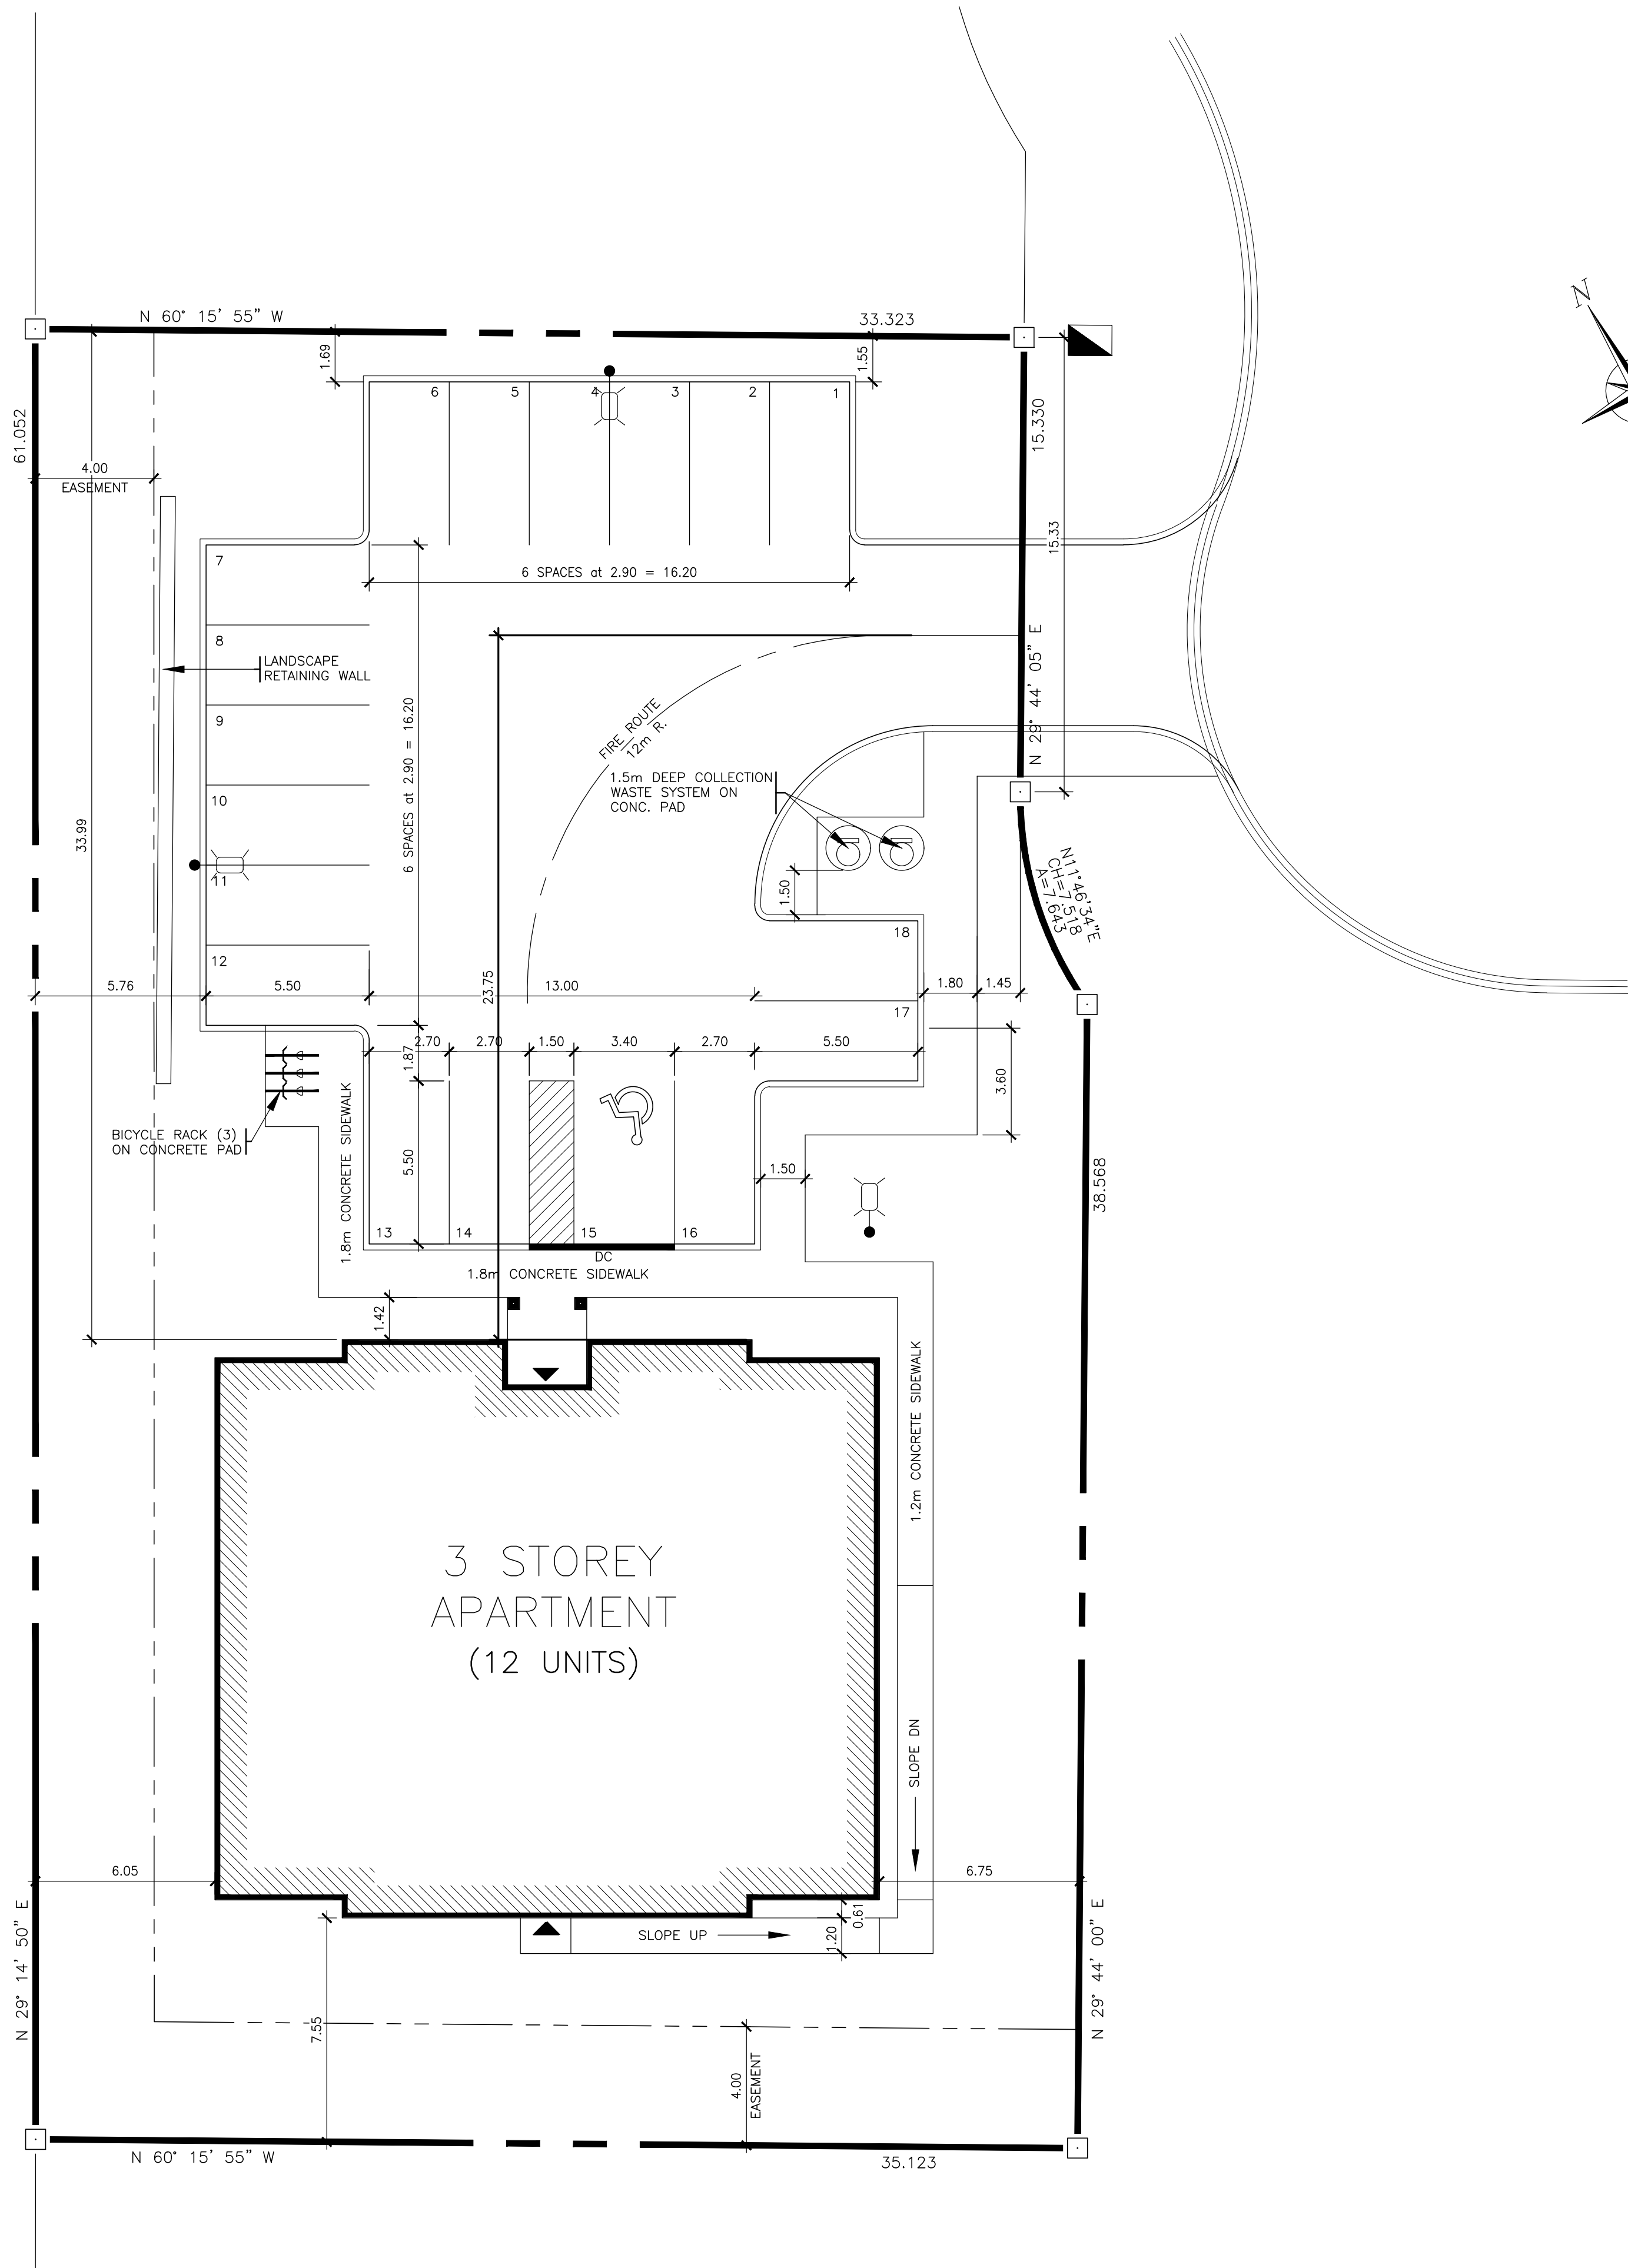

Item	Ontario Building Code Data Matrix Parts 3 + 9						OBC Reference					
1	Project Description: Milverton Apartment – Block 17 ☒ New ☐ Addition ☐ Change of Use ☐ Alteration				☐ Part 11 ☐ Part 3 ☒ Part 9		2.1.1 9.10.1.3					
2	Major Occupancy(s) Group C – Residential Occupancy						3.1.2.1.(1)					
3	Building Area (m²)		Existing	N/A	New	422.50m²	Total	422.50m²	1.1.3.2			
4	Gross Area		Existing	N/A	New	1,262.90m²	Total	1,262.90m²	1.1.3.2			
	1st Floor		Existing	N/A	New	422.50m²	Total	422.50m²	1.1.3.2			
	2nd Floor		Existing	N/A	New	420.20m²	Total	420.20m²				
	3rd Floor		Existing	N/A	New	420.20m²	Total	420.20m²				
5	Number of Storeys Above grade				3	Below grade		1	3.2.1.1 & 1.1.3.2			
6	Height of Building (m) 11.46m from Average Grade to Midpoint of Roof						2.1.1.3					
7	Number of Streets/Access Routes 1						3.2.2.10 & 3.2.5.5					
8	Building Classification 'C' Residential Occupancies (Table 9.10.2.1.)						3.2.2.20–83					
9	Sprinkler System Proposed						☐ Entire building ☐ Basement only ☐ In lieu of roof rating ☒ Not required					
10	Standpipe required						☐ Yes ☒ No					
11	Fire Alarm required						☒ Yes ☐ No					
12	Water Service/Supply is Adequate						☒ Yes ☐ No					
13	High Building						☐ Yes ☒ No					
14	Permitted Construction ☒ Combustible Actual Construction ☒ Combustible						☐ Non-combustible ☐ Non-combustible					
15	Mezzanine(s) Area m² N/A						3.2.1.1.(3)–(8)					
16	Occupant load based on ☐ m²/person ☒ design of building						3.1.1.6					
	Basement:						Occupancy Group C Load 10 persons					
	1st Floor						Occupancy Group C Load 16 persons					
	2nd Floor						Occupancy Group C Load 20 persons					
	3rd Floor						Occupancy Group C Load 20 persons					
17	Barrier-free Design ☒ Yes ☐ No (Explain)						3.8					
18	Hazardous Substances ☐ Yes ☒ No (Explain)						3.3.1.2.(1) & 3.3.1.19(1)					
19	Required Fire Resistance Rating (FRR)	Horizontal Assemblies			Listed Design No. or Description (SG-2)			3.2.2.20–83 & 3.2.1.4				
		FRR (Hours)										
		Floors 3/4 Hour			OBC – SB-3, F19b							
		Roof 1/2 Hour			OBC – SB-3, R1							
		Mezzanine N/A Hours			N/A							
		FRR of Supporting Members			Listed Design No. Or Description (SG-2)							
		Floors 3/4 Hour			OBC – SB-3 F19b							
		Roof 1/2 Hour			OBC – SB-3 F19b							
20	Spatial Separation – Construction of Exterior Walls						3.2.3					
	Wall	Area of EBF (m²)	L.D. (m)	L/H or H/L	Permitted Max. % of Openings	Proposed % of Openings	FRR (Hours)	Listed Design or Description	Comb Const	Comb. Constr. Nonc. Cladding	Non-comb. Constr.	
	North	206.36	>20.0		100	N/A	N/A	N/A	Yes	Yes	No	
	East	171.85	6.75		20.5	11.0	N/A	N/A	Yes	Yes	No	
	South	225.09	7.55		20.7	15.7	N/A	N/A	Yes	Yes	No	
	West	184.67	6.05		20.3	10.3	N/A	N/A	Yes	Yes	No	
21	Other Note: Percentages shown for Permitted max % of openings is a prorated value related to limiting distance											

BLOCK 17 - ZONING - R3-8 (12 UNITS)		
REGULATION	REQUIRED	PROPOSED
LOT AREA (MIN.)	N/A	2,113.88 sq.m. / 0.211 ha
DENSITY - 50 UNITS/HA (MAX.)	10 UNITS	*12 UNITS
LOT FRONTAGE (MIN.)	30.0 m	15.33 m
FRONT YARD (MIN.)	7.5 m	33.99 m
INTERIOR SIDE YARD (MIN.)	6.0 m	6.05 m
REAR YARD (MIN.)	7.5 m	7.55 m
LOT COVERAGE (MAX.)	40% (845.55 sq.m.)	20.0% (422.48 sq.m.)
BUILDING HEIGHT (MAX.)	10.0 m	*11.85 m
LANDSCAPE OPEN SPACE (MIN.)	30% (634.16 sq.m.)	52.71% (1,114.14 sq.m.)
APARTMENT DWELLING FLOOR AREA PER UNIT (MIN.)	55.0 sq.m.	84.2 sq.m.
PARKING SPACES	1.5 SPACES PER UNIT = 18 SPACES	18 SPACES

*SITE SPECIFIC ZONING REQUIRED

BUILDING DATA


ALL BUILDINGS TO BE DESIGNED IN ACCORDANCE TO PART 9 OF THE ONTARIO BUILDING CODE
COMBUSTIBLE CONSTRUCTION UP TO 3 STOREYS IN BUILDING HEIGHT

LEGEND

IRON BAR	
PROPERTY LINE	
MAN DOOR ENTRANCE / EXIT.	
DROPPED CURB	
EXTERIOR LIGHT	

PROPERTY DATA

PROPERTY DESCRIPTION: PLAN OF SUBDIVISION COMPOSED OF LOTS 3 TO 30, INCLUSIVE, BLOCK 'B' AND ARENA DRIVE AND MURRAY COURT, REGISTERED PLAN NO. 489 TOWNSHIP OF PERTH EAST COUNTY OF PRY (FORMERLY IN THE VILLAGE OF MILVERTON) AS PREPARED BY METZ & LORENTZ LTD, ONTARIO LAND SURVEYORS DATED JANUARY 5, 2016

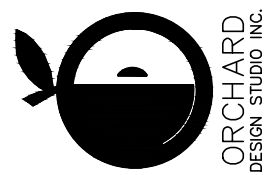


gb architect inc.

430 ONTARIO STREET
STRATFORD, ONTARIO N5A 3Z2
PHONE (519) 272-0073 FAX (519) 272-4333

*Guy R. Bellemeur, B. Arch, OAA, MRAC
Principal Architect of GB ARCHITECT INC. is the
designer for this project with respect to all architectural
work identified on this drawing sheet. The Ontario
Architectural Association (OAA) has reviewed this
drawing sheet and found it to be in compliance with
the requirements of the Ministry of Municipal
Affairs & Housing Bill 124.
The Architect above has exercised responsible control with
respect to design activities. The Architect's seal number is their
BCLTS number.


ONTARIO ASSOCIATION
of
ARCHITECTS
GUY ROBERT BELLEMEUR
LICENCE
4217
DECEMBER 13, 2021

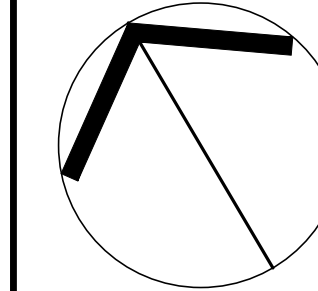


21-12-08	5	ISSUED TO CONSULTANTS	21-11-24	4	ISSUED TO CONSULTANTS	21-11-08	3	REVISED FOR SPA (1st SUBMISSION)	21-09-16	2	ISSUED FOR SPA (1st SUBMISSION)	21-08-24	1	ISSUED FOR OFFICIAL PLAN AMENDMENT	No.	REVISION
----------	---	-----------------------	----------	---	-----------------------	----------	---	----------------------------------	----------	---	---------------------------------	----------	---	------------------------------------	-----	----------

STATUS	DESIGN DEVELOPMENT	MILVERTON APARTMENT BUILDING	ONTARIO	BLOCK 17 SITE PLAN
PROJECT	FOLDER	MILVERTON	FILE BLOCK 17 - Siteplan.dwg	
SHEET No.	SCALE	1:150	DRAWN BY	KSR
	DATE	APRIL 2021	REVIEWED	
	JOB No.	14705		


A1.1

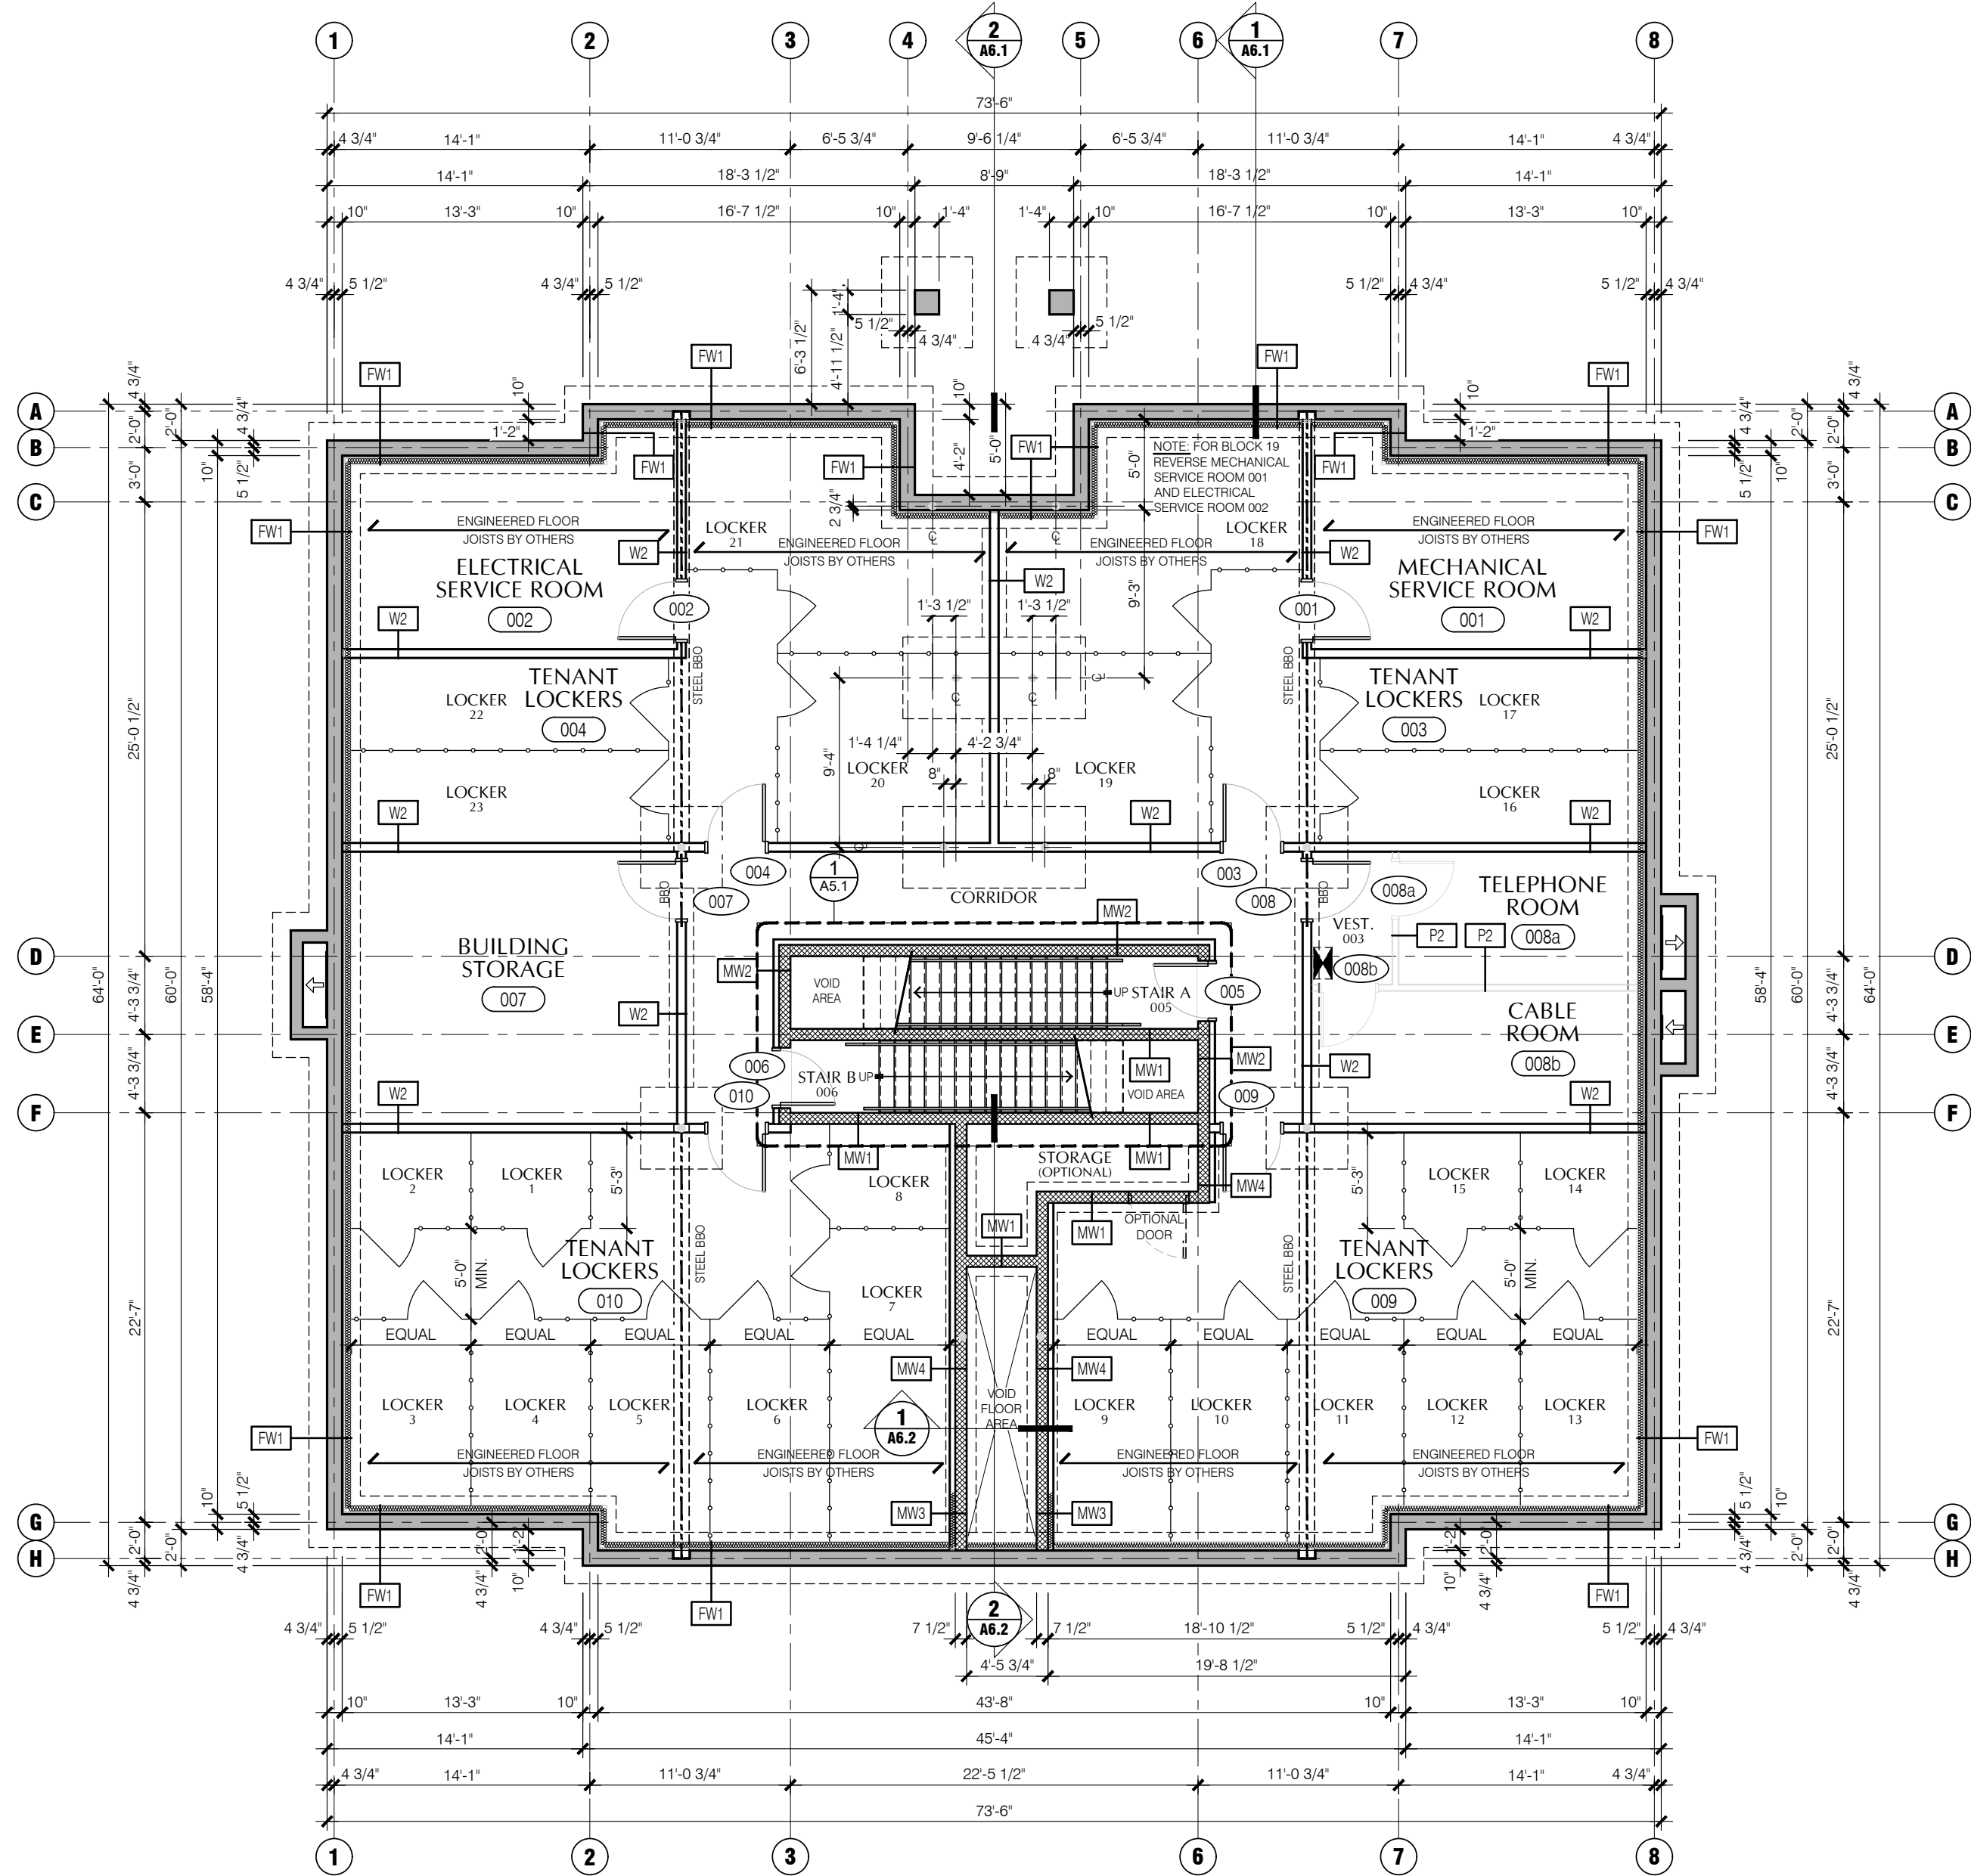

2 OVERALL FLOOR PLAN - BASEMENT FLOOR LEVEL
A2.1 1/8" = 1'-0"

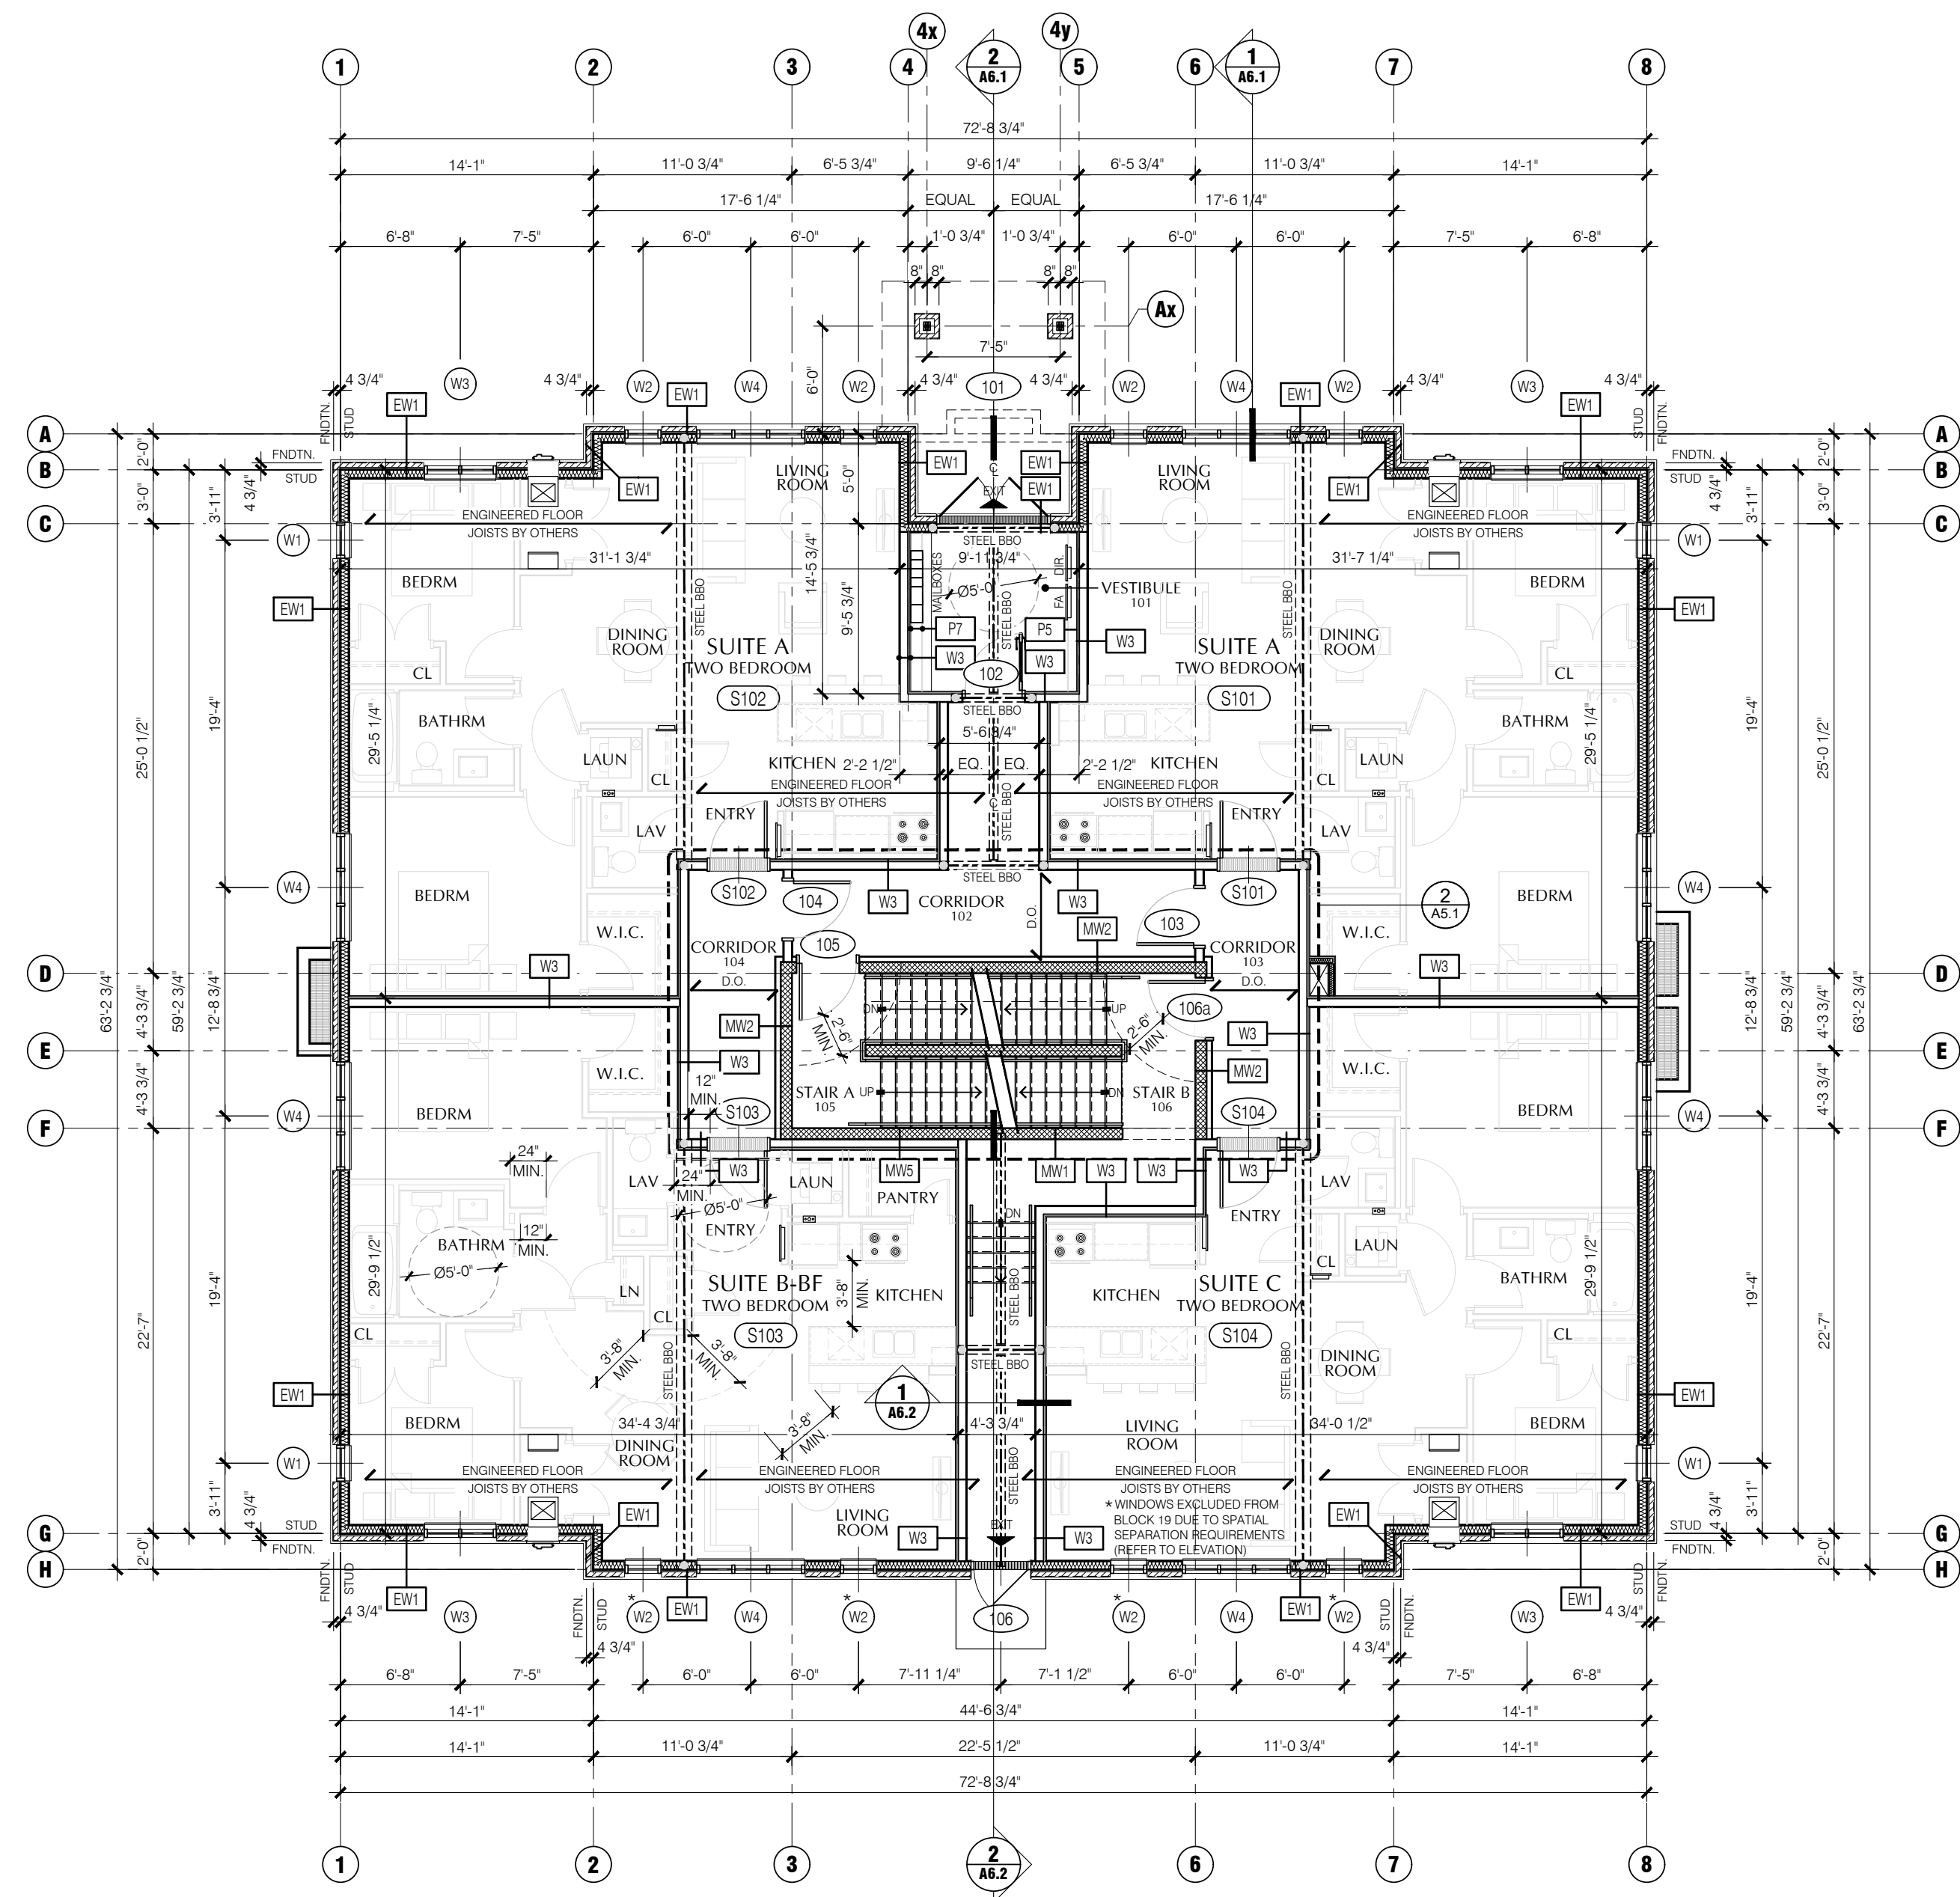


1 OVERALL FLOOR PLAN - FIRST FLOOR LEVEL
A2.1 1/8" = 1'-0"
* WINDOWS EXCLUDED FROM BLOCK 19 DUE TO SPATIAL SEPARATION REQUIREMENTS (REFER TO ELEVATION)

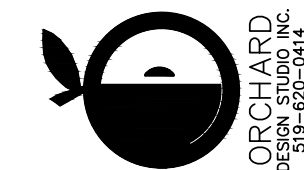

orchard
design group inc.
430 ONTARIO STREET
STRATFORD, ONTARIO N5A 3Z2
PHONE (519) 272-0073 FAX (519) 272-4433

*Guy R. Bellemare, B. Arch, OAA, MRAC
Principal Architect of GBA ARCHITECT INC. is the
designer for this project with respect to all architectural
work identified on this drawing sheet. The Ontario
Architectural Association (OAA) is the governing body
for the regulation of the architectural profession in
Ontario.
Guy R. Bellemare, B. Arch, OAA, MRAC
B228 Number 427
as per requirements of the Ministry of Municipal
Affairs & Housing Bill 124.
The Architect above has exercised responsible control with
respect to design activities. The Architect's seal number is their
B228 number.

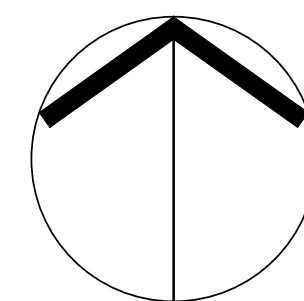

STATUS	DESIGN DEVELOPMENT	21-12-13	6	ISSUED FOR PERMIT
FOUNDER	MARTIN-MILVERTON	21-12-08	5	ISSUED TO CONSULTANTS
SCALE	1/8" = 1'-0"	21-11-24	4	ISSUED TO CONSULTANTS
DRAWN BY	JED	21-11-09	3	REVISED FOR SPA (1st SUBMISSION)
DATE	APRIL 2021	21-09-16	2	ISSUED FOR SPA (1st SUBMISSION)
REVISION		21-08-24	1	ISSUED FOR OFFICIAL PLAN AMENDMENT
JOB No.	14705	DATE	No.	REVISION


PROJECT
MILVERTON
APARTMENT BUILDING
MILVERTON ONTARIO
BLOCK 17
FOUNDATION FLOOR PLAN,
MAIN FLOOR PLAN

A2.1





MATERIALS LEGEND:

- 1 CAST-IN-PLACE CONCRETE FOOTING (REFER TO STRUCTURAL)
- 2 CAST-IN-PLACE CONCRETE FOUNDATION WALL (REFER TO STRUCTURAL)
- 3 EXPOSED CONCRETE FOUNDATION MIN. 6" FROM GRADE TO MASONRY VENEER
- 4 APPROXIMATE FINISHED GRADE
- 5 BRICK VENEER 1 COLOUR: AS PER ARCHITECT/OWNER GROUT: AS PER ARCHITECT/OWNER
- 6 BRICK VENEER 2 COLOUR: AS PER ARCHITECT/OWNER GROUT: AS PER ARCHITECT/OWNER
- 7 PRECAST SILL BETWEEN MASONRY VENEERS AND SIDING (TYPICAL)
- 8 BRICK VENEER SOLDIER COURSE COLOUR: AS PER ARCHITECT/OWNER GROUT: AS PER ARCHITECT/OWNER
- 9 COMPOSITE WINDOW TRIM COLOUR: AS PER ARCHITECT/OWNER
- 10 COMPOSITE PANEL SYSTEM AND MATCHING TRIM OR APPROVED ALTERNATE COLOUR: AS PER ARCHITECT/OWNER
- 11 HORIZONTAL COMPOSITE SIDING OR APPROVED ALTERNATE COLOUR: AS PER ARCHITECT/OWNER
- 12 VERTICAL COMPOSITE TRIM AT BUILDING CORNERS (TYPICAL) COLOUR: AS PER ARCHITECT/OWNER
- 13 VINYL WINDOW THERMALLY BROKEN, SEALED DOUBLE GLAZED UNITS WITH OPERABLE CASEMENT AS SHOWN (TYPICAL) COLOUR: WHITE
- 14 METAL CLAD TERRACE DOOR THERMALLY BROKEN, SEALED DOUBLE GLAZED UNITS AS SHOWN (TYPICAL) COLOUR: WHITE
- 15 METAL INSULATED MANDOOR. REFER TO PLAN FOR SIZE AND LOCATION
- 16 HVAC VENT/LOUVER (TYPICAL) AT HVAC WALL SLEEVE PROVIDE INSULATION KIT TO INCLUDE THREE SECTIONS OF 5/8" FOIL FACED DUCTBOARD PAINTED BLACK ON SITE (REFER TO MECHANICAL)
- 17 PREFINISHED METAL FASCIA, TRIM AND EAVESTROUGH
- 18 PREFINISHED METAL FLASHING
- 19 ASPHALT SHINGLE OR APPROVED ALTERNATE COLOUR: AS PER ARCHITECT/OWNER
- 20 LANDSCAPE RETAINING WALL (REFER TO SITE PLAN AND CIVIL)
- 21 HIGH WALL MOUNTED LOW PROFILE VENT KIT. COLOUR: AS PER ARCHITECT/OWNER (REFER TO MECHANICAL)
- 22 CAST IN PLACE CONCRETE MECHANICAL WELL. EXACT LOCATION AND HEIGHT ABOVE FLOOR LEVEL TO BE DETERMINED BY OWNER/CONTRACTOR. (REFER TO MECHANICAL)
- 23 INTAKE/EXHAUST LOUVERS AT MECHANICAL WELL. EXACT LOCATION AND HEIGHT ABOVE FLOOR LEVEL TO BE DETERMINED BY OWNER/CONTRACTOR. (REFER TO MECHANICAL)

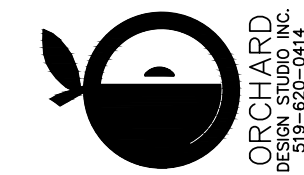

gb architect inc.
430 ONTARIO STREET
STRATFORD, ONTARIO, N5A 3Z2
PHONE (519) 272 0073 FAX (519) 272 4433

*Guy R. Bellemeur, B. Arch, OAA, MRAC,
Principal Architect of GB ARCHITECT INC. is the
designer for this project with respect to all architectural
work identified on this drawing sheet. The Ontario
Architectural Association (OAA) has reviewed this
drawing sheet and found it to be in compliance with
the requirements of the Ministry of Municipal
Affairs & Housing Bill 124.
The Architect above has exercised responsible control with
respect to design activities. The Architect's seal number is their
B.C.D.S. number.

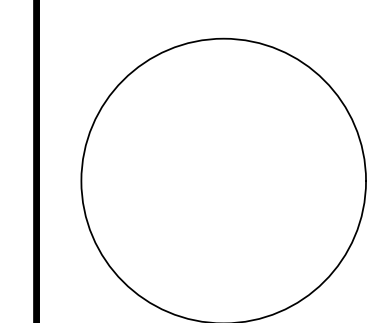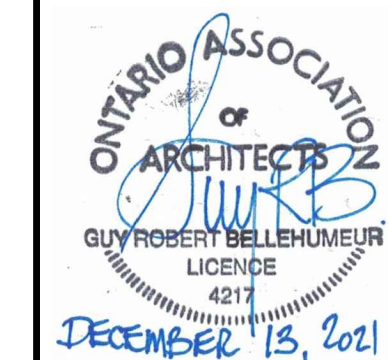

STATUS	DESIGN DEVELOPMENT	ISSUED FOR PERMIT	21-12-13	6
OWNER	MARTIN-MILVERTON	ISSUED TO CONSULTANTS	21-12-08	5
SCALE	1/4" = 1'-0"	ISSUED TO CONSULTANTS	21-11-24	4
DATE	APRIL 2021	REVISED FOR SPA (1st SUBMISSION)	21-11-09	3
REVISION		ISSUED FOR SPA (1st SUBMISSION)	21-09-16	2
DATE		ISSUED FOR OFFICIAL PLAN AMENDMENT	21-08-24	1
NO.		REVISION		

PROJECT	MILVERTON APARTMENT BUILDING
CLIENT	MILVERTON ONTARIO
TITLE	BLOCK 17 NORTH ELEVATION

SHEET No.


A3.1



1 WEST ELEVATION - BLOCK 17
A3.2 1/4" = 1'-0"



MATERIALS LEGEND:

- 1 CAST-IN-PLACE CONCRETE FOOTING (REFER TO STRUCTURAL)
- 2 CAST-IN-PLACE CONCRETE FOUNDATION WALL (REFER TO STRUCTURAL)
- 3 EXPOSED CONCRETE FOUNDATION MIN. 6" FROM GRADE TO MASONRY VENEER
- 4 APPROXIMATE FINISHED GRADE
- 5 BRICK VENEER 1 COLOUR: AS PER ARCHITECT/OWNER GROUT: AS PER ARCHITECT/OWNER
- 6 BRICK VENEER 2 COLOUR: AS PER ARCHITECT/OWNER GROUT: AS PER ARCHITECT/OWNER
- 7 PRECAST SILL BETWEEN MASONRY VENEERS AND SIDING (TYPICAL)
- 8 BRICK VENEER SOLDIER COURSE COLOUR: AS PER ARCHITECT/OWNER GROUT: AS PER ARCHITECT/OWNER
- 9 COMPOSITE WINDOW TRIM COLOUR: AS PER ARCHITECT/OWNER
- 10 COMPOSITE PANEL SYSTEM AND MATCHING TRIM OR APPROVED ALTERNATE COLOUR: AS PER ARCHITECT/OWNER
- 11 HORIZONTAL COMPOSITE SIDING OR APPROVED ALTERNATE COLOUR: AS PER ARCHITECT/OWNER
- 12 VERTICAL COMPOSITE TRIM AT BUILDING CORNERS (TYPICAL) COLOUR: AS PER ARCHITECT/OWNER
- 13 VINYL WINDOW THERMALLY BROKEN, SEALED DOUBLE GLAZED UNITS WITH OPERABLE CASEMENT AS SHOWN (TYPICAL) COLOUR: WHITE
- 14 METAL CLAD TERRACE DOOR THERMALLY BROKEN, SEALED DOUBLE GLAZED UNITS AS SHOWN (TYPICAL) COLOUR: WHITE
- 15 METAL INSULATED MANDOOK. REFER TO PLAN FOR SIZE AND LOCATION
- 16 HVAC VENT/LOUVER (TYPICAL) AT HVAC WALL SLEEVE PROVIDE INSULATION KIT TO INCLUDE THREE SECTIONS OF 5/8" FOIL FACED DUCTBOARD PAINTED BLACK ON SITE (REFER TO MECHANICAL)
- 17 PREFINISHED METAL FASCIA, TRIM AND EAVESTROUGH
- 18 PREFINISHED METAL FLASHING
- 19 ASPHALT SHINGLE OR APPROVED ALTERNATE COLOUR: AS PER ARCHITECT/OWNER
- 20 LANDSCAPE RETAINING WALL (REFER TO SITE PLAN AND CIVIL)
- 21 HIGH WALL MOUNTED LOW PROFILE VENT KIT. COLOUR: AS PER ARCHITECT/OWNER (REFER TO MECHANICAL)
- 22 CAST IN PLACE CONCRETE MECHANICAL WELL C/W REMOVABLE GALVANIZED METAL GRATE(S) FLUSH WITH TOP OF CONCRETE. (REFER TO MECHANICAL)
- 23 INTAKE/EXHAUST LOUVERS AT MECHANICAL WELL. EXACT LOCATION AND HEIGHT ABOVE FLOOR LEVEL TO BE DETERMINED BY OWNER/CONTRACTOR. (REFER TO MECHANICAL)

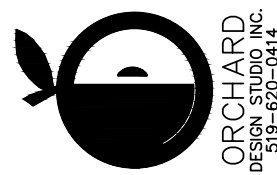

gb architect inc.
430 ONTARIO STREET
STRATFORD, ONTARIO, N5A 3Z2
PHONE (519) 272-0073 FAX (519) 272-1433


*Guy R. Bellemeur, B. Arch., OAA, MRAC,
Principal Architect of GB ARCHITECT INC. is the
designer for this project with respect to all architectural
work identified on this drawing sheet. The Ontario
Architectural Association (OAA) has reviewed the
work of Guy R. Bellemeur and GB ARCHITECT INC.
as per requirements of the Ministry of Municipal
Affairs & Housing Bill 124.
The Architect above has exercised responsible control with
respect to design activities. The Architect's seal number is their
B.C.D.S. number.

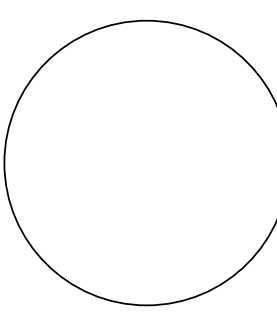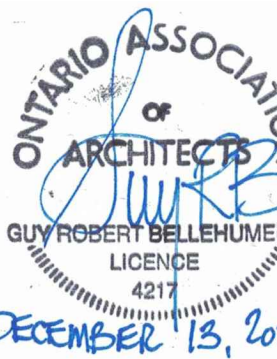

STATUS	DESIGN DEVELOPMENT	21-12-13	6	ISSUED FOR PERMIT
FOLDER	MARTIN-MILVERTON	21-12-08	5	ISSUED TO CONSULTANTS
SCALE	1/4" = 1'-0"	21-11-24	4	ISSUED TO CONSULTANTS
OWN BY	JED	21-11-08	3	REVISED FOR SPA (1st SUBMISSION)
DATE	APRIL 2021	21-09-16	2	ISSUED FOR SPA (1st SUBMISSION)
REVISED		21-08-24	1	ISSUED FOR OFFICIAL PLAN AMENDMENT
JOB No.	14705	DATE	No.	REVISION

PROJECT	MILVERTON APARTMENT BUILDING
SHEET No.	MILVERTON ONTARIO BLOCK 17 WEST ELEVATION


A3.2

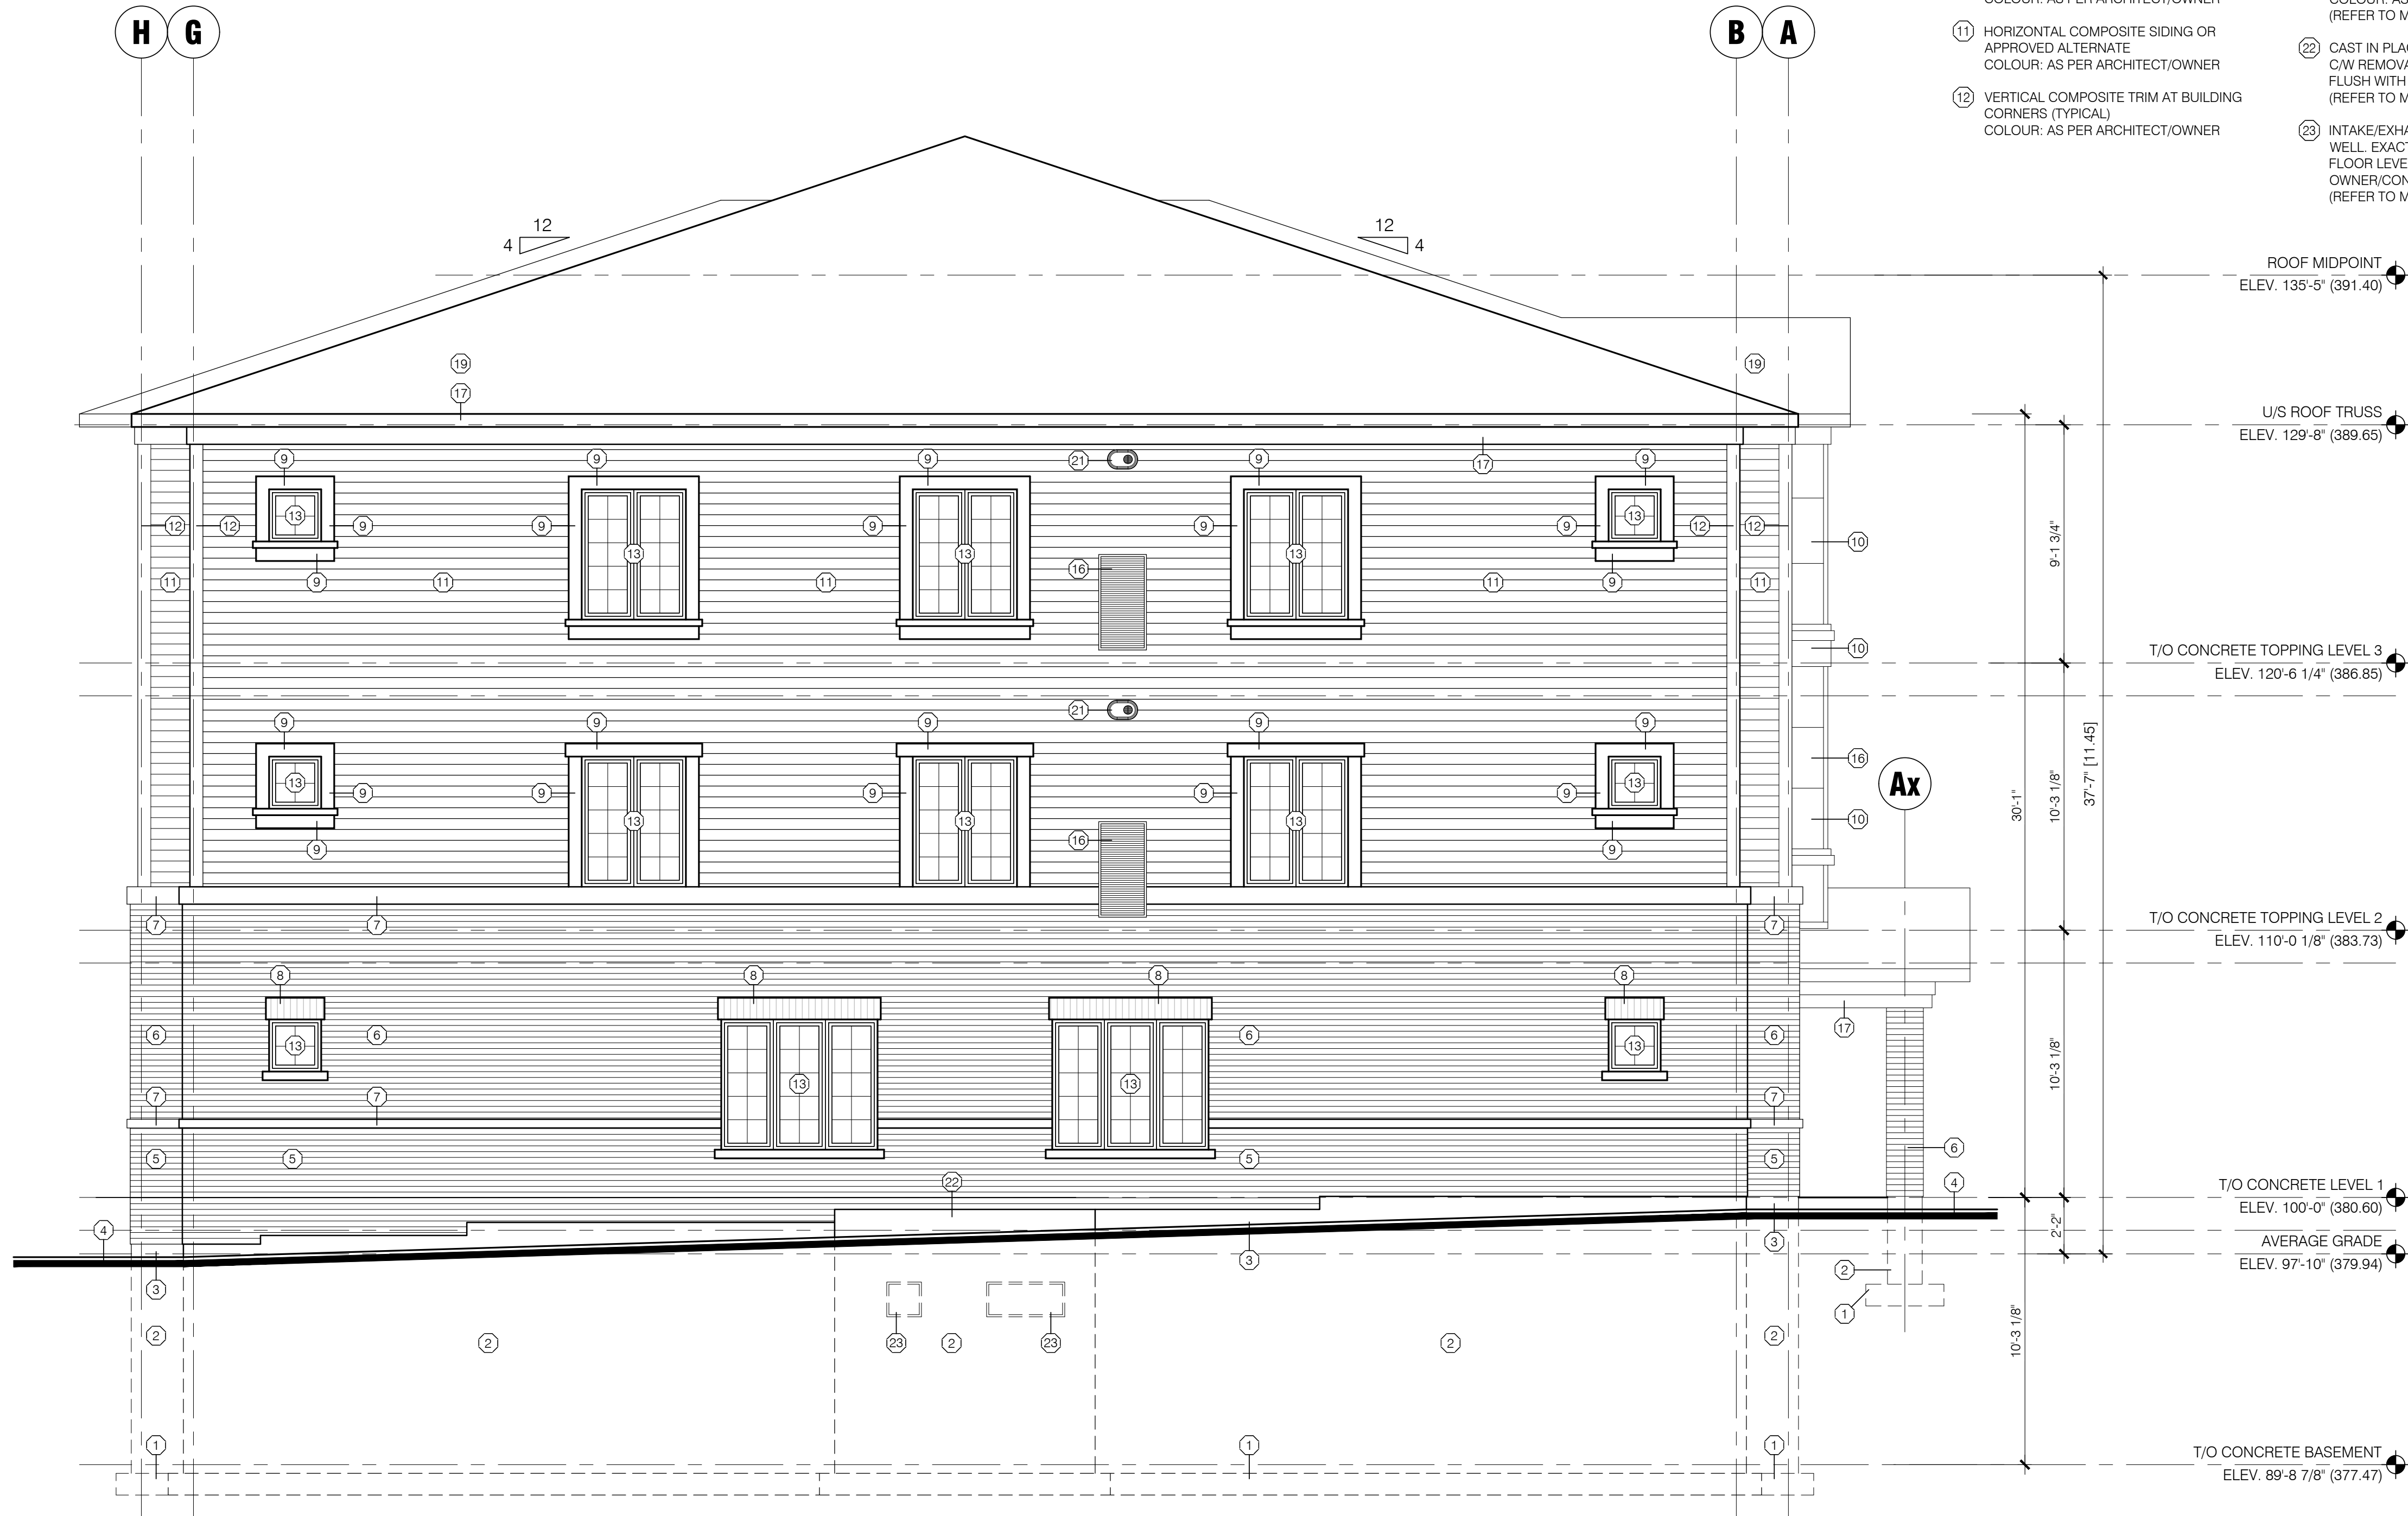

1 EAST ELEVATION - BLOCK 17
A3.3 1/4" = 1'-0"



MATERIALS LEGEND:

- | | |
|---|---|
| ① CAST-IN-PLACE CONCRETE FOOTING (REFER TO STRUCTURAL) | ⑬ VINYL WINDOW THERMALLY BROKEN, SEALED DOUBLE GLAZED UNITS WITH OPERABLE CASEMENT AS SHOWN (TYPICAL) COLOUR: WHITE |
| ② CAST-IN-PLACE CONCRETE FOUNDATION WALL (REFER TO STRUCTURAL) | ⑭ METAL CLAD TERRACE DOOR THERMALLY BROKEN, SEALED DOUBLE GLAZED UNITS AS SHOWN (TYPICAL) COLOUR: WHITE |
| ③ EXPOSED CONCRETE FOUNDATION MIN. 6" FROM GRADE TO MASONRY VENEER | ⑮ METAL INSULATED MANDOOK. REFER TO PLAN FOR SIZE AND LOCATION |
| ④ APPROXIMATE FINISHED GRADE | ⑯ HVAC VENT/LOUVER (TYPICAL) AT HVAC WALL. SLEEVE PROVIDE INSULATION KIT TO INCLUDE THREE SECTIONS OF 5/8" FOIL FACED DUCTBOARD PAINTED BLACK ON SITE (REFER TO MECHANICAL) |
| ⑤ BRICK VENEER 1 COLOUR: AS PER ARCHITECT/OWNER GROUT: AS PER ARCHITECT/OWNER | ⑰ PREFINISHED METAL FASCIA, TRIM AND EAVESTROUGH |
| ⑥ BRICK VENEER 2 COLOUR: AS PER ARCHITECT/OWNER GROUT: AS PER ARCHITECT/OWNER | ⑱ ASPHALT SHINGLE OR APPROVED ALTERNATE COLOUR: AS PER ARCHITECT/OWNER |
| ⑦ PRECAST SILL BETWEEN MASONRY VENEERS AND SIDING (TYPICAL) | ⑲ ASPHALT SHINGLE OR APPROVED ALTERNATE COLOUR: AS PER ARCHITECT/OWNER |
| ⑧ BRICK VENEER SOLDIER COURSE COLOUR: AS PER ARCHITECT/OWNER GROUT: AS PER ARCHITECT/OWNER | ⑳ LANDSCAPE RETAINING WALL (REFER TO SITE PLAN AND CIVIL) |
| ⑨ COMPOSITE WINDOW TRIM COLOUR: AS PER ARCHITECT/OWNER | ㉑ HIGH WALL MOUNTED LOW PROFILE VENT KIT. COLOUR: AS PER ARCHITECT/OWNER (REFER TO MECHANICAL) |
| ⑩ COMPOSITE PANEL SYSTEM AND MATCHING TRIM OR APPROVED ALTERNATE COLOUR: AS PER ARCHITECT/OWNER | ㉒ CAST IN PLACE CONCRETE MECHANICAL WELL. EXACT LOCATION AND HEIGHT ABOVE FLOOR LEVEL TO BE DETERMINED BY OWNER/CONTRACTOR. (REFER TO MECHANICAL) |
| ⑪ HORIZONTAL COMPOSITE SIDING OR APPROVED ALTERNATE COLOUR: AS PER ARCHITECT/OWNER | ㉓ INTAKE/EXHAUST LOUVERS AT MECHANICAL WELL. EXACT LOCATION AND HEIGHT ABOVE FLOOR LEVEL TO BE DETERMINED BY OWNER/CONTRACTOR. (REFER TO MECHANICAL) |
| ⑫ VERTICAL COMPOSITE TRIM AT BUILDING CORNERS (TYPICAL) COLOUR: AS PER ARCHITECT/OWNER | |

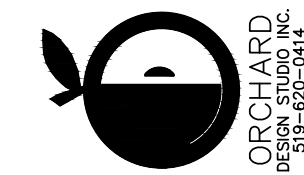

gb architect inc.
430 ONTARIO STREET
STRATFORD, ONTARIO, N5A 3J2
PHONE (519) 272-0073 FAX (519) 272-4433

*Guy R. Bellemeur, B. Arch., OAA, MRAC
Principal Architect of GB ARCHITECT INC. is the
designer for this project with respect to all architectural
work identified on this drawing sheet. The Ontario
Association of Architects (OAA) has reviewed the
drawing and found it to be in accordance with the
Professional Act and Regulations.
Guy R. Bellemeur, B. Arch., OAA, MRAC
Principal Architect
B.C.A. Number 487
as per requirements of the Ministry of Municipal
Affairs & Housing Bill 124.
The Architect above has exercised responsible control with
respect to design activities. The Architect's seal number is their
B.C.A. number.

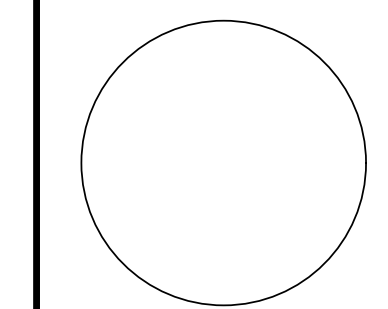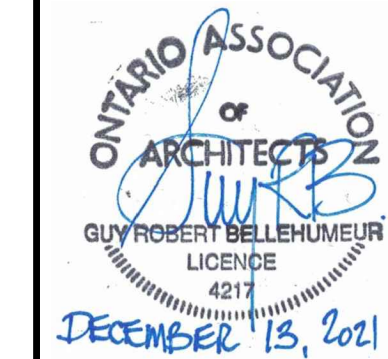

STATUS	DESIGN DEVELOPMENT	21-12-13	6	ISSUED FOR PERMIT
FOLDER	MARTIN-MILVERTON	21-12-08	5	ISSUED TO CONSULTANTS
FILE	14705_A3-ELEV_BLK 17.dwg	21-11-24	4	ISSUED TO CONSULTANTS
SCALE	1/4" = 1'-0"	21-11-09	3	REVISED FOR SPA (1st SUBMISSION)
DRAWN BY	JED	21-09-16	2	ISSUED FOR SPA (1st SUBMISSION)
DATE	APRIL 2021	21-08-24	1	ISSUED FOR OFFICIAL PLAN AMENDMENT
REVISION		DATE	No.	REVISION
JOB No.	14705			

PROJECT	MILVERTON APARTMENT BUILDING
CLIENT	MILVERTON ONTARIO
TITLE	BLOCK 17 EAST ELEVATION


SHEET No. **A3.3**



1 SOUTH ELEVATION - BLOCK 17
A3.4 1/4" = 1'-0"
* WINDOWS EXCLUDED FROM BLOCK 19 DUE TO SPATIAL SEPARATION REQUIREMENTS (REFER TO ELEVATION)



MATERIALS LEGEND:

- | | |
|--|---|
| 1 CAST-IN-PLACE CONCRETE FOOTING (REFER TO STRUCTURAL) | 13 VINYL WINDOW THERMALLY BROKEN, SEALED DOUBLE GLAZED UNITS WITH OPERABLE CASEMENT AS SHOWN (TYPICAL) COLOUR: WHITE |
| 2 CAST-IN-PLACE CONCRETE FOUNDATION WALL (REFER TO STRUCTURAL) | 14 METAL CLAD TERRACE DOOR THERMALLY BROKEN, SEALED DOUBLE GLAZED UNITS AS SHOWN (TYPICAL) COLOUR: WHITE |
| 3 EXPOSED CONCRETE FOUNDATION MIN. 6" FROM GRADE TO MASONRY VENEER | 15 METAL INSULATED MANDOOK. REFER TO PLAN FOR SIZE AND LOCATION |
| 4 APPROXIMATE FINISHED GRADE | 16 HVAC VENT/LOUVER (TYPICAL) AT HVAC WALL SLEEVE PROVIDE INSULATION KIT TO INCLUDE THREE SECTIONS OF 5/8" FOIL FACED DUCTBOARD PAINTED BLACK ON SITE (REFER TO MECHANICAL) |
| 5 BRICK VENEER 1 COLOUR: AS PER ARCHITECT/OWNER GROUT: AS PER ARCHITECT/OWNER | 17 PREFINISHED METAL FASCIA, TRIM AND EAVESTROUGH |
| 6 BRICK VENEER 2 COLOUR: AS PER ARCHITECT/OWNER GROUT: AS PER ARCHITECT/OWNER | 18 PREFINISHED METAL FLASHING |
| 7 PRECAST SILL BETWEEN MASONRY VENEERS AND SIDING (TYPICAL) | 19 ASPHALT SHINGLE OR APPROVED ALTERNATE COLOUR: AS PER ARCHITECT/OWNER |
| 8 BRICK VENEER SOLDIER COURSE COLOUR: AS PER ARCHITECT/OWNER GROUT: AS PER ARCHITECT/OWNER | 20 LANDSCAPE RETAINING WALL (REFER TO SITE PLAN AND CIVIL) |
| 9 COMPOSITE WINDOW TRIM COLOUR: AS PER ARCHITECT/OWNER | 21 HIGH WALL MOUNTED LOW PROFILE VENT KIT. COLOUR: AS PER ARCHITECT/OWNER (REFER TO MECHANICAL) |
| 10 COMPOSITE PANEL SYSTEM AND MATCHING TRIM OR APPROVED ALTERNATE COLOUR: AS PER ARCHITECT/OWNER | 22 CAST IN PLACE CONCRETE MECHANICAL WELL. EXACT LOCATION AND HEIGHT ABOVE FLOOR LEVEL TO BE DETERMINED BY OWNER/CONTRACTOR. (REFER TO MECHANICAL) |
| 11 HORIZONTAL COMPOSITE SIDING OR APPROVED ALTERNATE COLOUR: AS PER ARCHITECT/OWNER | 23 INTAKE/EXHAUST LOUVERS AT MECHANICAL WELL. EXACT LOCATION AND HEIGHT ABOVE FLOOR LEVEL TO BE DETERMINED BY OWNER/CONTRACTOR. (REFER TO MECHANICAL) |
| 12 VERTICAL COMPOSITE TRIM AT BUILDING CORNERS (TYPICAL) COLOUR: AS PER ARCHITECT/OWNER | |

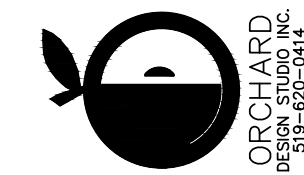

gb architect inc.
430 ONTARIO STREET
STRATFORD, ONTARIO, N5A 3Z2
PHONE (519) 272-0073 FAX (519) 272-4433


*Guy R. Bellemeur, B. Arch., OAA, MRAC
Principal Architect of GB ARCHITECT INC. is the
designer for this project with respect to all architectural
work identified on this drawing sheet. The Ontario
Architectural Association (OAA) has reviewed this
drawing sheet and found it to be in compliance with
the requirements of the Ministry of Municipal
Affairs & Housing Bill 124.
The Architect above has exercised responsible control with
respect to design activities. The Architect's seal number is their
B.C.D.S. number.

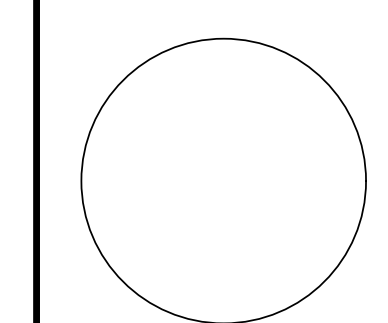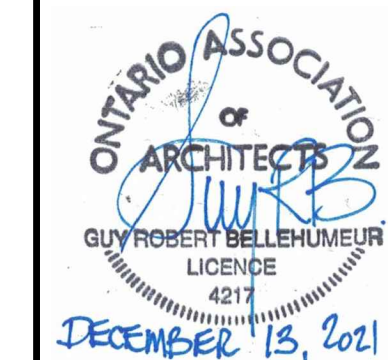

STATUS	DESIGN DEVELOPMENT	21-12-13	6	ISSUED FOR PERMIT
FOLDER	MARTIN-MILVERTON	21-12-08	5	ISSUED TO CONSULTANTS
FILE	14705_A3-ELEV_BLK 17.dwg	21-11-24	4	ISSUED TO CONSULTANTS
SCALE	1/4" = 1'-0"	21-11-08	3	REVISED FOR SPA (1st SUBMISSION)
DATE	APRIL 2021	21-09-16	2	ISSUED FOR SPA (1st SUBMISSION)
REVISION		21-08-24	1	ISSUED FOR OFFICIAL PLAN AMENDMENT
JOB No.	14705	DATE	No.	REVISION


PROJECT	MILVERTON APARTMENT BUILDING
SHEET No.	MILVERTON ONTARIO BLOCK 17 SOUTH ELEVATION

A3.4

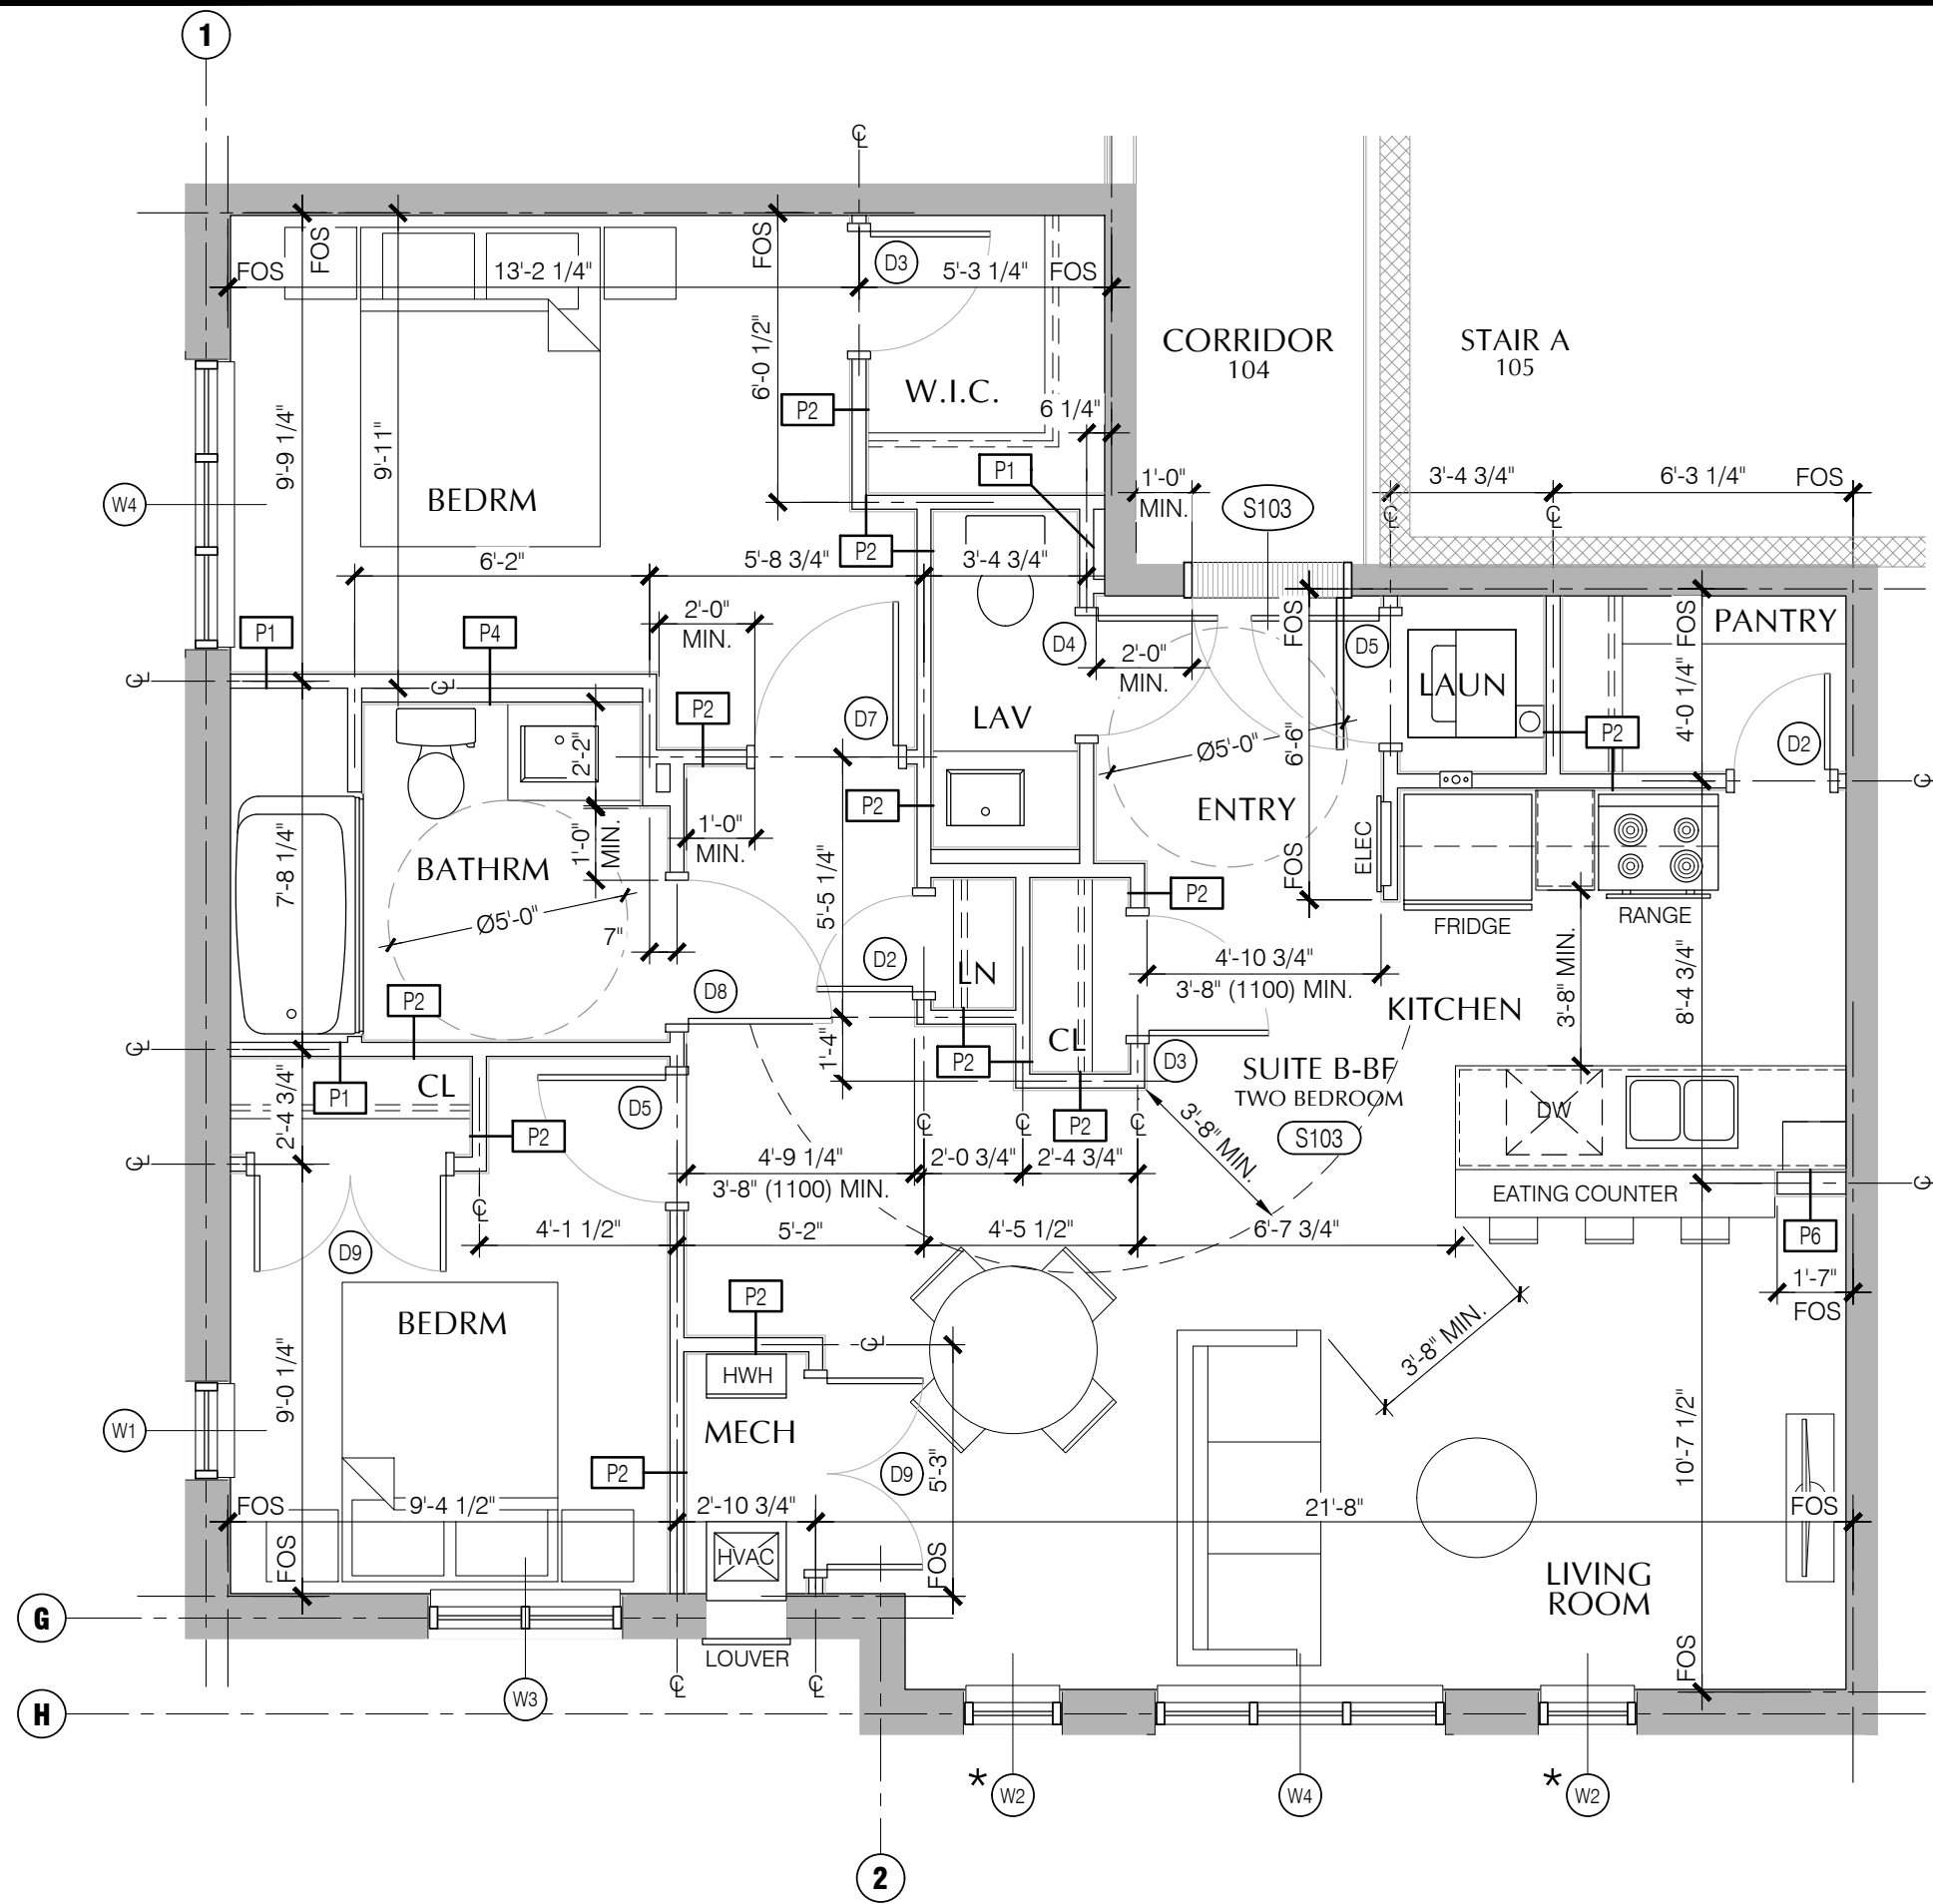


2a SUITE B-BF (S103) - ENLARGED FLOOR PLAN
A4.1 1/4" = 1'-0"

SUITE B-BF - AREA CALCULATIONS			
GROSS FLOOR AREA (TARION STANDARDS)	985.20 ft ²	91.5 m ²	
NET FLOOR AREA	886.95 ft ²	82.4 m ²	
BALCONY AREA	N/A ft ²	N/A m ²	

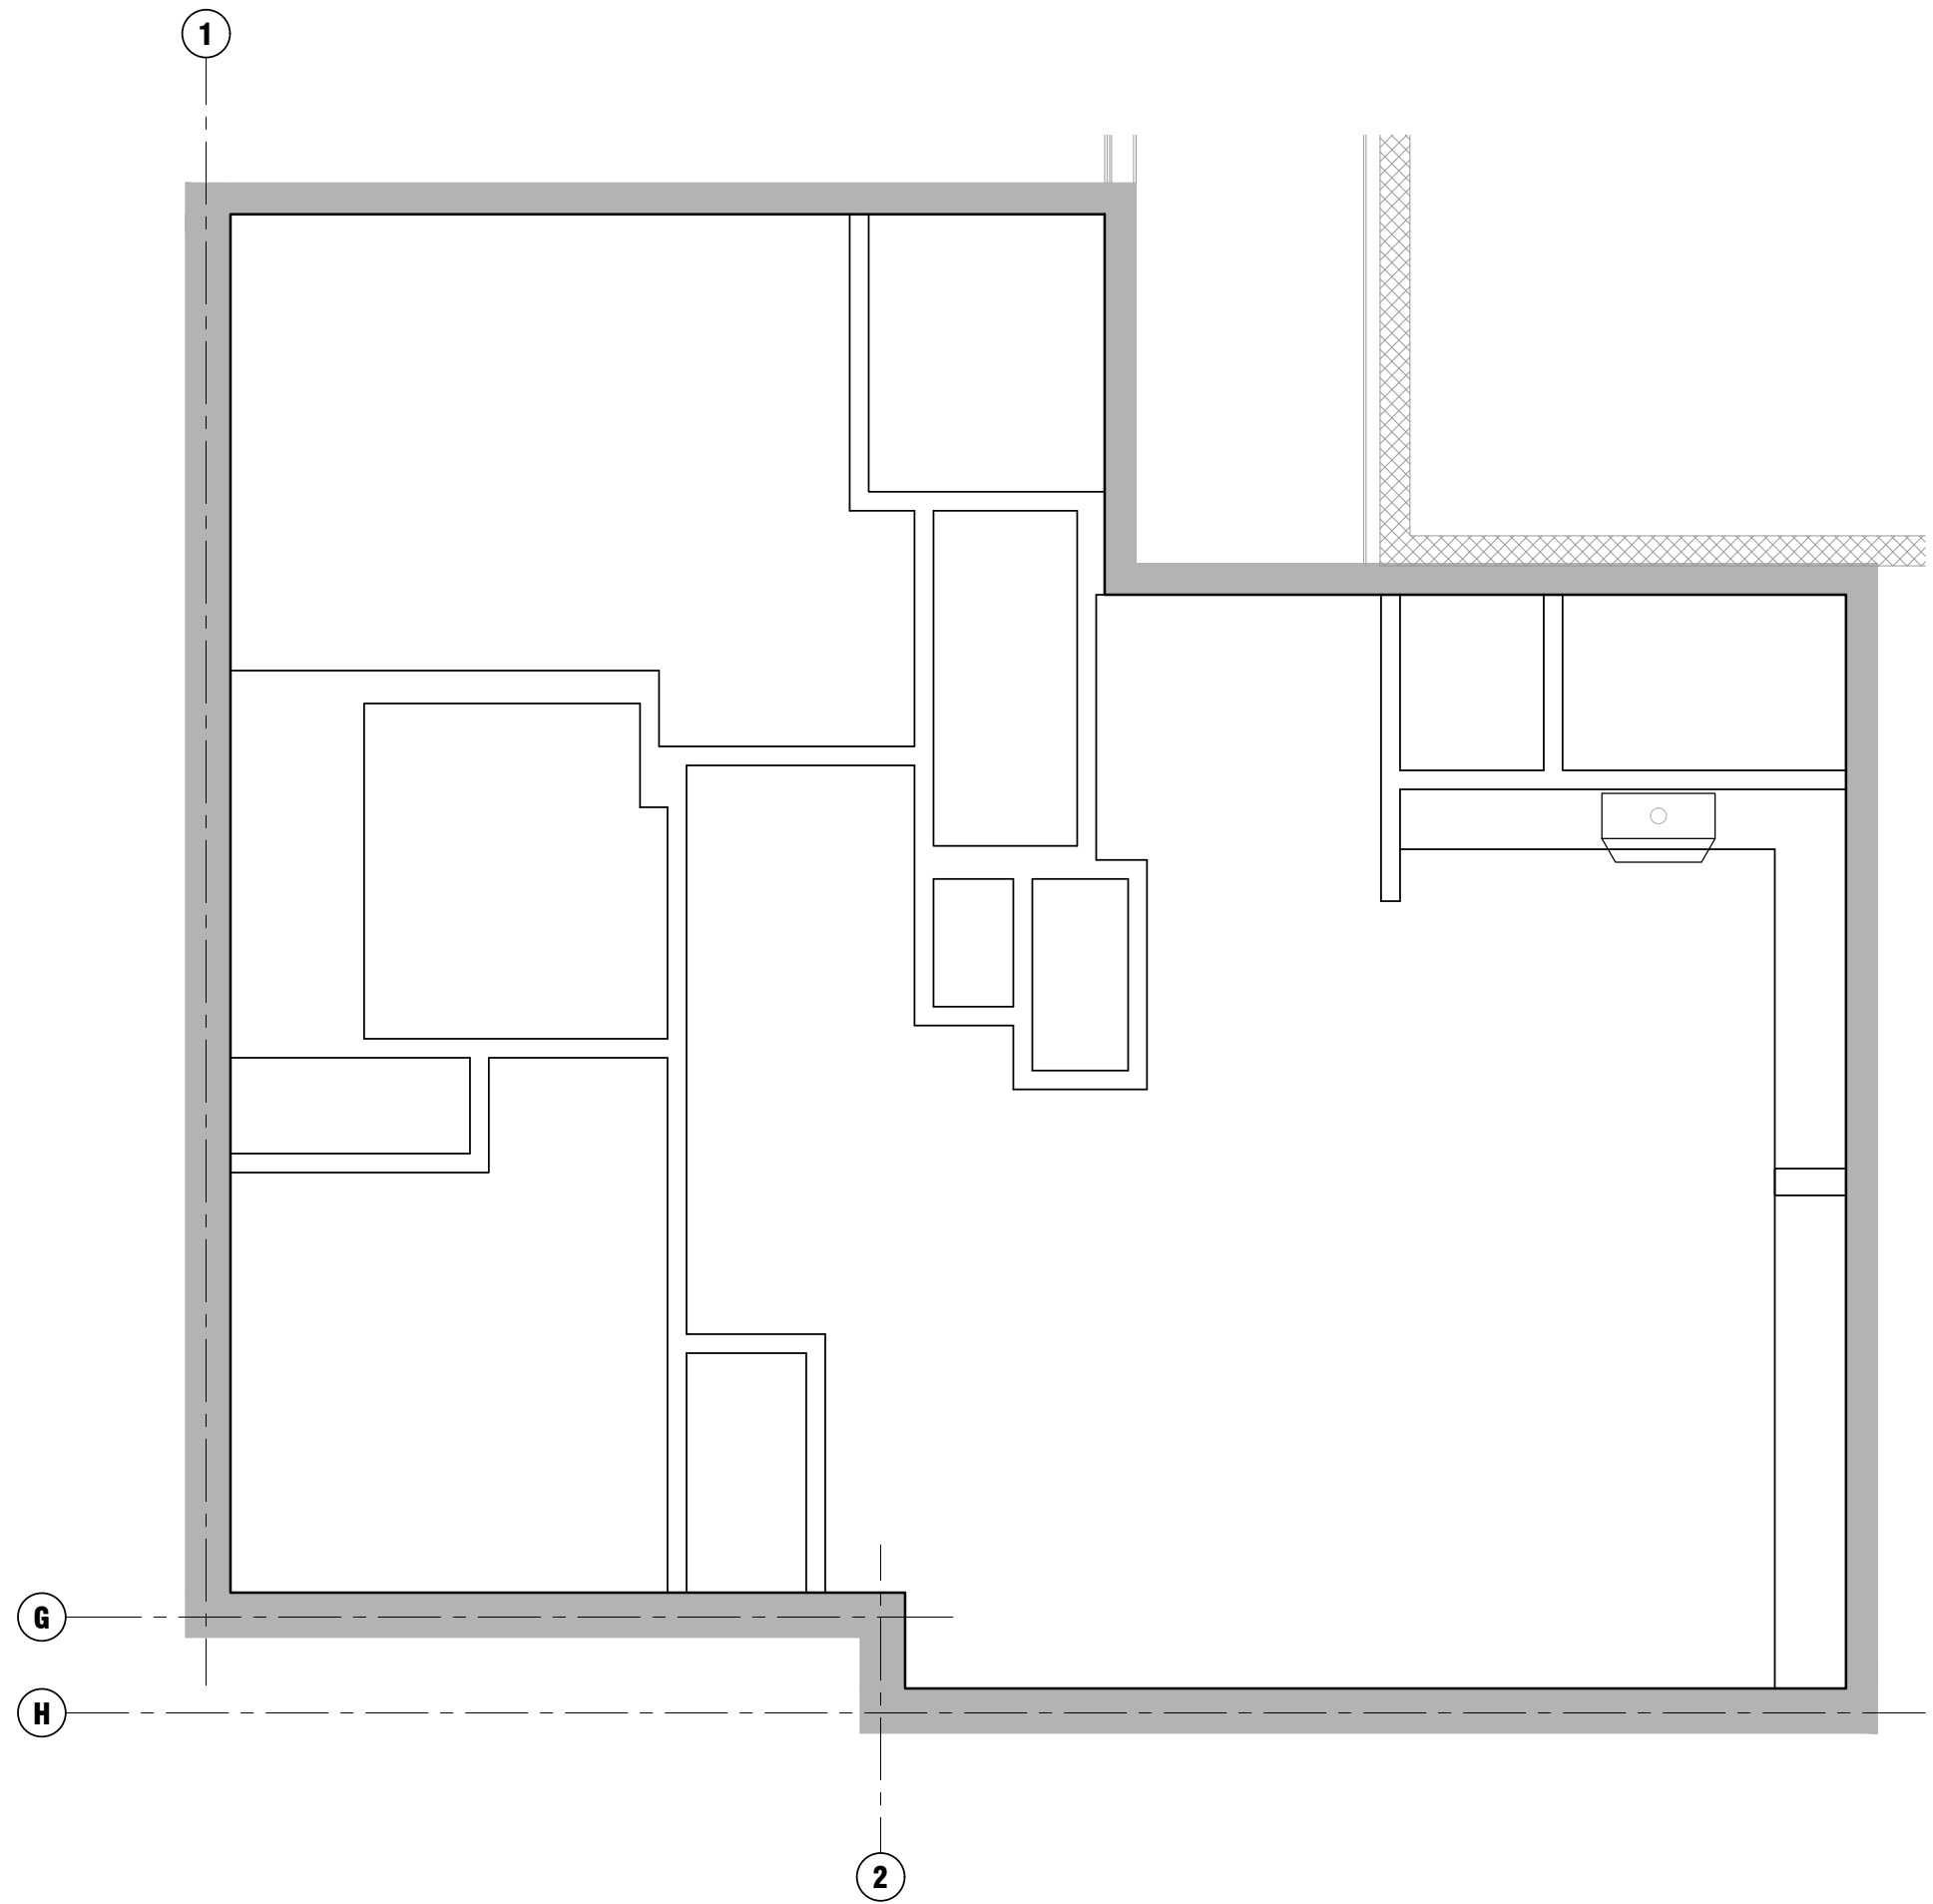


2b SUITE B-BF (S103) - REFLECTED CEILING PLAN
A4.1 1/4" = 1'-0"

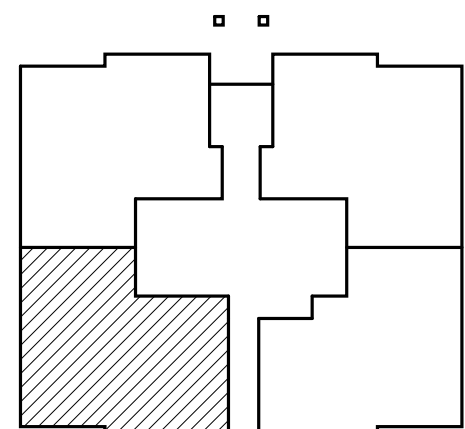


LEVEL 1 KEY PLAN

* WINDOWS EXCLUDED FROM BLOCK 19 DUE TO SPATIAL SEPARATION REQUIREMENTS (REFER TO ELEVATION)

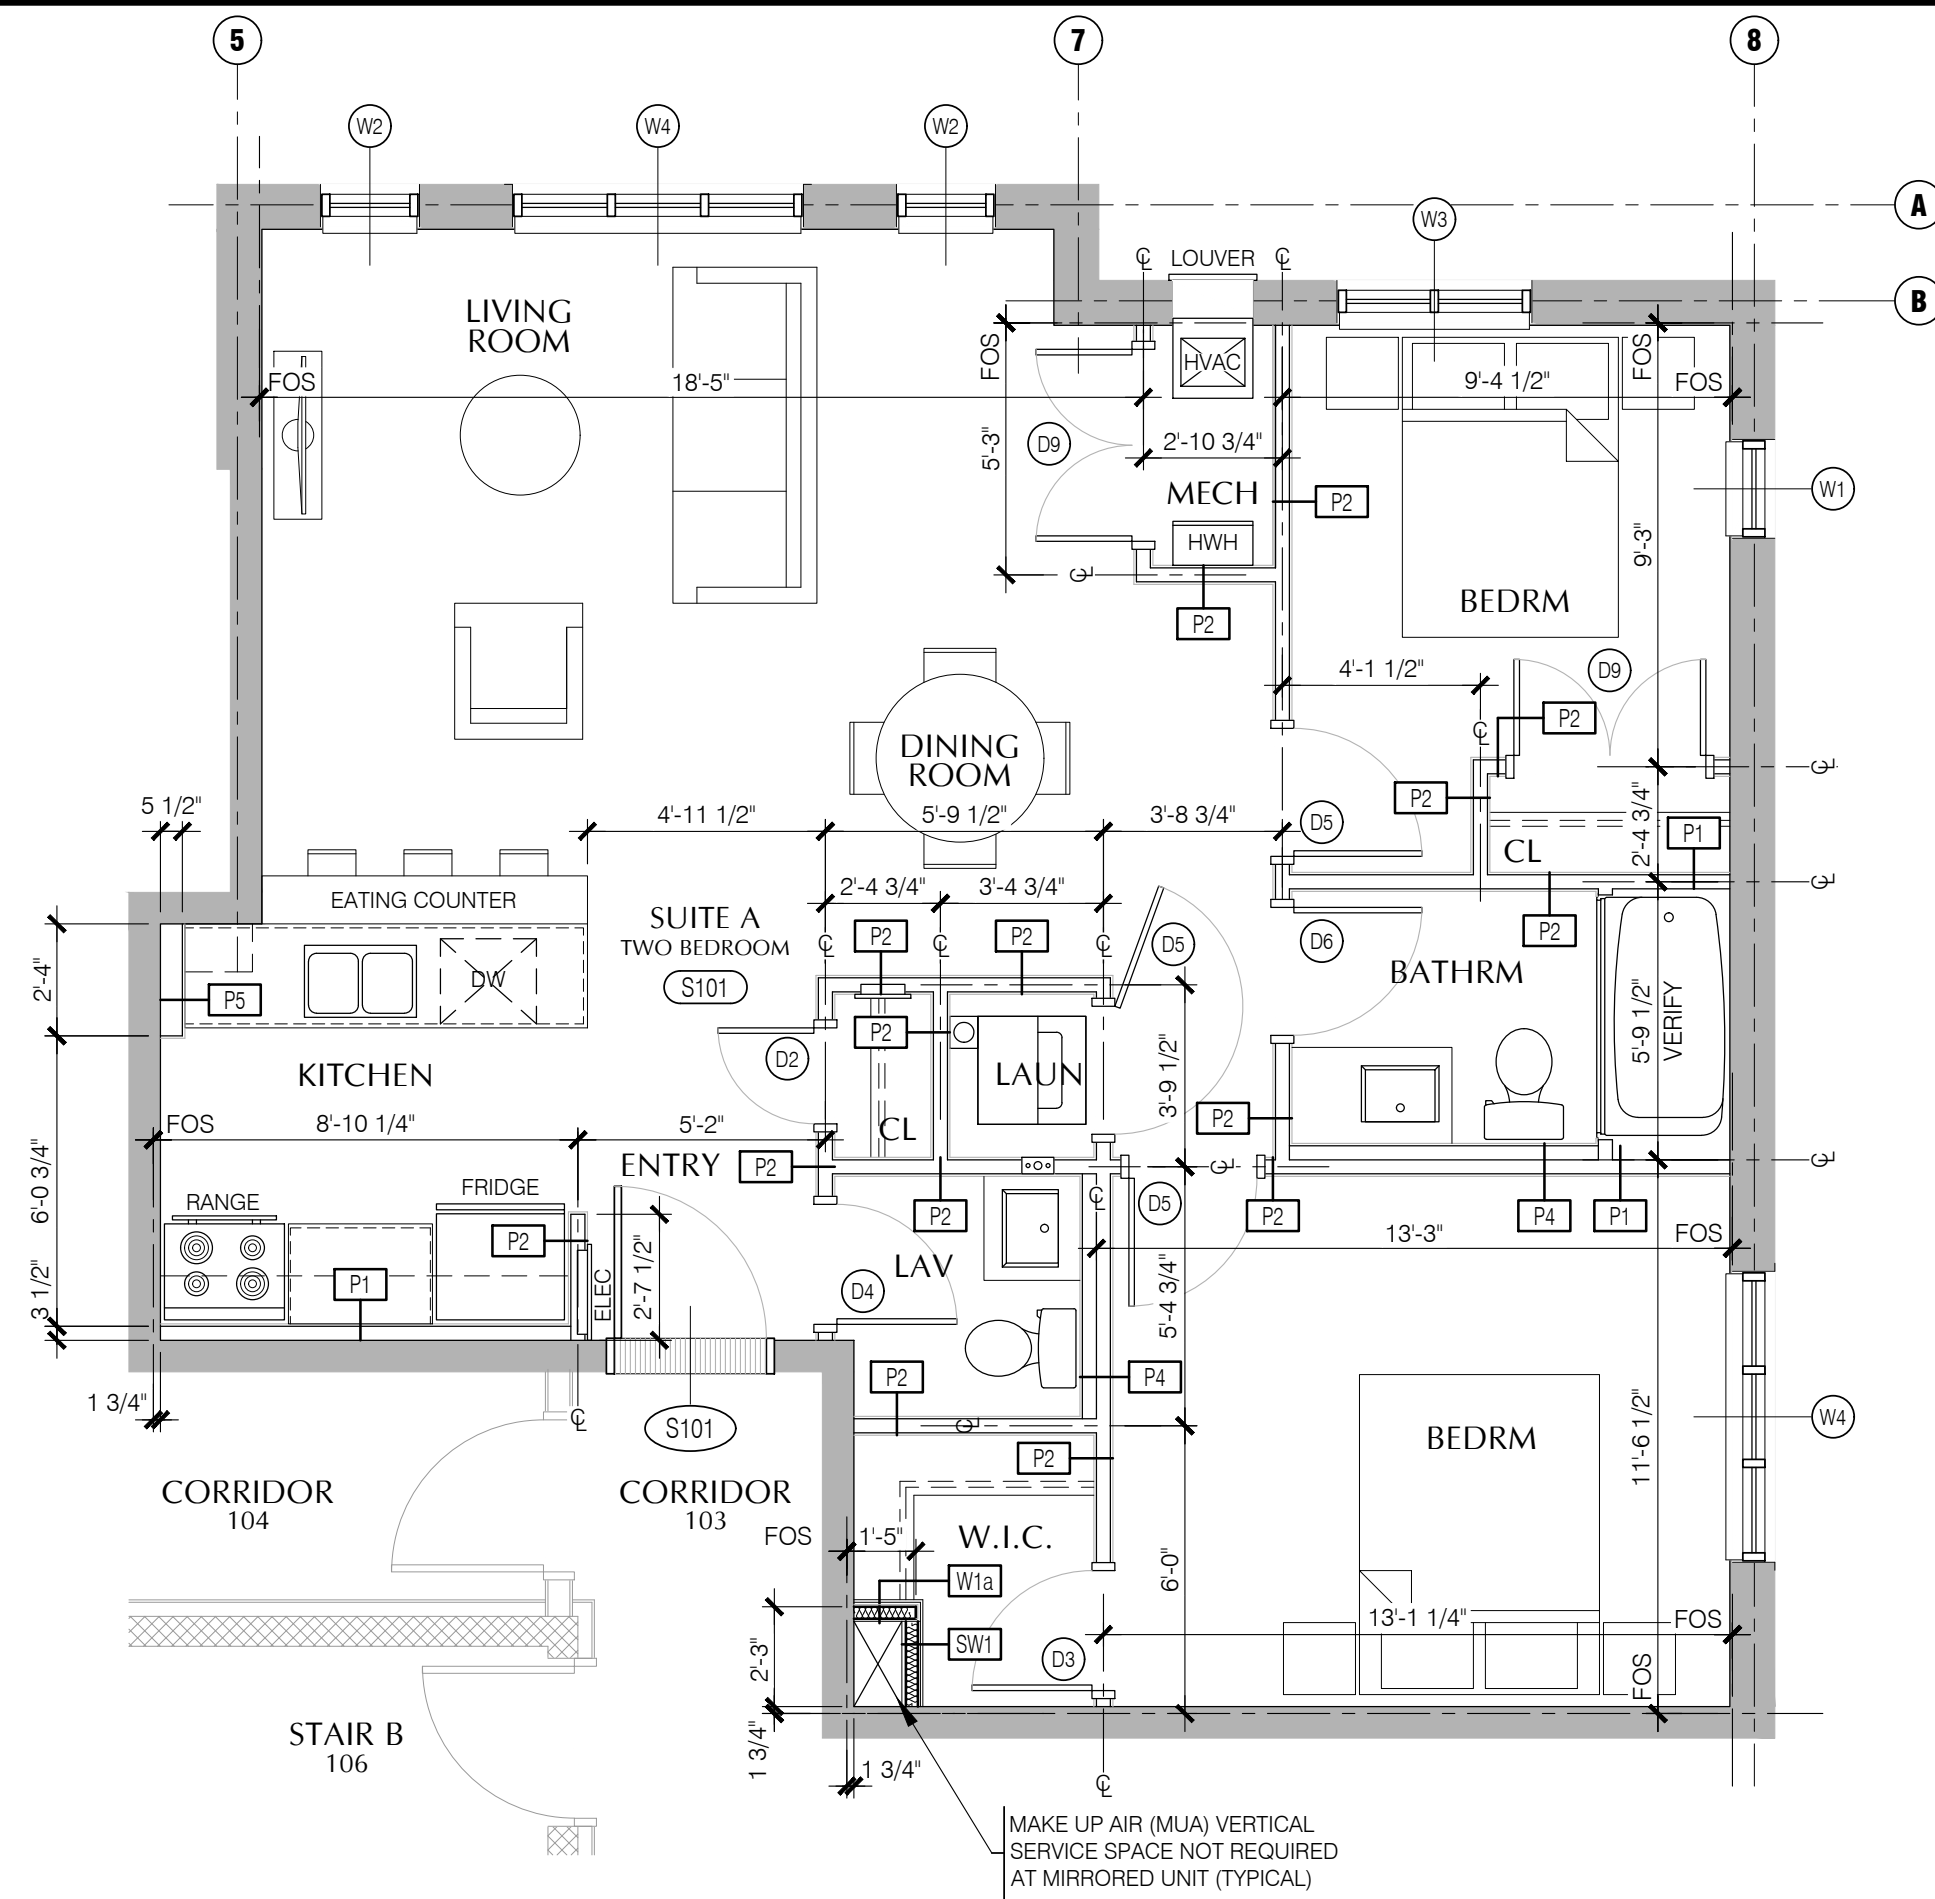


1a SUITE A (S101) - ENLARGED FLOOR PLAN
A4.1 1/4" = 1'-0"


SUITE A - AREA CALCULATIONS			
GROSS FLOOR AREA (TARION STANDARDS)	935.60 ft ²	86.9 m ²	
NET FLOOR AREA	837.30 ft ²	77.8 m ²	
BALCONY AREA	N/A ft ²	N/A m ²	

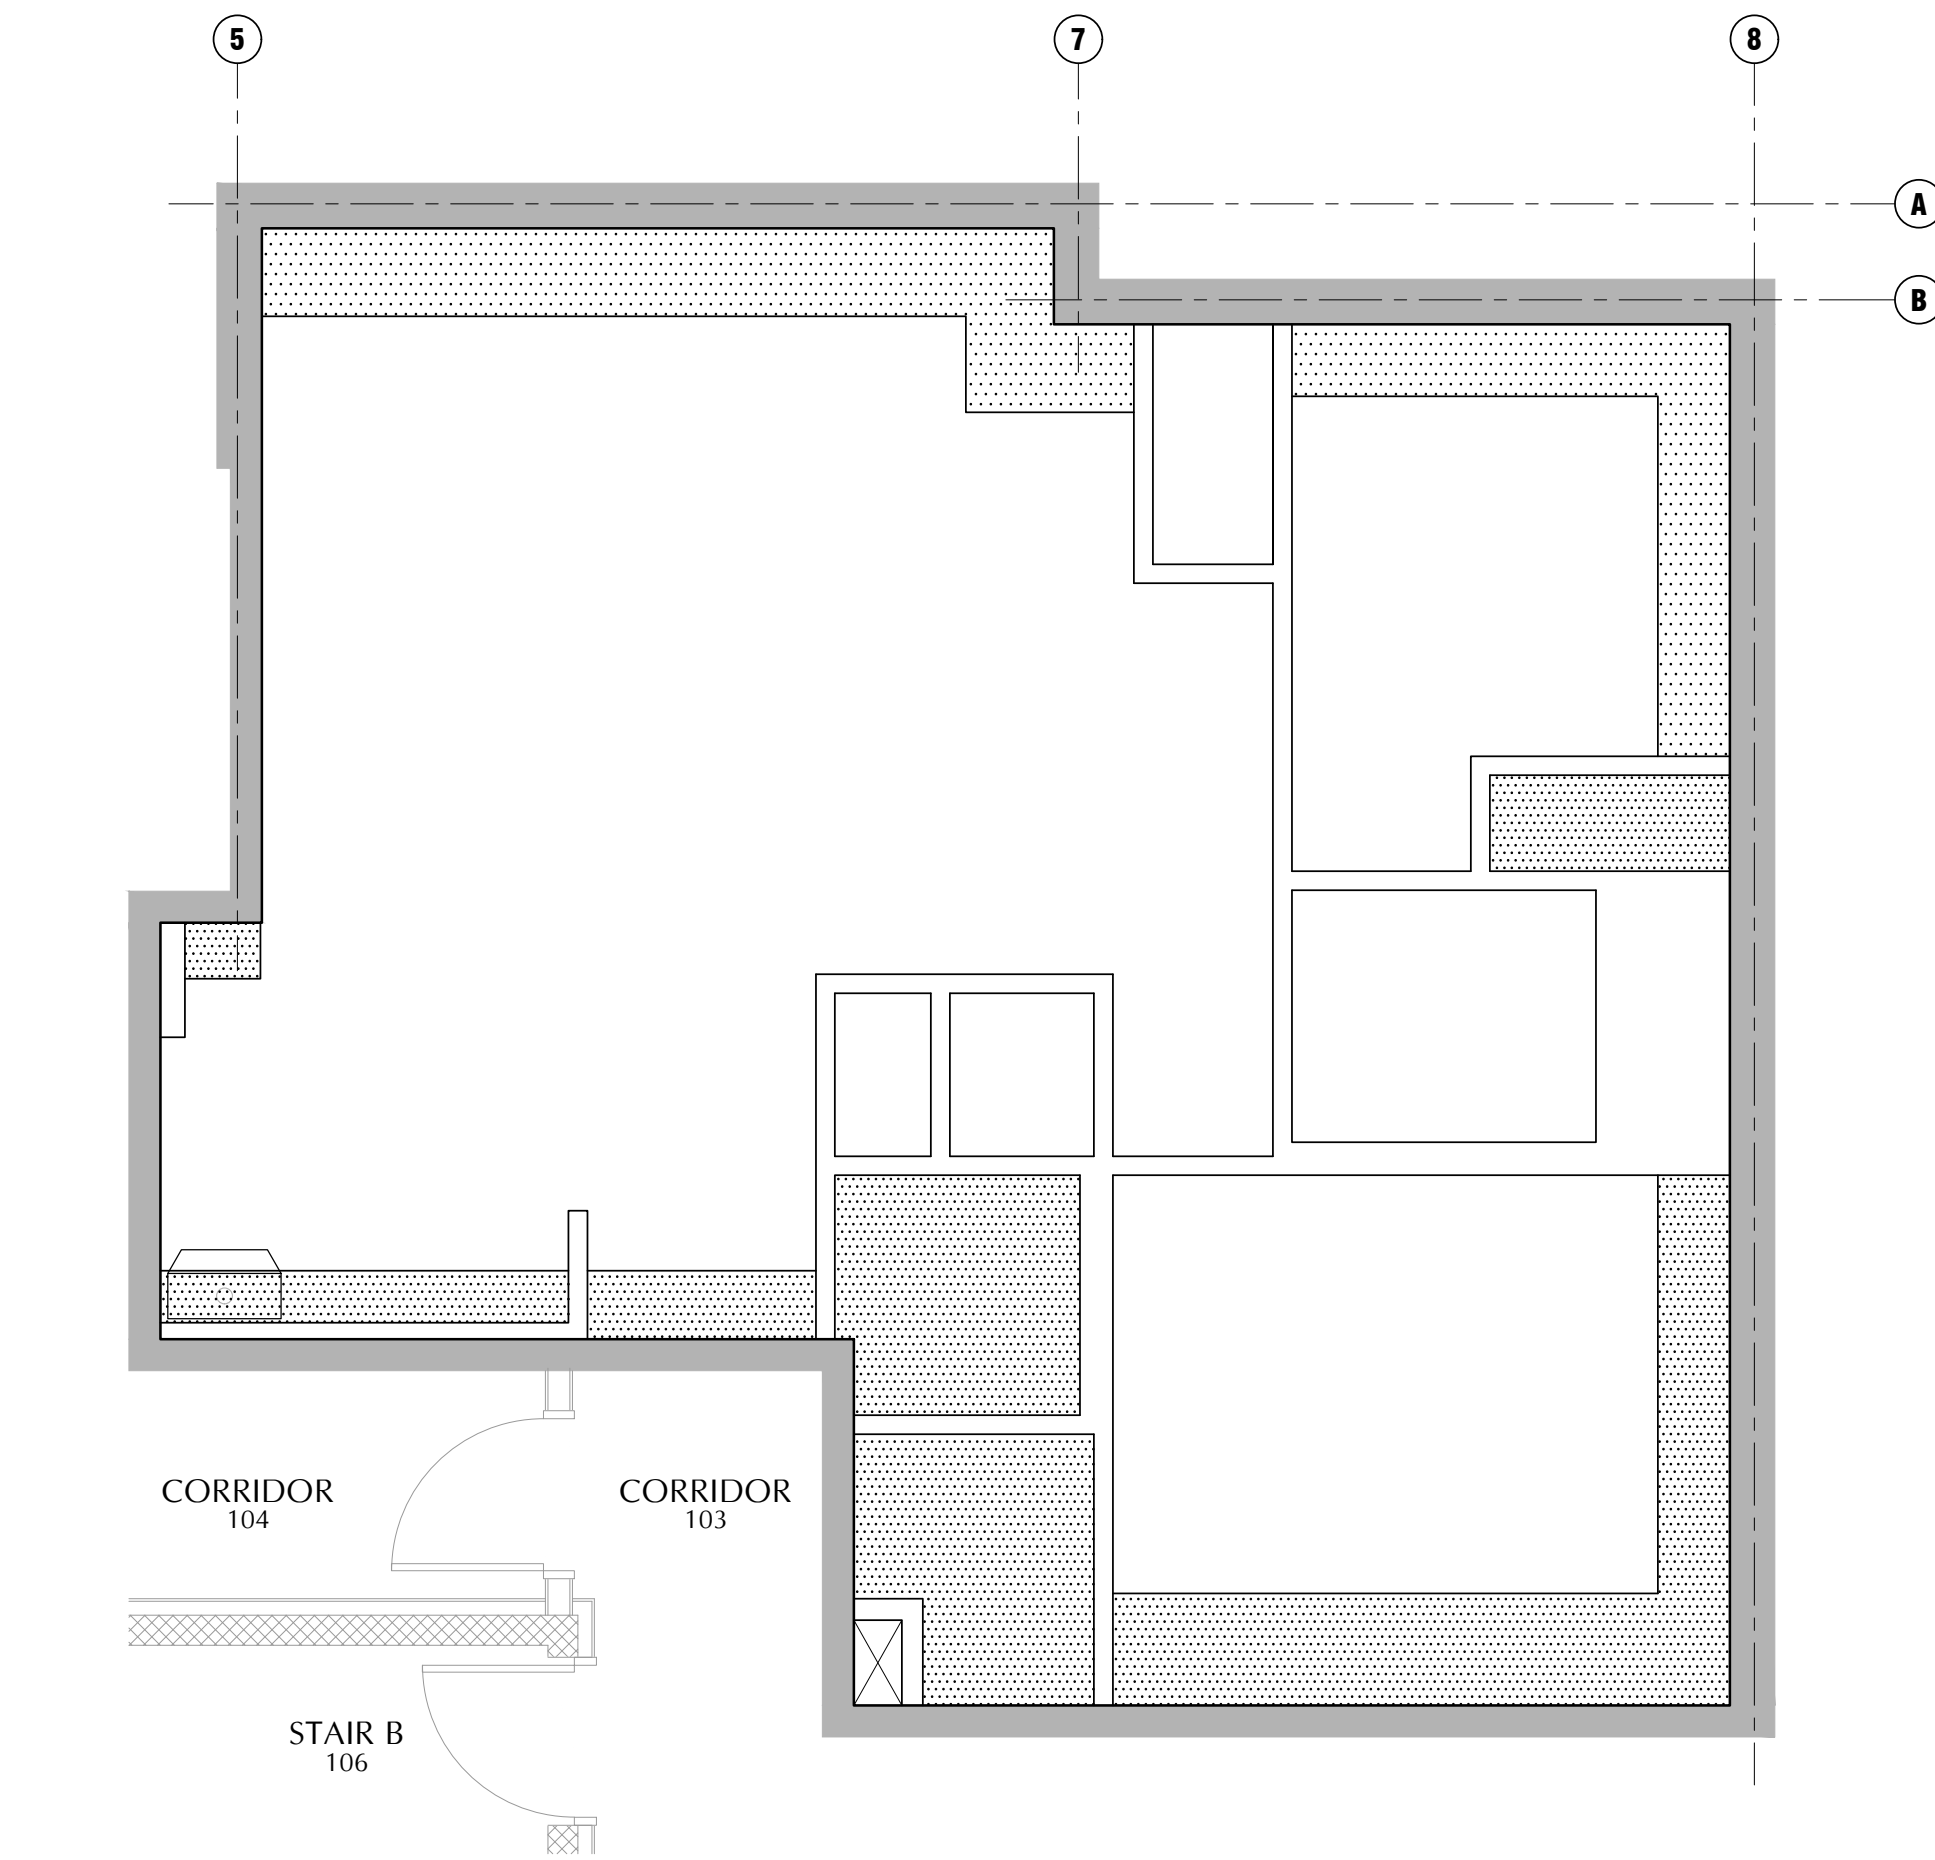

1b SUITE A (S101) - REFLECTED CEILING PLAN
A4.1 1/4" = 1'-0"


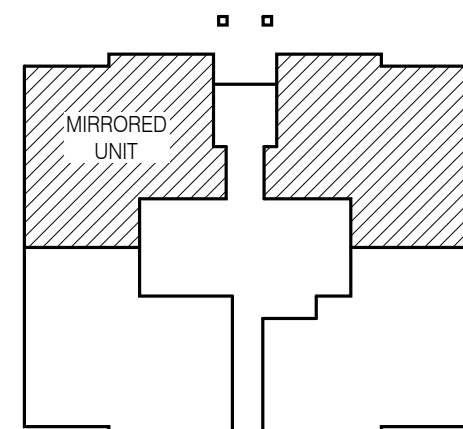


LEVEL 1 KEY PLAN

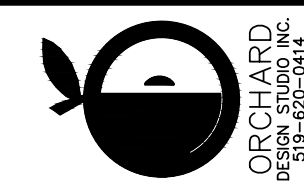


gb architect inc.
430 ONTARIO STREET
STRATFORD, ONTARIO N5A 3Z2
PHONE (519) 272-0073 FAX (519) 272-1433

*Guy R. Bellemare, B. Arch, OAA, MRAC
Principal Architect of GB ARCHITECT INC. is the
designer for this project with respect to all architectural
work identified on this drawing sheet. The Ontario
Architectural Association (OAA) has reviewed the
drawing sheet and found it to be in compliance with
the requirements of the Ministry of Municipal
Affairs & Housing Bill 24.
The Architect above has exercised responsible control with
respect to design activities. The architect's seal number is their
B.C.D.S. number.

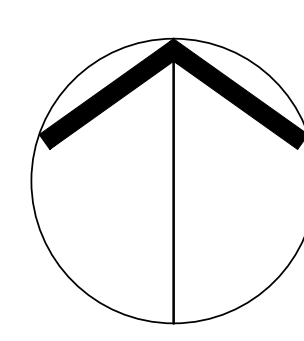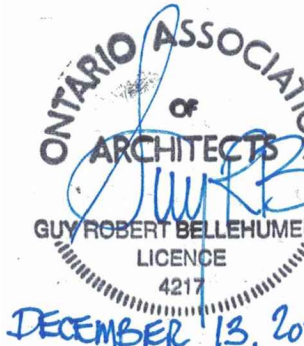


PROJECT		STATUS		DESIGN DEVELOPMENT		REVISION			
MILVERTON APARTMENT BUILDING	MILVERTON ONTARIO	BLOCK 17	ENLARGED SUITE PLANS	21-12-13	6	ISSUED FOR PERMIT			
				21-12-08	5	ISSUED TO CONSULTANTS			
				21-11-24	4	ISSUED TO CONSULTANTS			
				21-11-09	3	REVISED FOR SPA (1st SUBMISSION)			
SHEET No.	A4.1			21-09-16	2	ISSUED FOR SPA (1st SUBMISSION)			
				21-08-24	1	ISSUED FOR OFFICIAL PLAN AMENDMENT			
				DATE	No.	REVISION			
				JOB No.	14705				

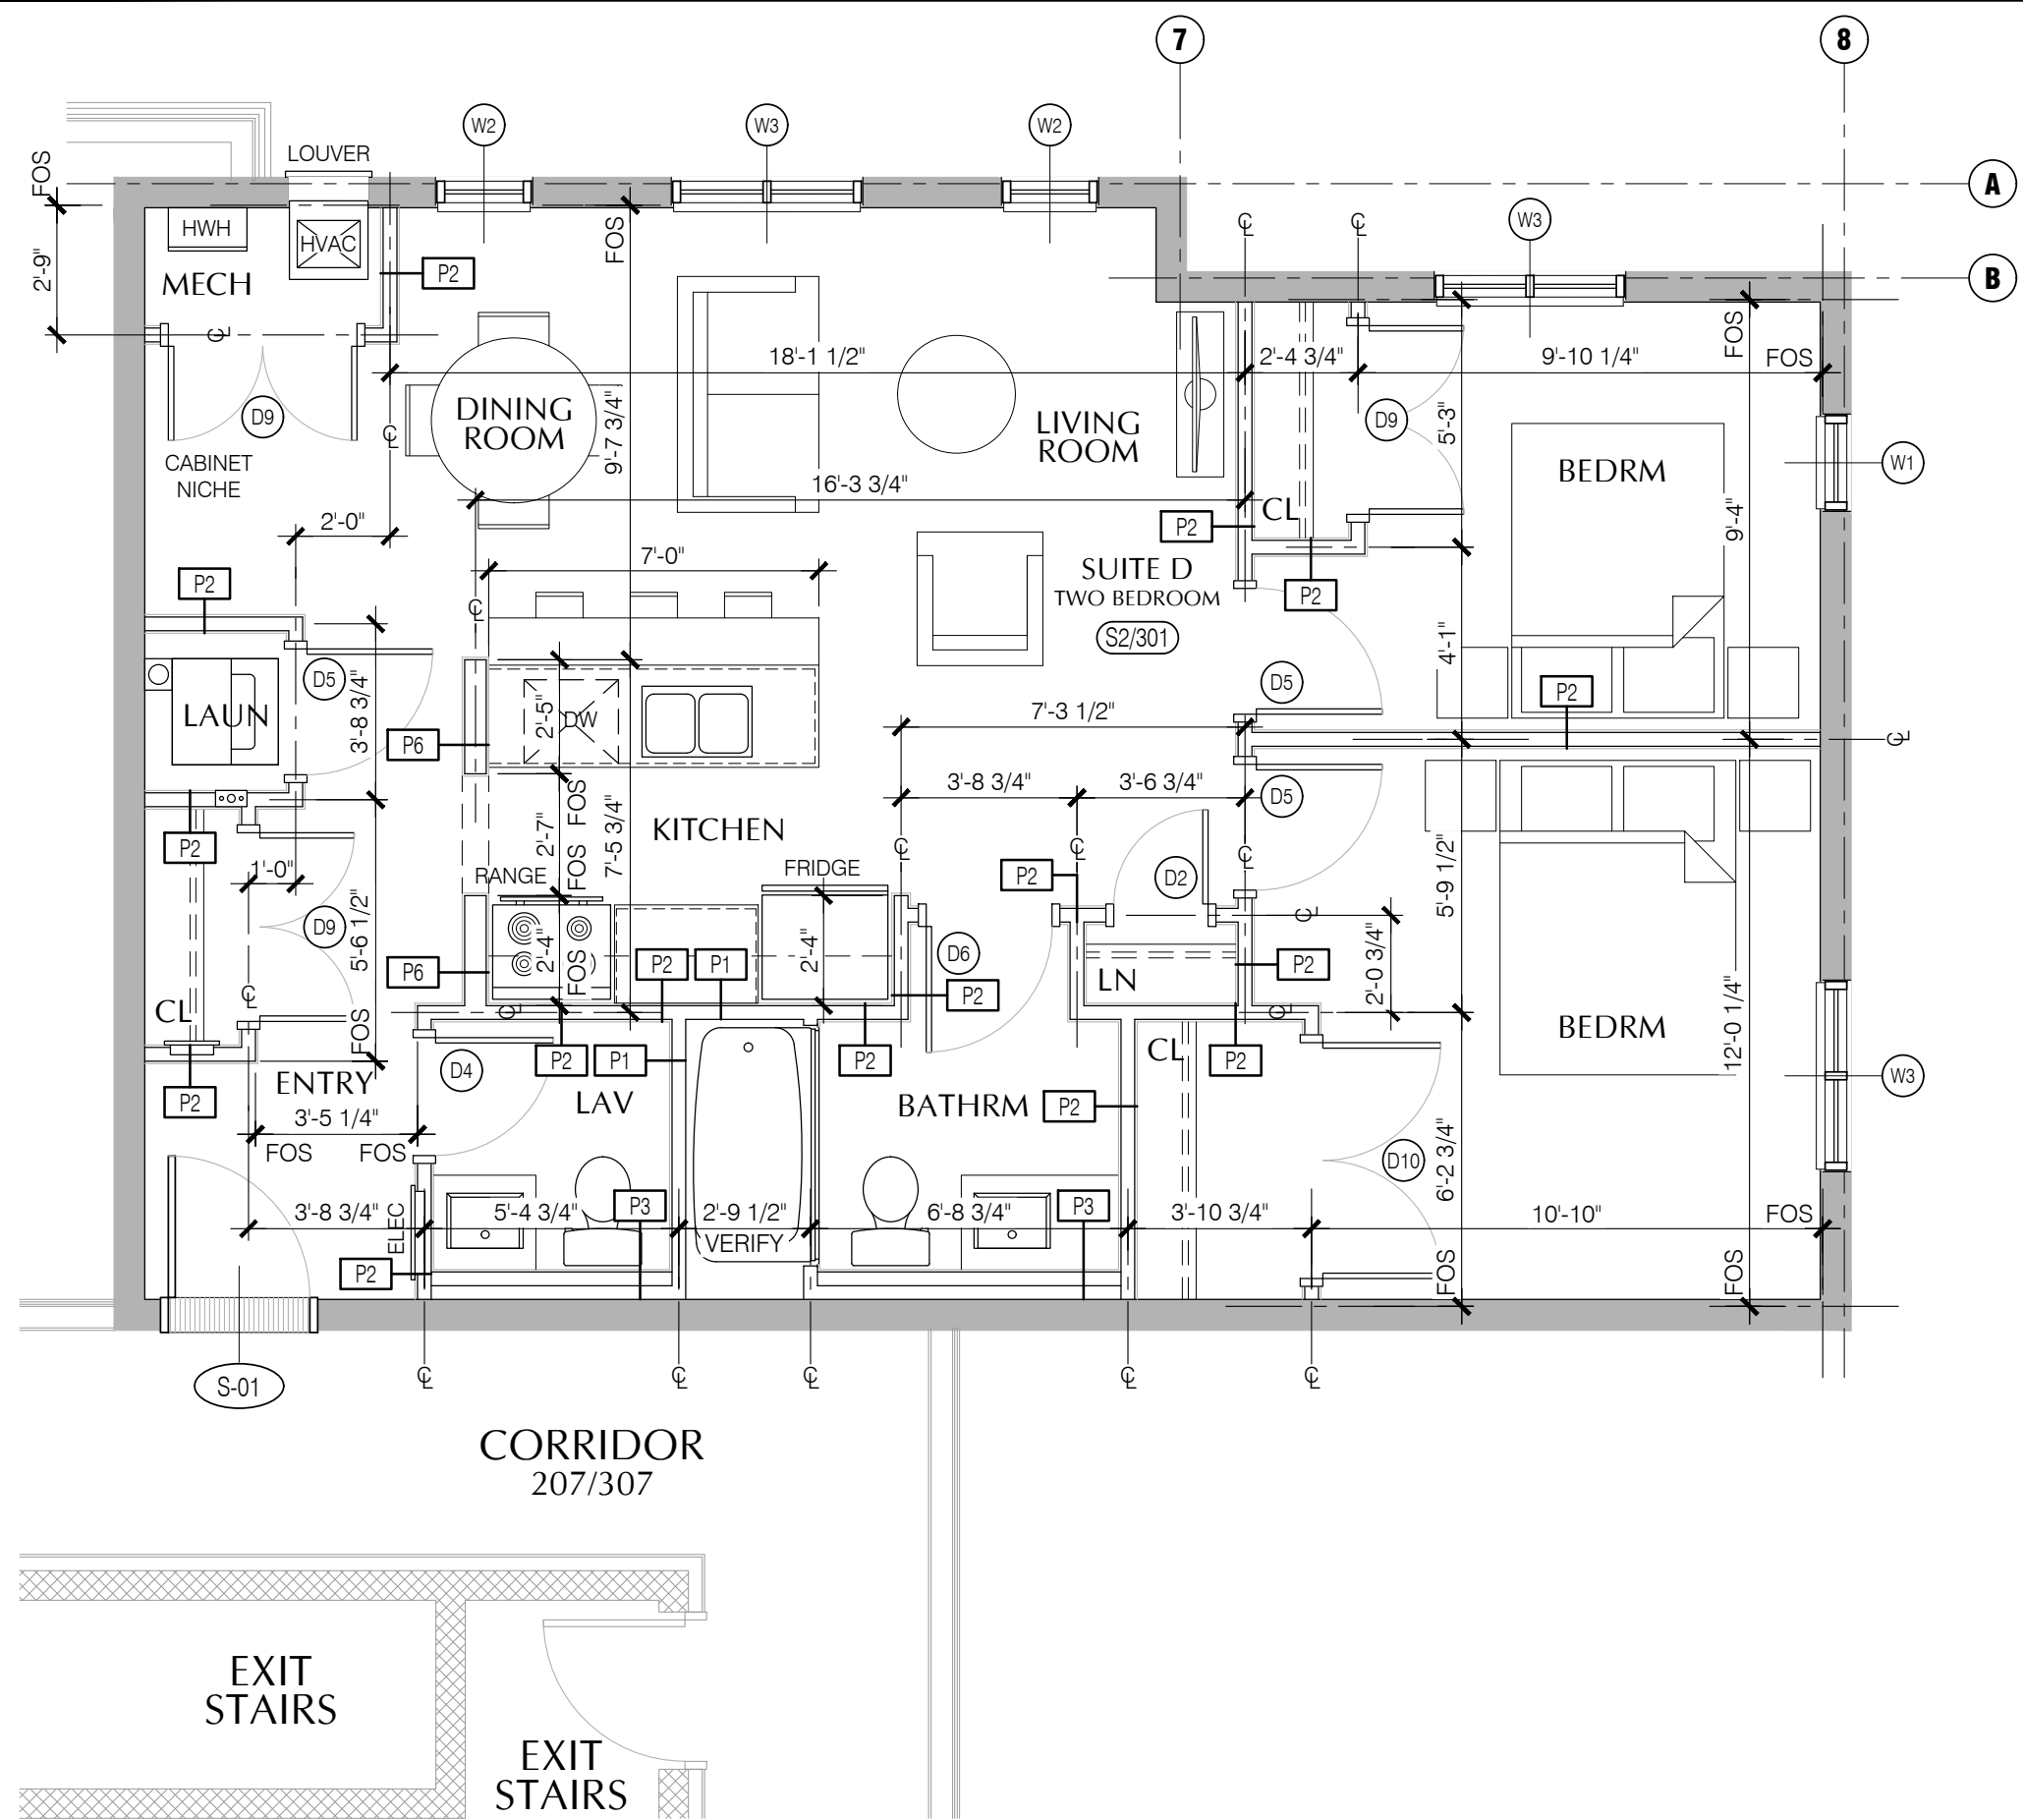


2a SUITE D (S2/301) - ENLARGED FLOOR PLAN
A4.2 1/4" = 1'-0"


SUITE D - AREA CALCULATIONS
GROSS FLOOR AREA (TARION STANDARDS) 857.80 ft² 79.7 m²
NET FLOOR AREA 794.10 ft² 73.8 m²
BALCONY AREA N/A ft² N/A m²

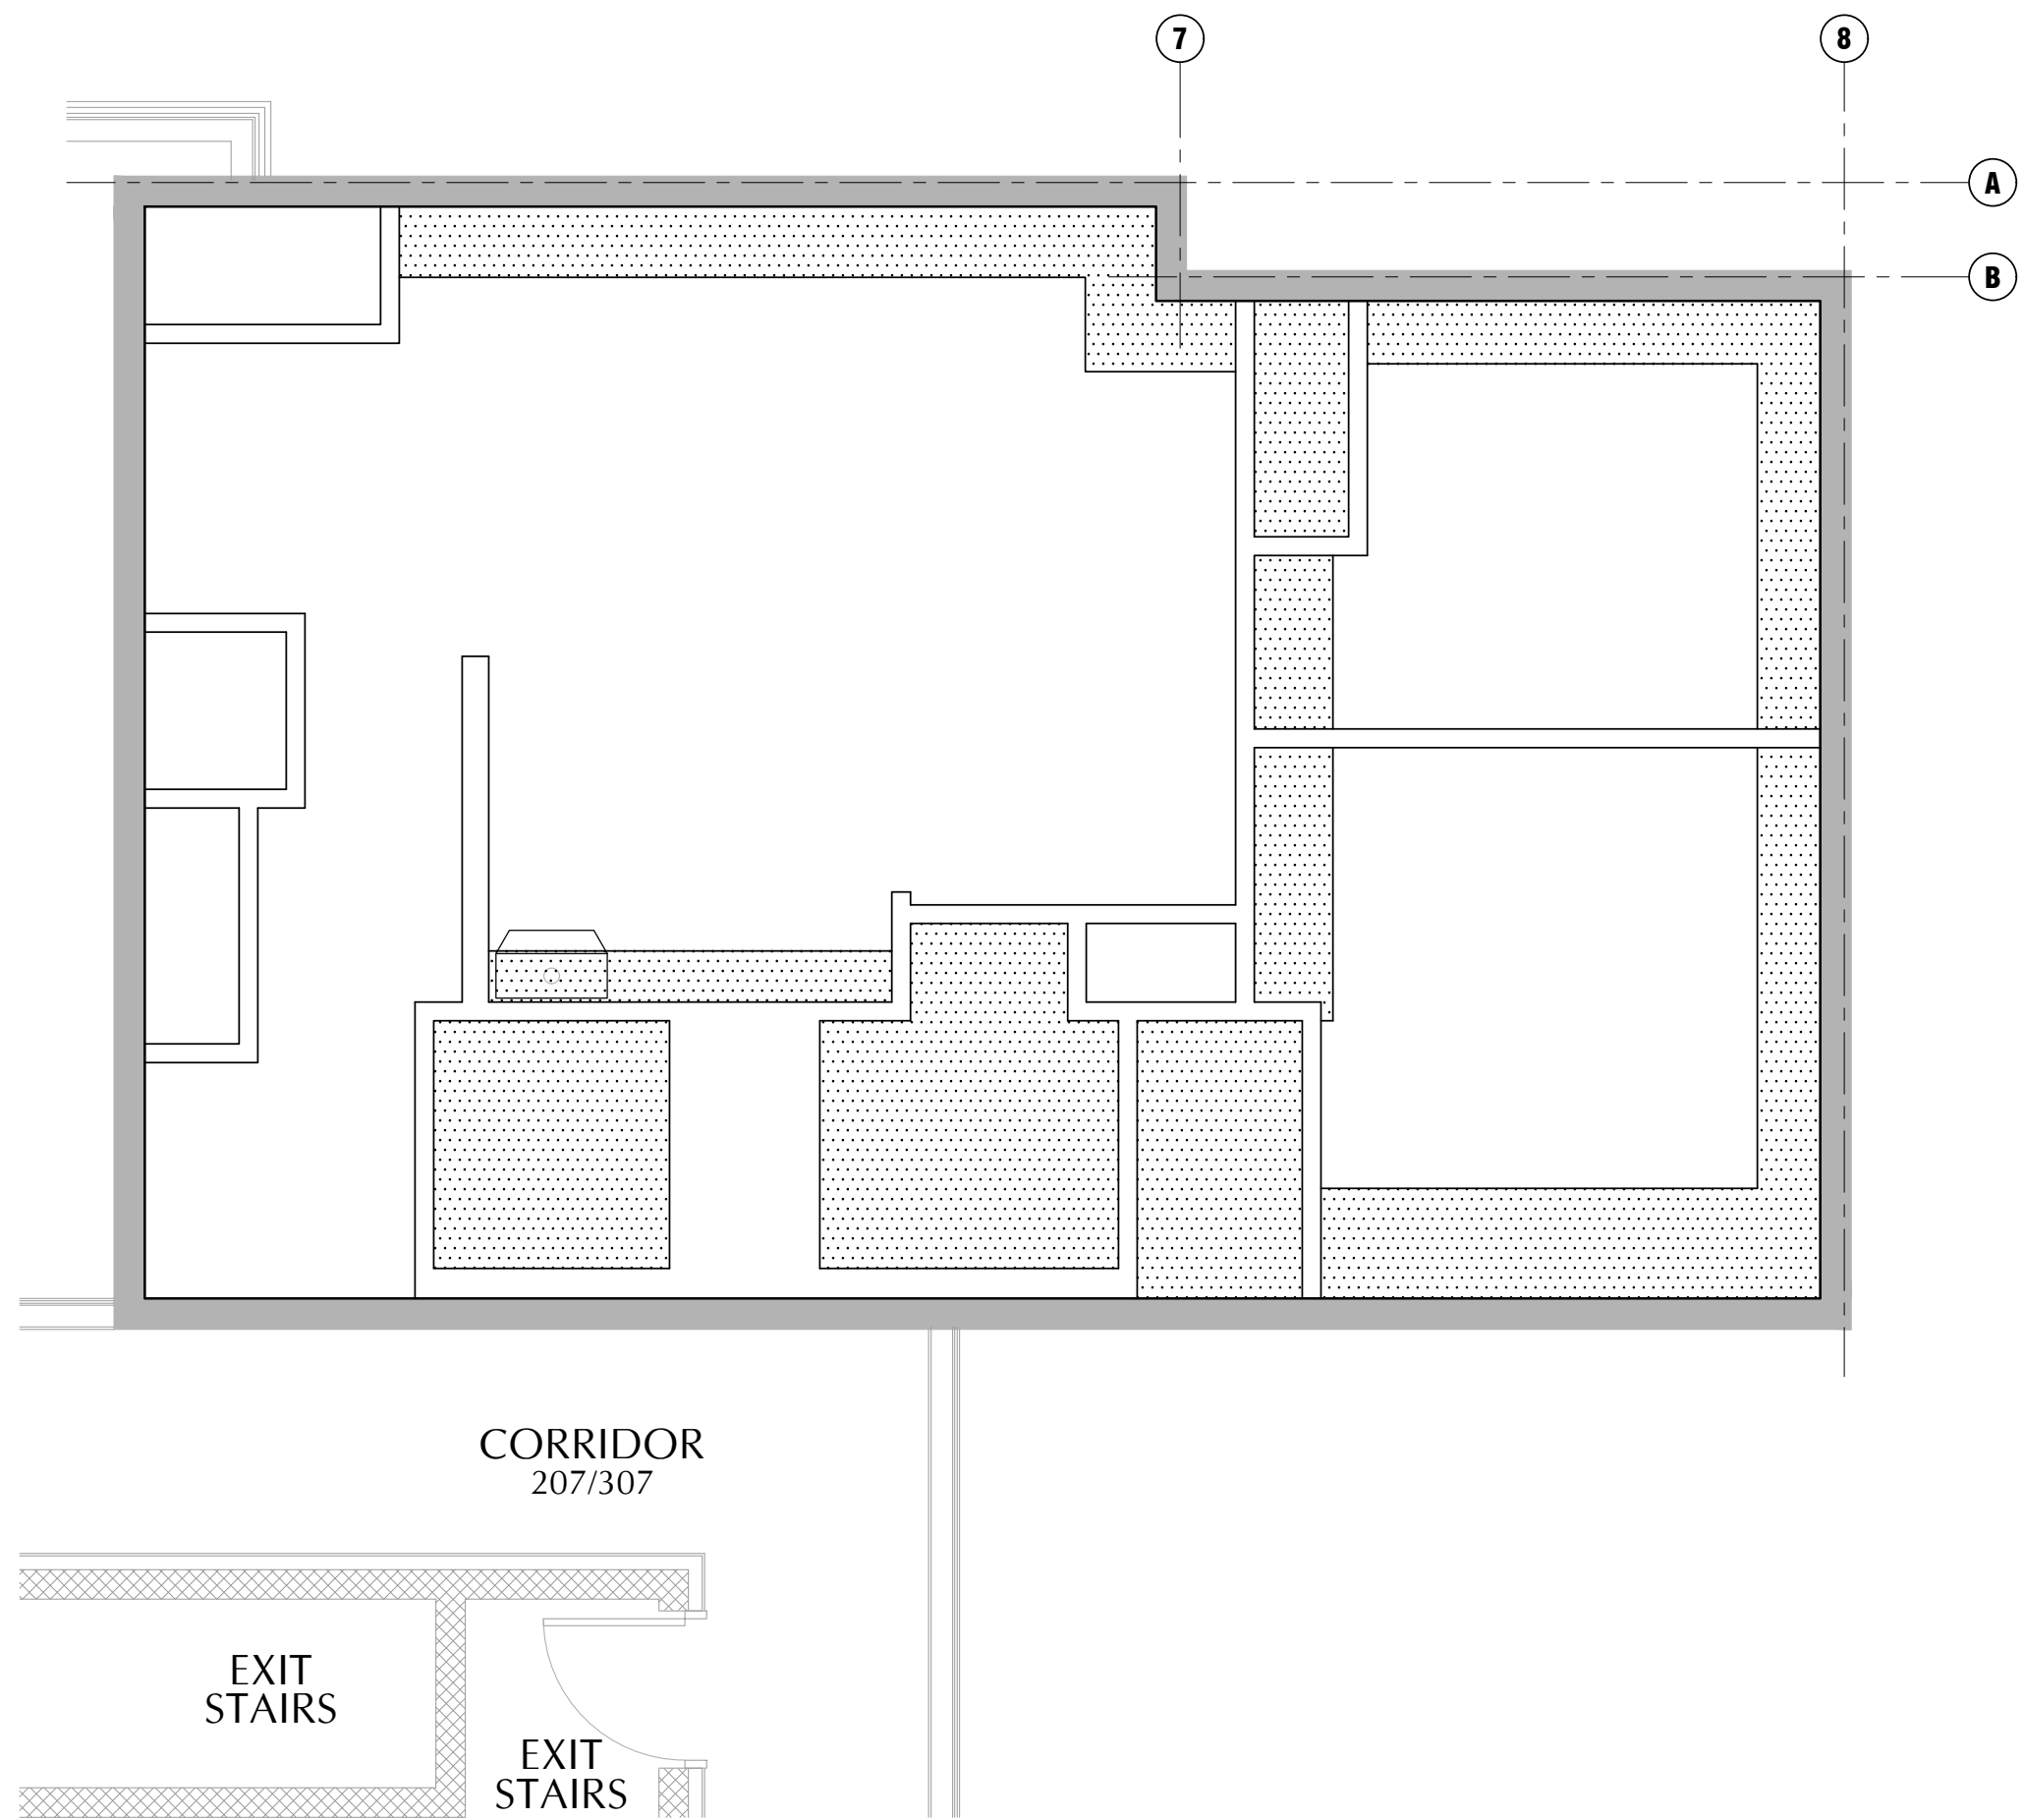


2b SUITE D (S2/301) - REFLECTED CEILING PLAN
A4.2 1/4" = 1'-0"

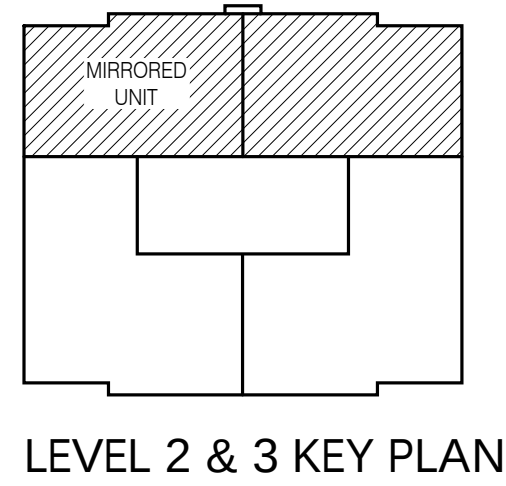

LEVEL 2 & 3 KEY PLAN

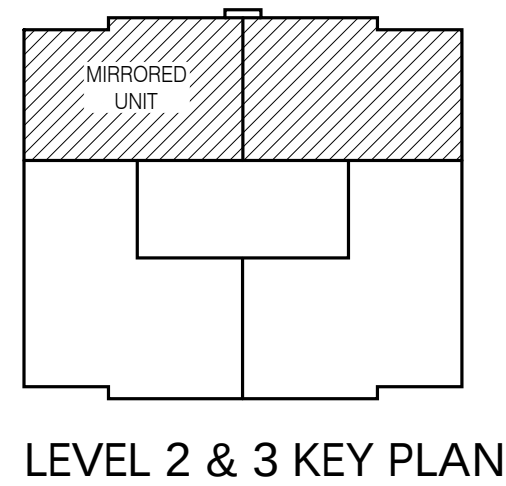


LEVEL 2 & 3 KEY PLAN

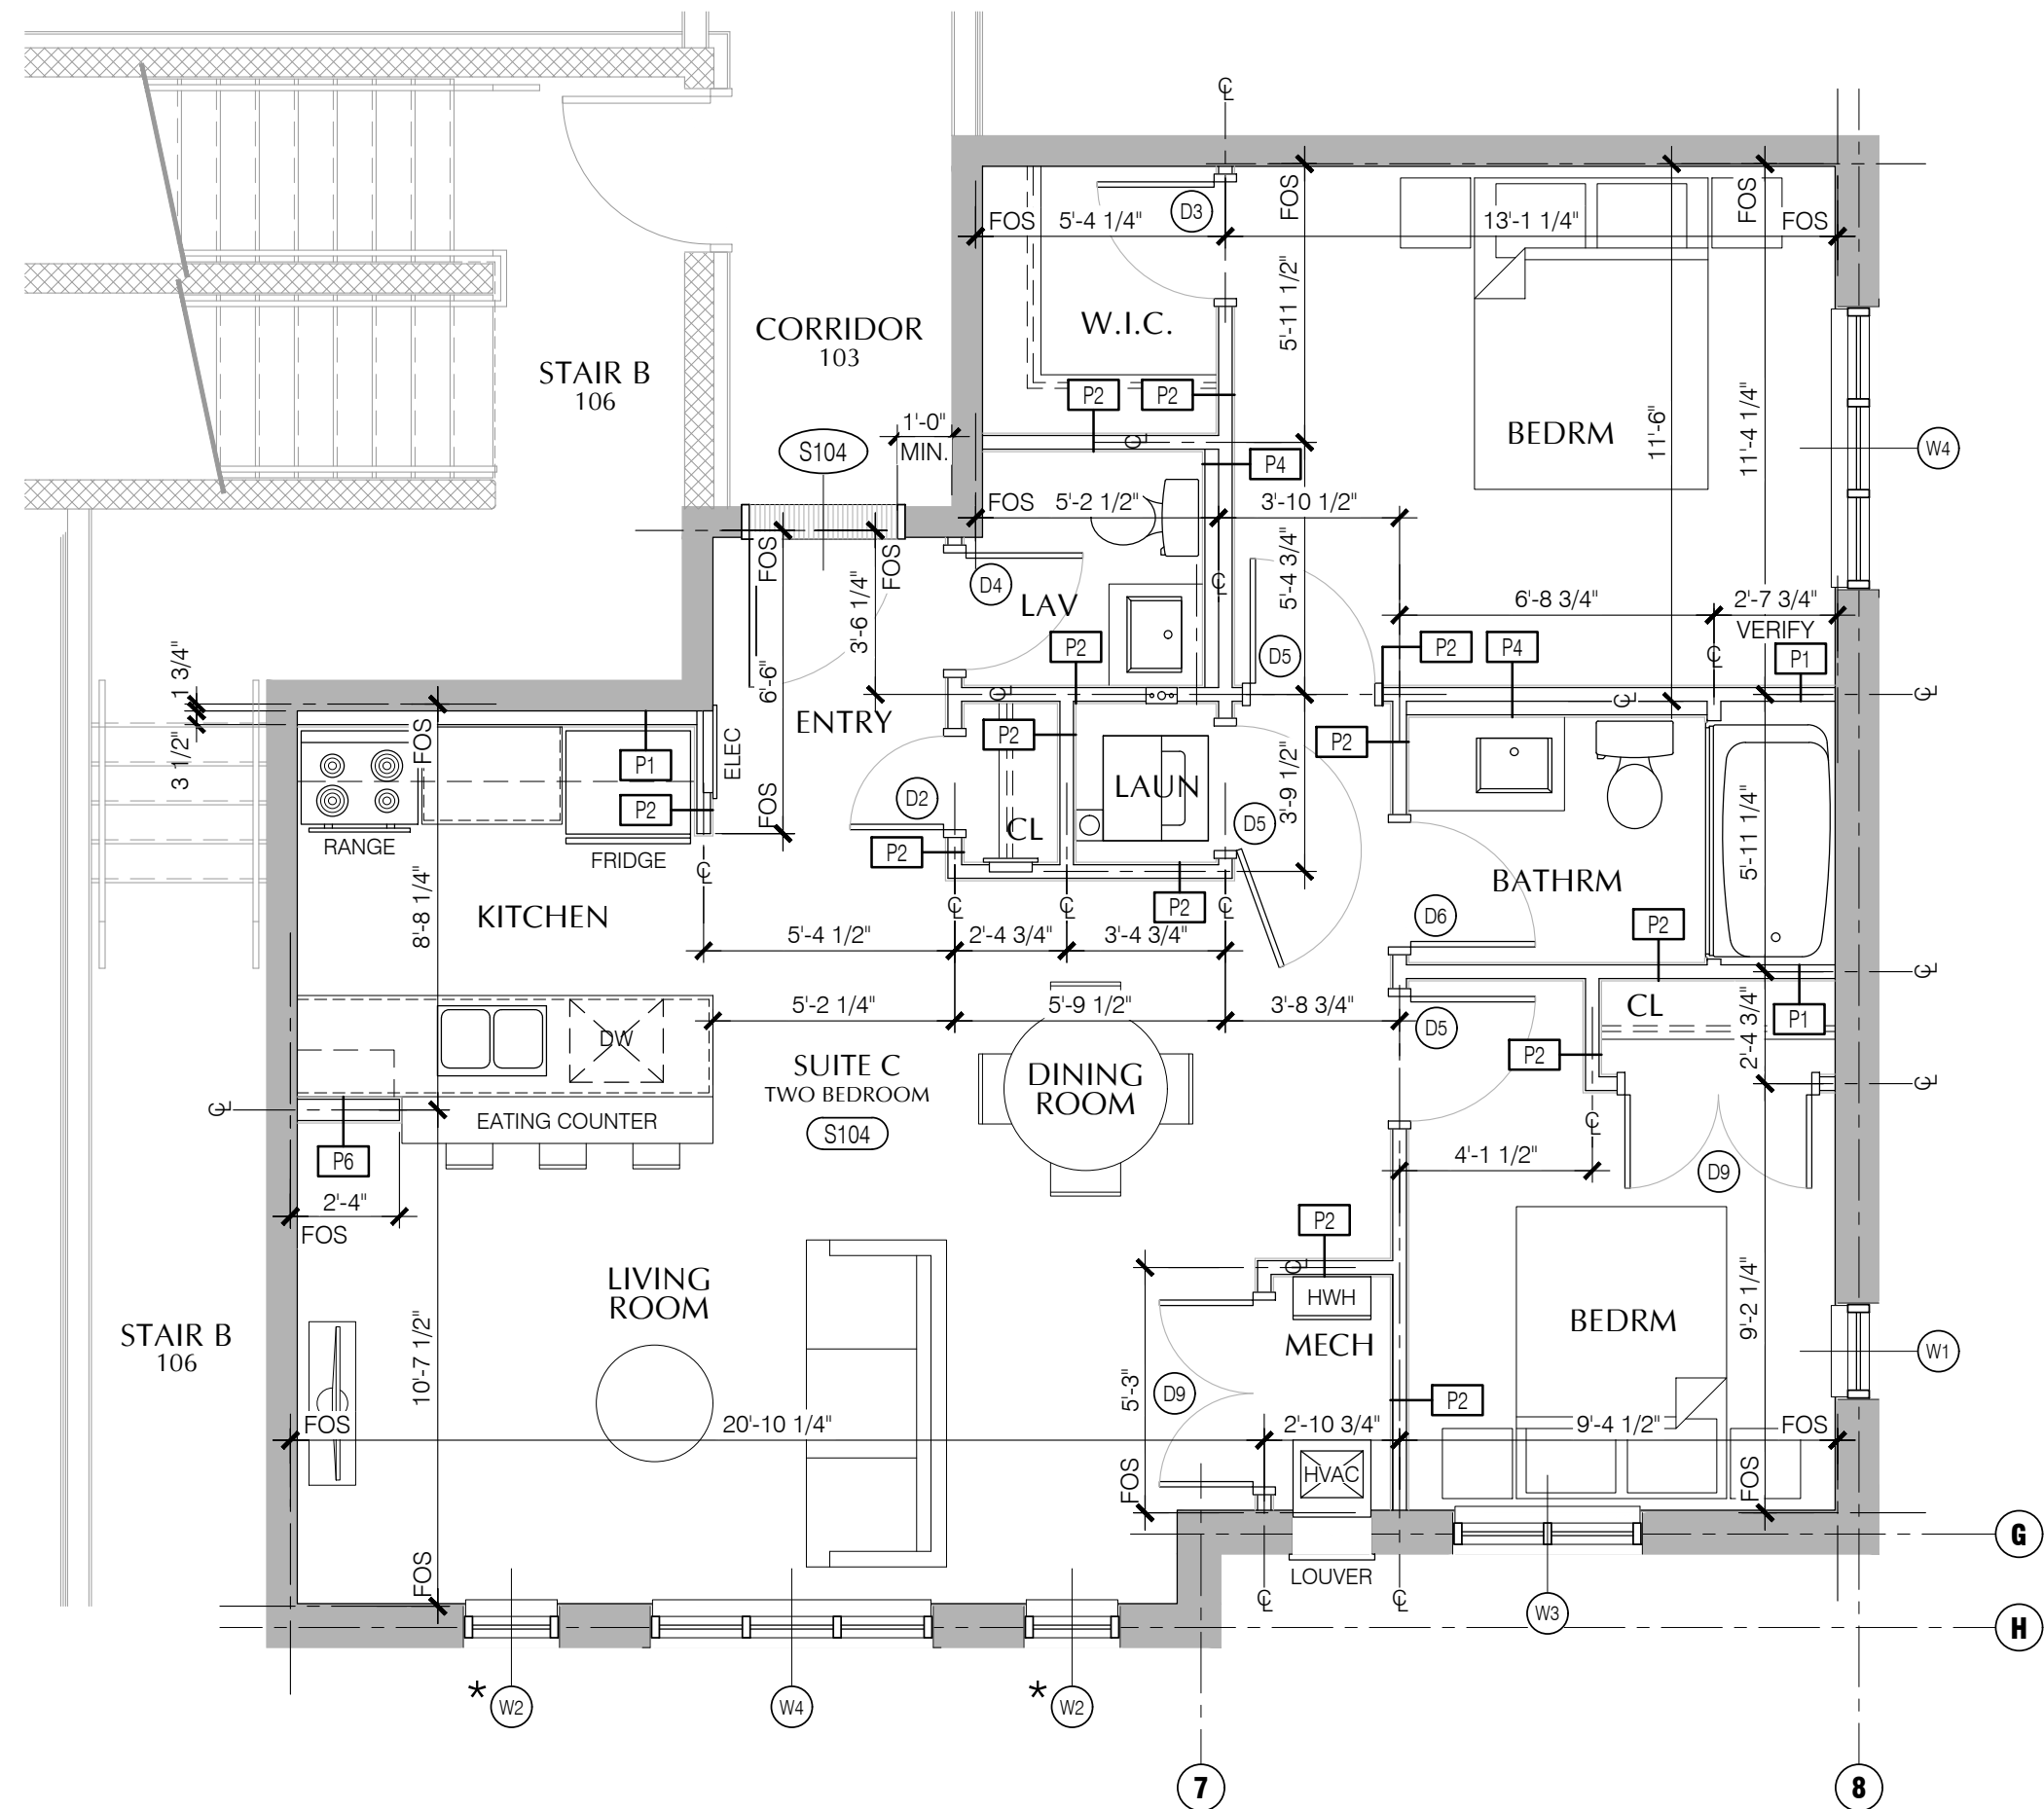


1a SUITE C (S104) - ENLARGED FLOOR PLAN
A4.2 1/4" = 1'-0"


SUITE C - AREA CALCULATIONS
GROSS FLOOR AREA (TARION STANDARDS) 932.85 ft² 86.7 m²
NET FLOOR AREA 835.30 ft² 77.6 m²
BALCONY AREA N/A ft² N/A m²

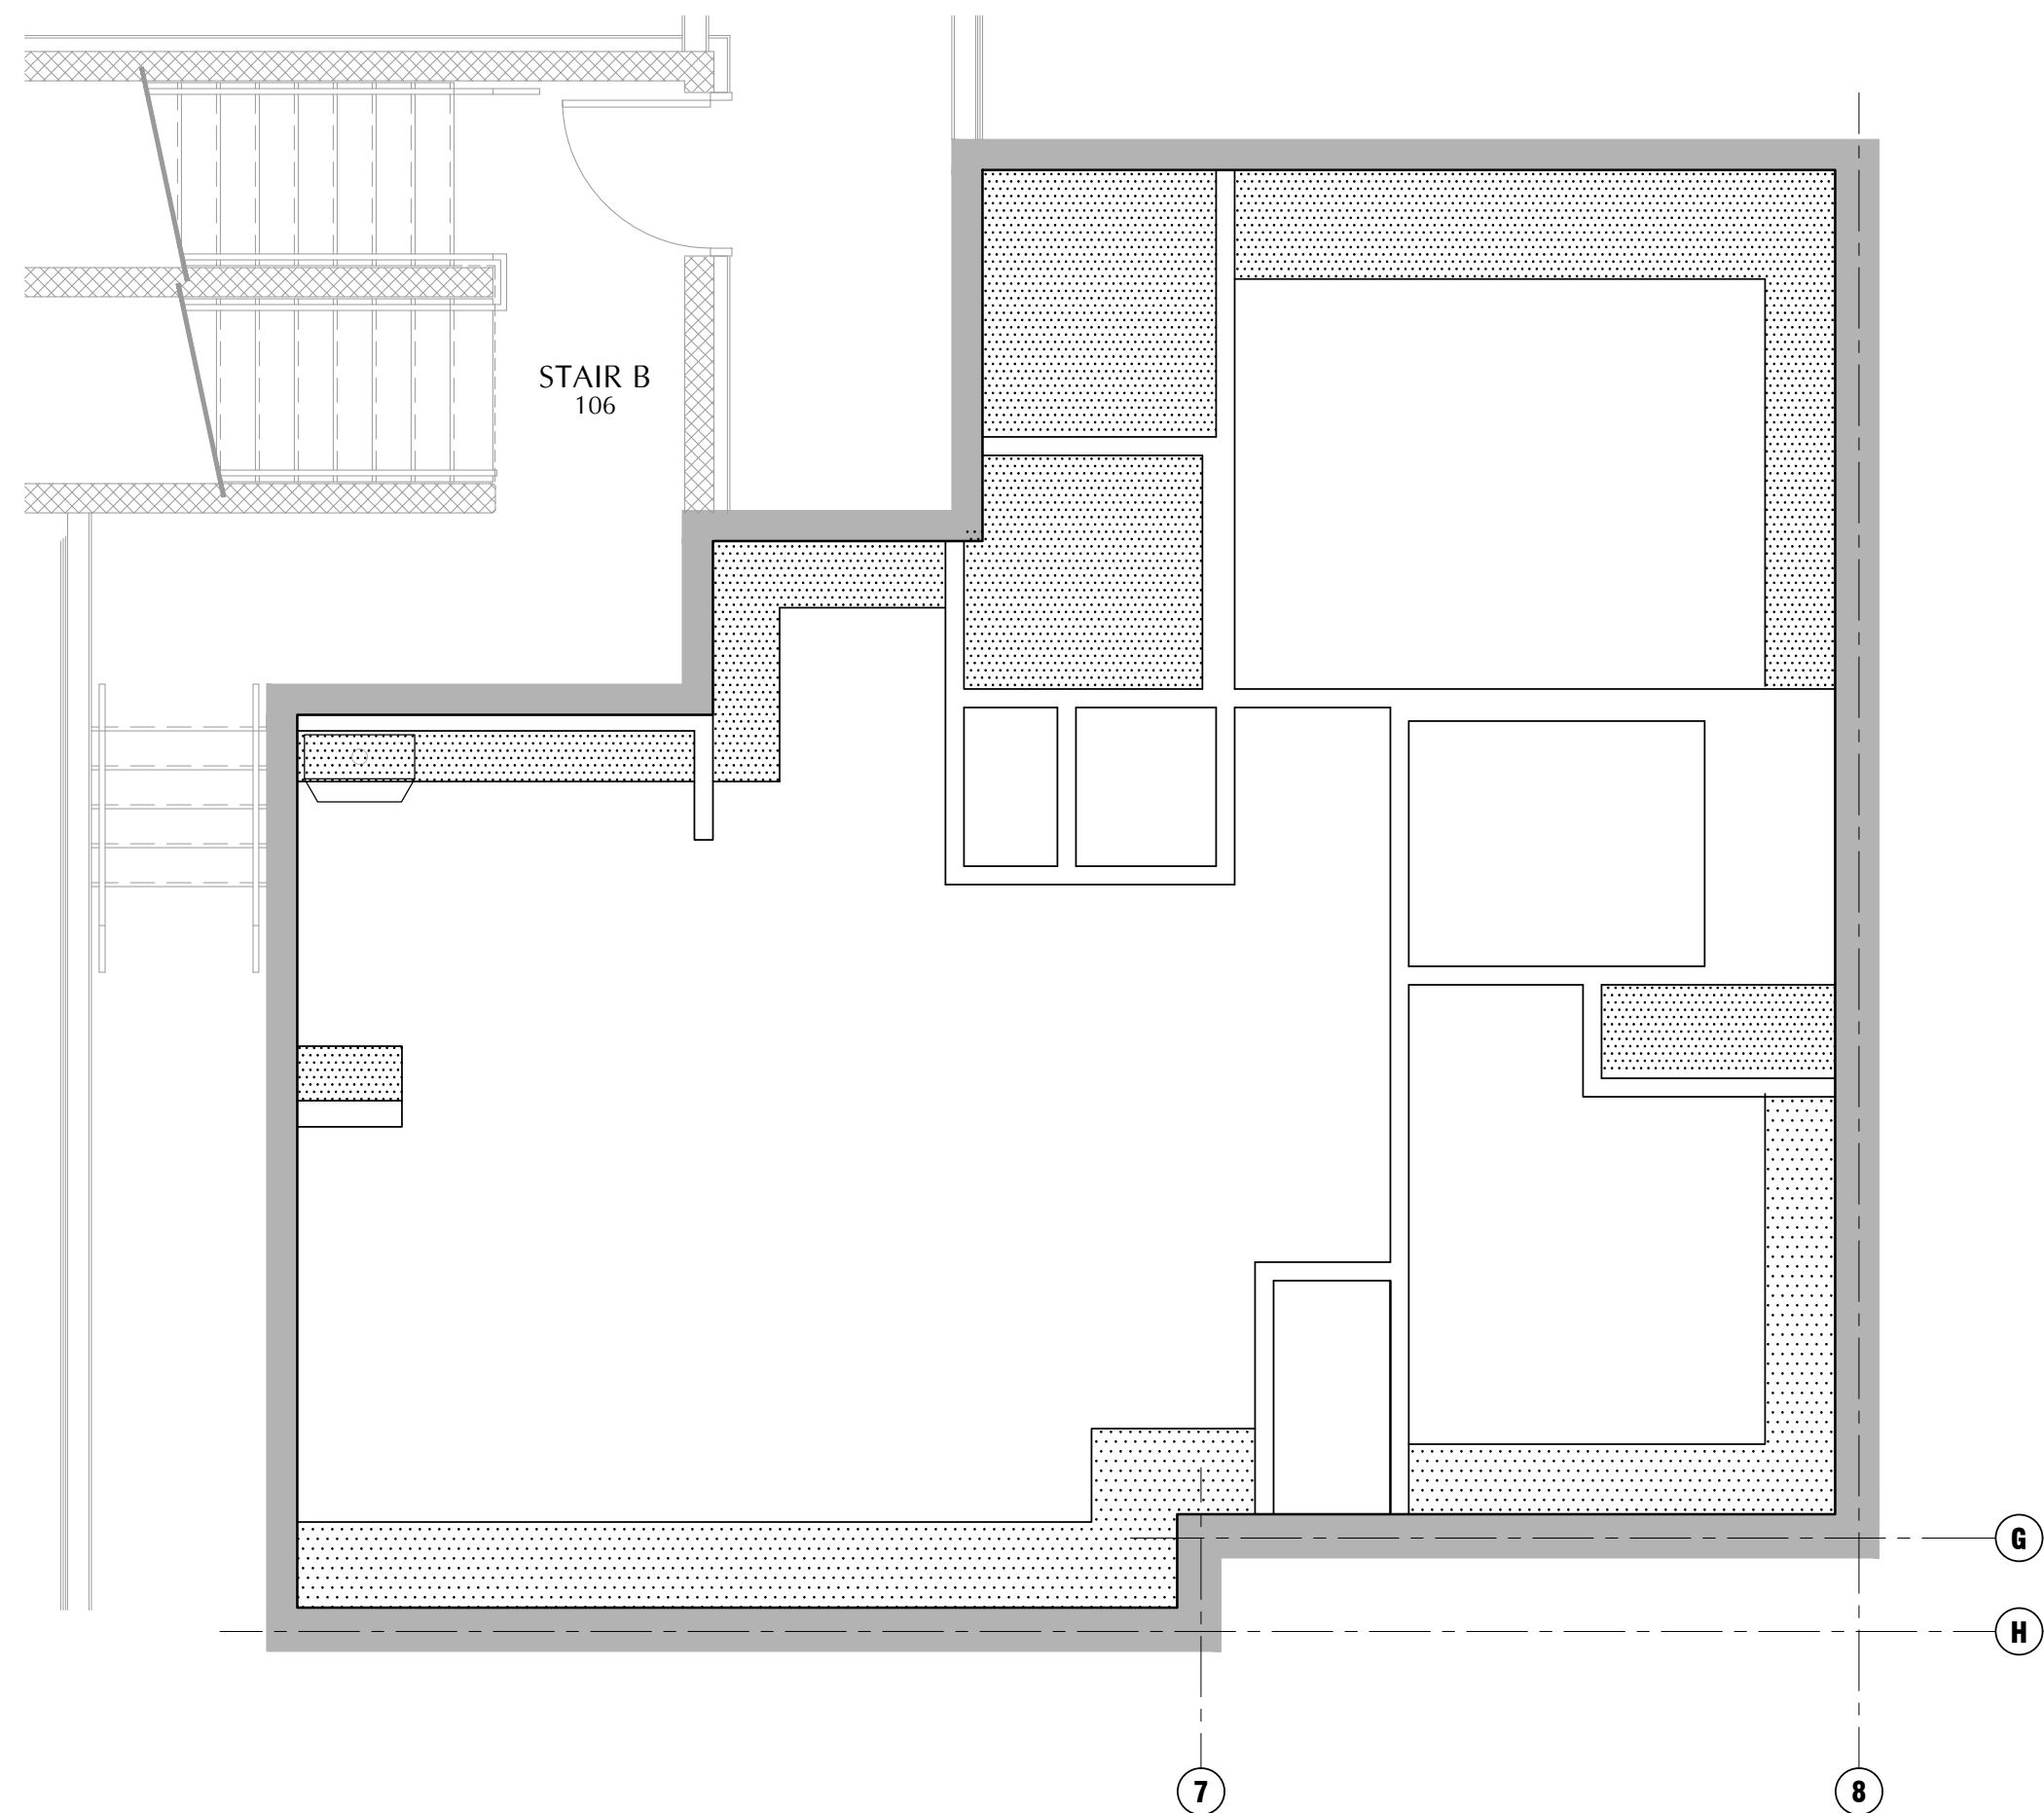

1b SUITE C (S104) - REFLECTED CEILING PLAN
A4.2 1/4" = 1'-0"

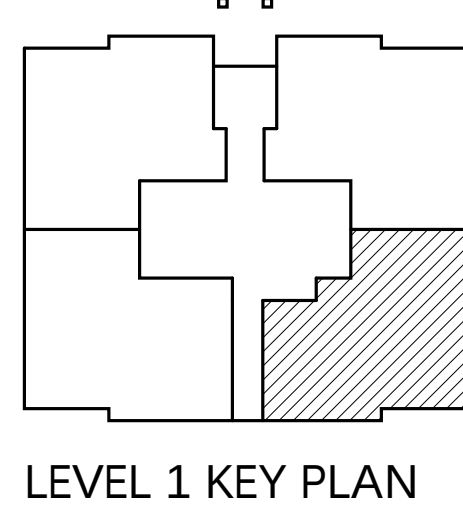


LEVEL 1 KEY PLAN

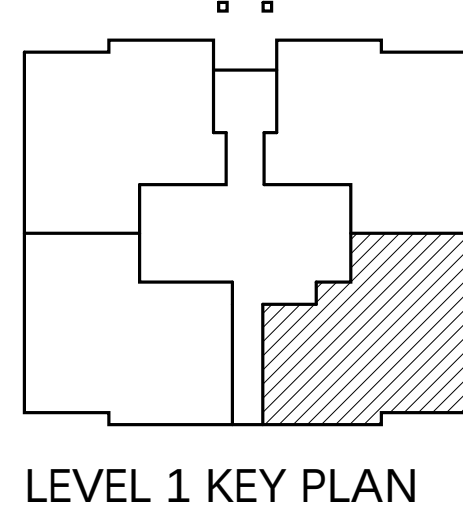

LEVEL 1 KEY PLAN


* WINDOWS EXCLUDED FROM BLOCK 19 DUE TO SPATIAL SEPARATION REQUIREMENTS (REFER TO ELEVATION)

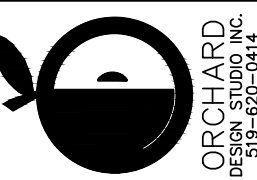

gb architect inc.
430 ONTARIO STREET
STRATFORD, ONTARIO, N5A 3J2
PHONE (519) 272-0073 FAX (519) 272-4433

*Guy R. Bellemur, B. Arch, OAA, MRAC
Principal Architect of GB ARCHITECT INC. is the
designer for this project with respect to all architectural
work identified on this drawing sheet. The Ontario
Architectural Association (OAA) has reviewed the
work of Guy R. Bellemur and has issued a
Certificate of Registration (C.R. Number 487)
as per requirements of the Ministry of Municipal
Affairs & Housing Bill 124.
The Architect above has exercised responsible control with
respect to design activities. The architect's seal number is their
B.C.D.S. number.

ONTARIO ASSOCIATION
OF ARCHITECTS
GUY ROBERT BELLEMEUR
LICENCE
4217
DECEMBER 13, 2021

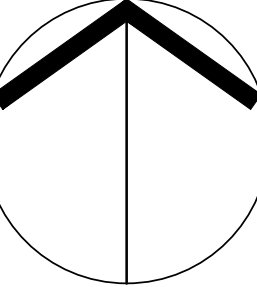


STATUS	DESIGN DEVELOPMENT	21-12-13	6	ISSUED FOR PERMIT
FOLDER	MARTIN-MILVERTON	21-12-08	5	ISSUED TO CONSULTANTS
FILE	14705_A4-SUITE_BUK	21-11-24	4	ISSUED TO CONSULTANTS
SCALE	1/4" = 1'-0"	21-11-09	3	REVISED FOR SPA (1st SUBMISSION)
DATE	APRIL 2021	21-09-16	2	ISSUED FOR SPA (1st SUBMISSION)
REVISED		21-08-24	1	ISSUED FOR OFFICIAL PLAN AMENDMENT
JOB No.	14705	DATE	No.	REVISION

MILVERTON APARTMENT BUILDING
MILVERTON ONTARIO
BLOCK 17
ENLARGED SUITE PLANS


SHEET No.

A4.2

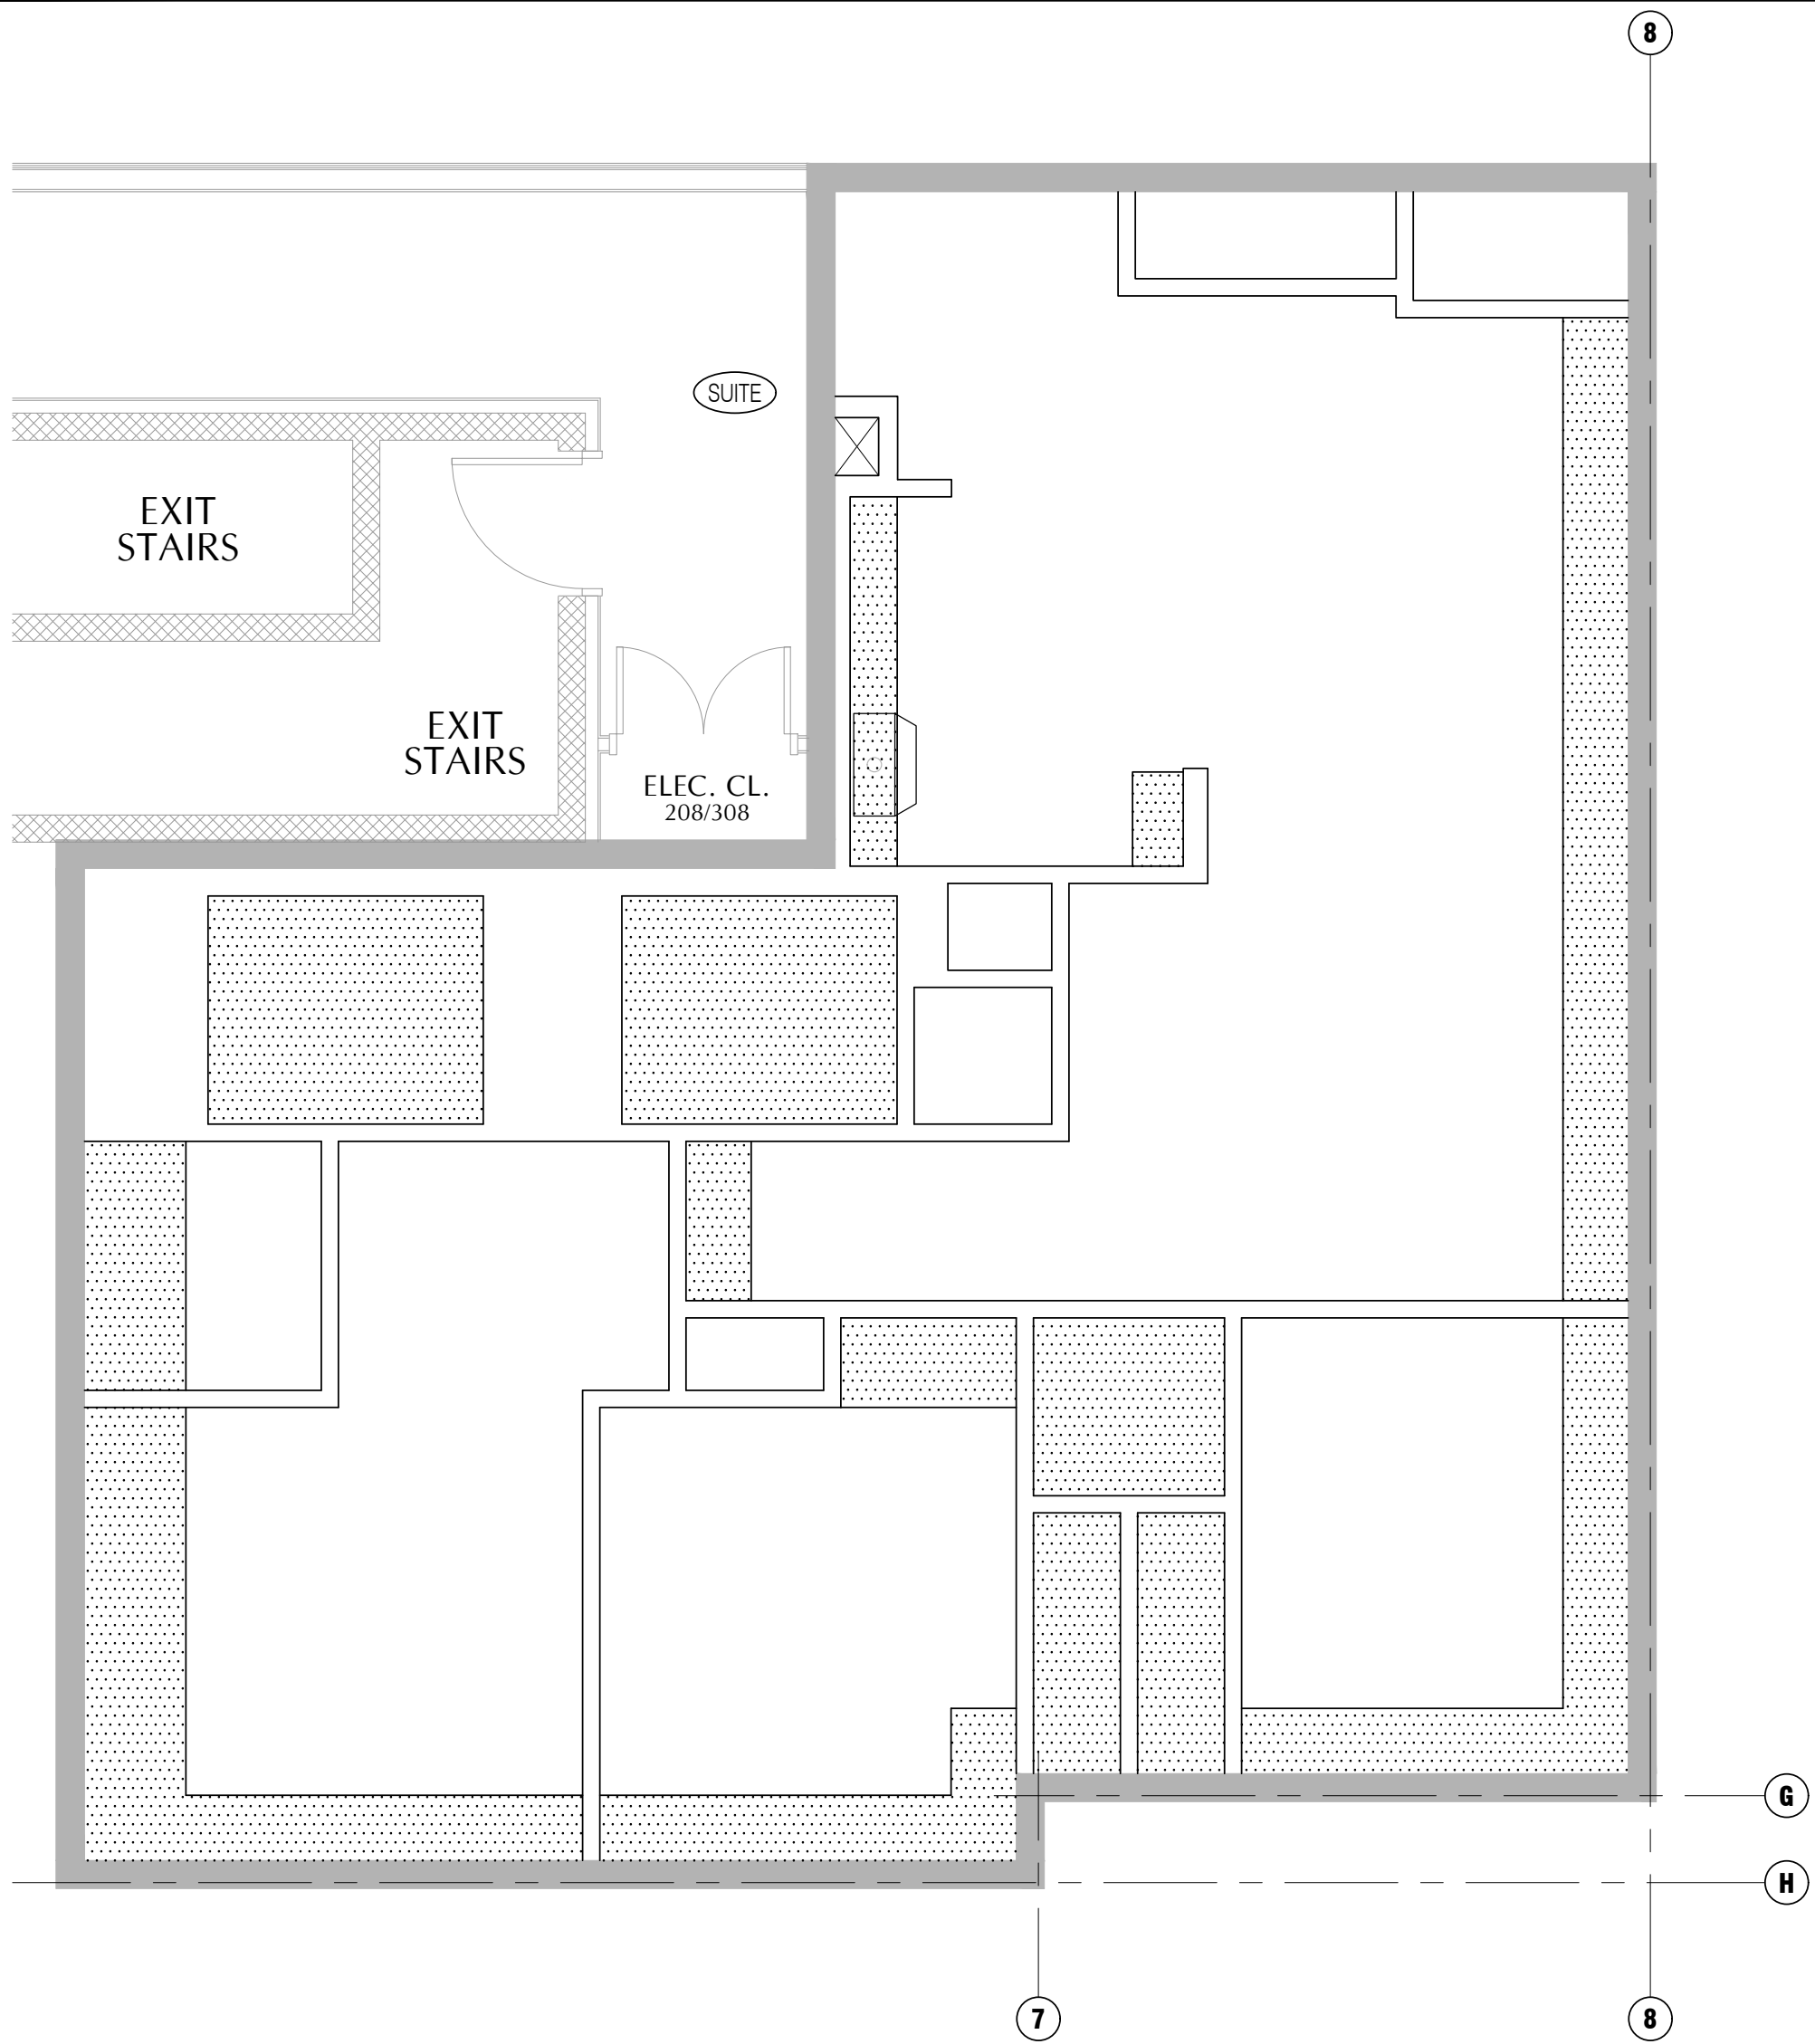


1b SUITE E (S2/304) - REFLECTED CEILING PLAN
A4.3 1/4" = 1'-0"

THIS AREA INTENTIONALLY LEFT BLANK

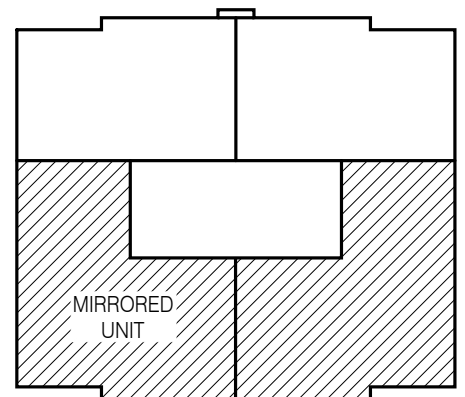


LEVEL 2 & 3 KEY PLAN

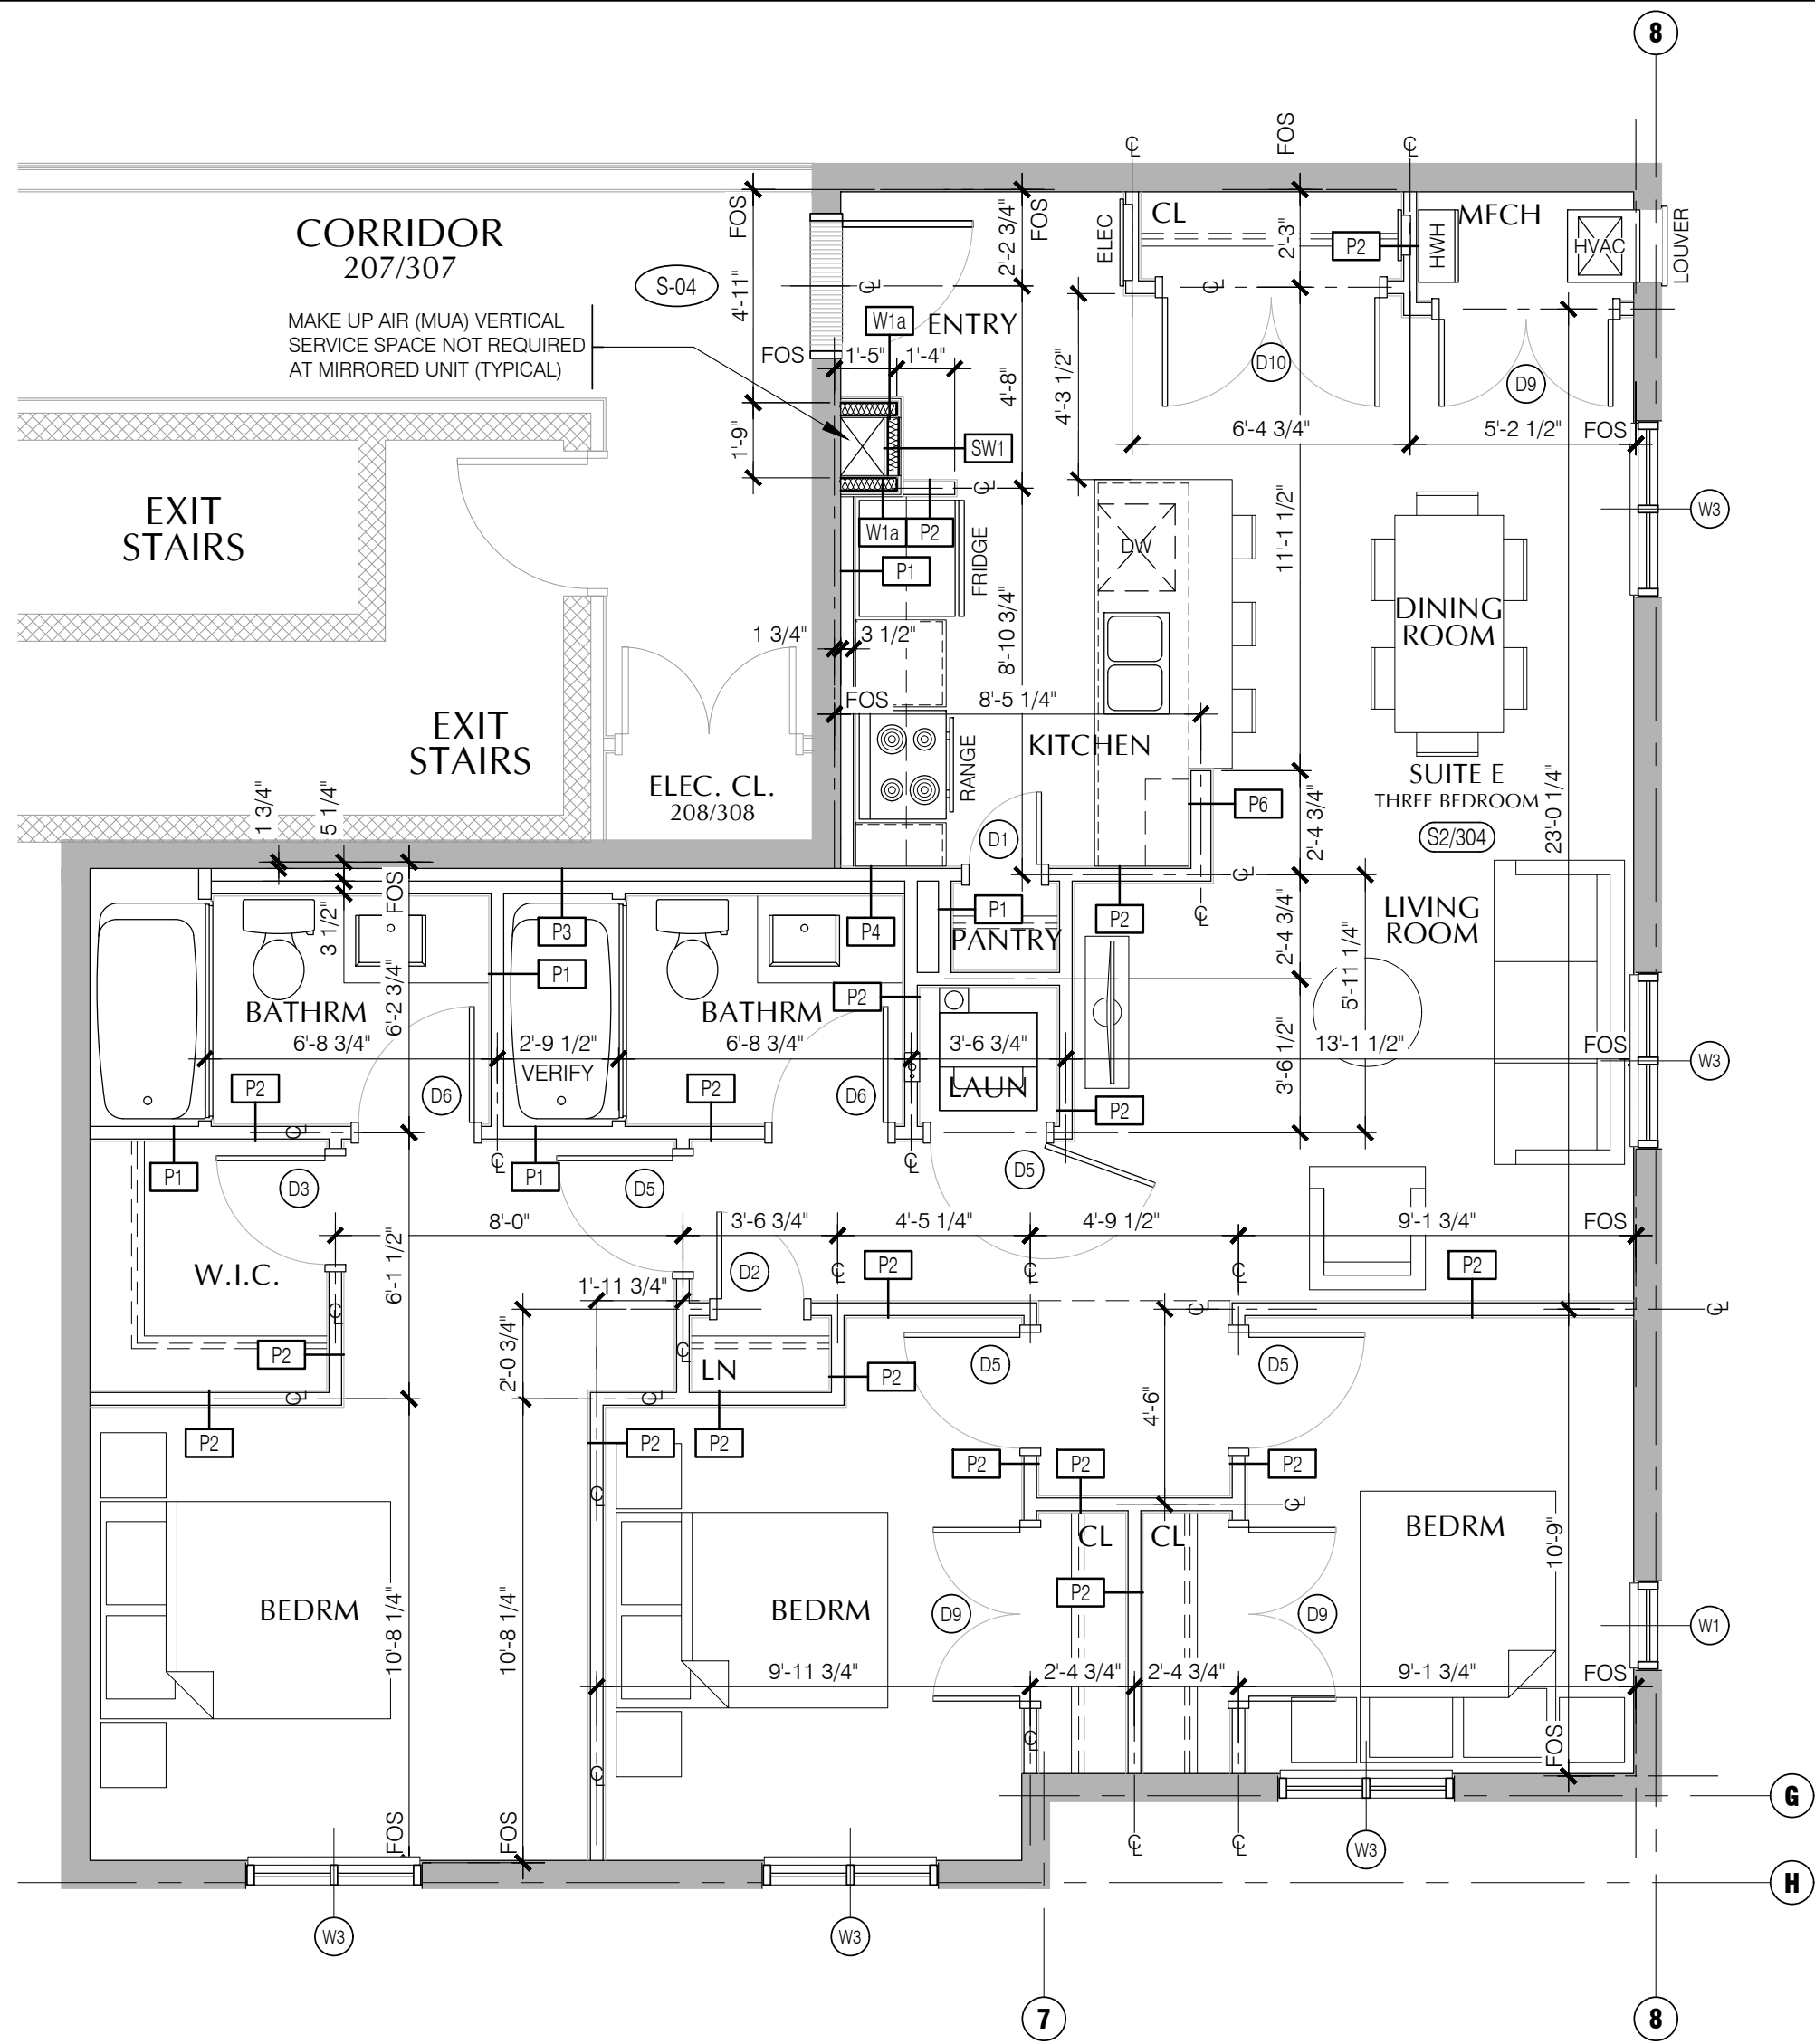


1a SUITE E (S2/304) - ENLARGED FLOOR PLAN
A4.3 1/4" = 1'-0"

THIS AREA INTENTIONALLY LEFT BLANK

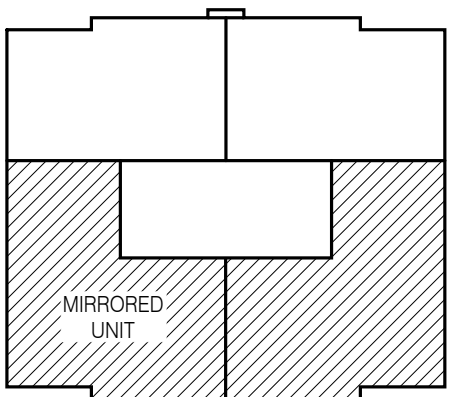


LEVEL 2 & 3 KEY PLAN

SUITE E - AREA CALCULATIONS
GROSS FLOOR AREA (TARION STANDARDS) 1150.25 ft² 106.9 m²
NET FLOOR AREA 1067.20 ft² 99.1 m²
BALCONY AREA N/A ft² N/A m²

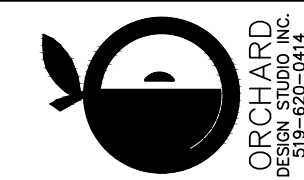

gb architect inc.
430 ONTARIO STREET
STRATFORD, ONTARIO N5A 3Z2
PHONE (519) 272 0073 FAX (519) 272 4433


*Guy R. Bellemeur, B. Arch, OAA, MRAC
Principal Architect of GB ARCHITECT INC. is the
designer for this project with respect to all architectural
work identified on this drawing sheet. The Ontario
Architectural Association (OAA) has reviewed the
work of Guy R. Bellemeur and GB ARCHITECT INC.
as per requirements of the Ministry of Municipal
Affairs & Housing Bill 24.
The Architect above has exercised responsible control with
respect to design activities. The Architect's seal number is their
B.C.D.S. number.

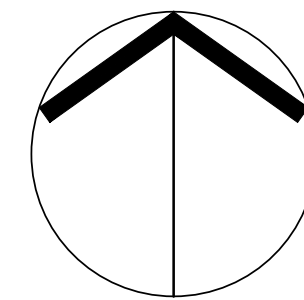


STATUS	DESIGN DEVELOPMENT	21-12-13	6	ISSUED FOR PERMIT
FOLDER	MARTIN-MILVERTON	21-12-08	5	ISSUED TO CONSULTANTS
FILE	14705_A4-SUITE_BULK	17.0m	4	ISSUED TO CONSULTANTS
SCALE	1/4" = 1'-0"	21-11-24	4	REVISED FOR SPA (1st SUBMISSION)
DRAWN BY	JED	21-11-09	3	ISSUED FOR SPA (1st SUBMISSION)
DATE	APRIL 2021	21-09-16	2	ISSUED FOR SPA (1st SUBMISSION)
REVISION		21-08-24	1	ISSUED FOR OFFICIAL PLAN AMENDMENT
JOB No.	14705	DATE	No.	REVISION

MILVERTON
APARTMENT BUILDING
MILVERTON **ONTARIO**
BLOCK 17
ENLARGED SUITE PLANS


A4.3

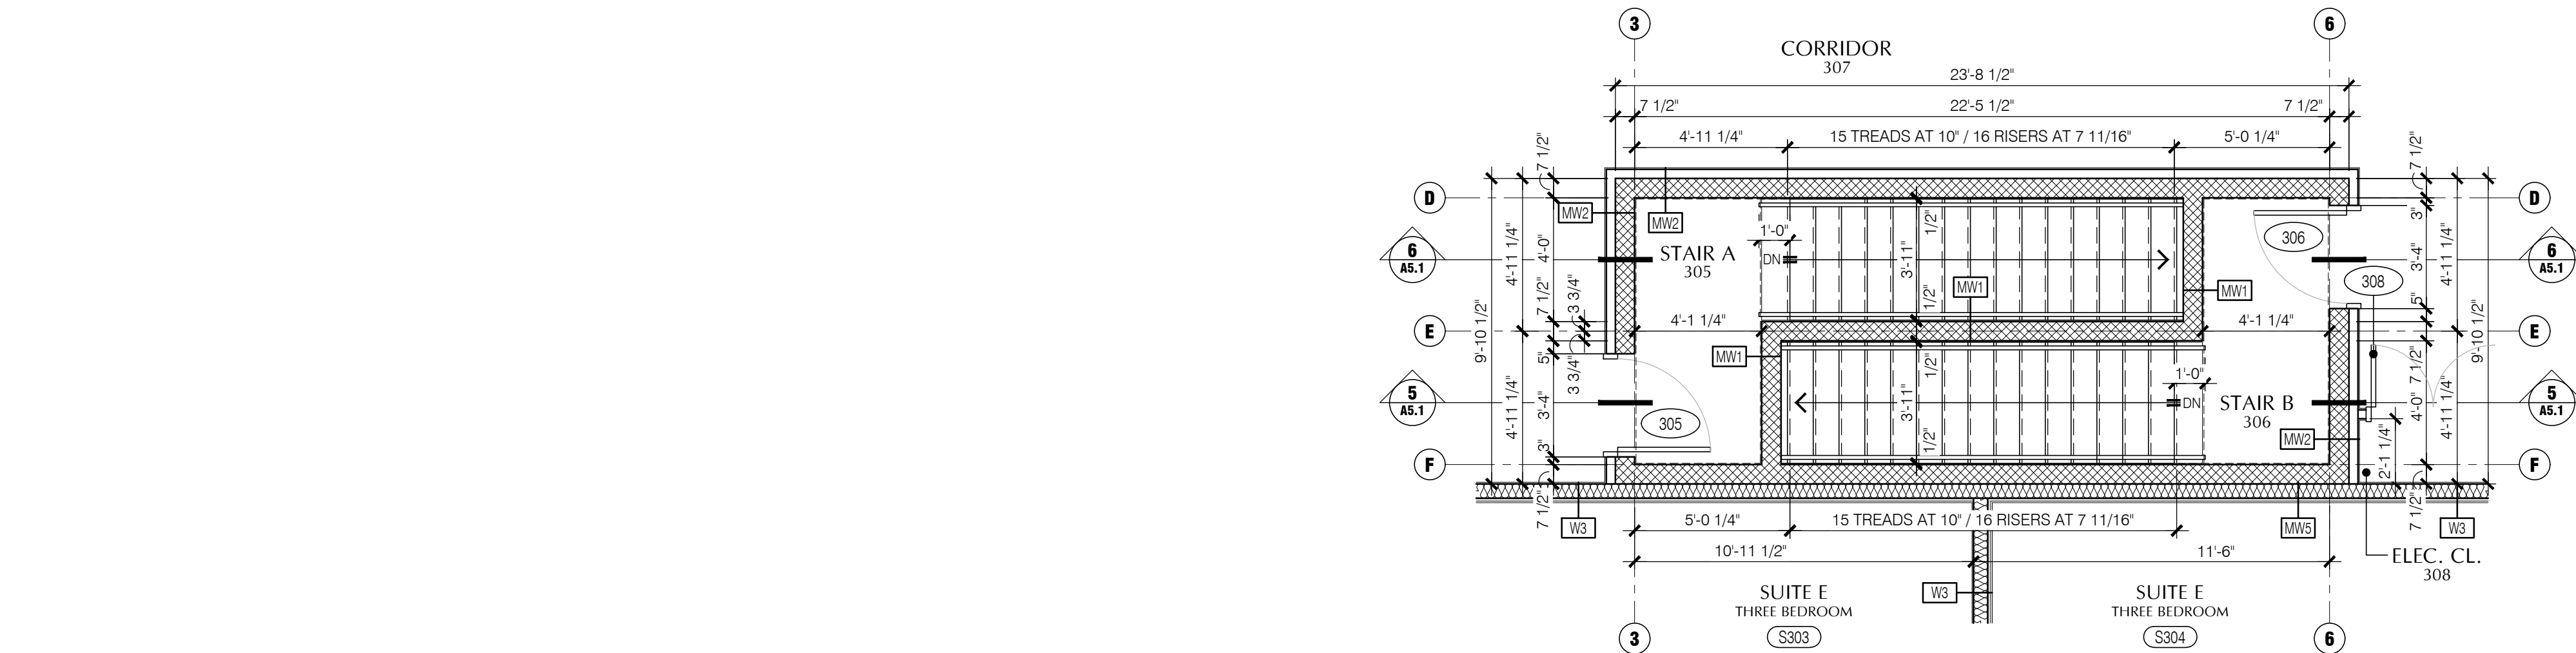

4 THIRD FLOOR STAIRS - ENLARGED PLAN
A5.1 1/4" = 1'-0"

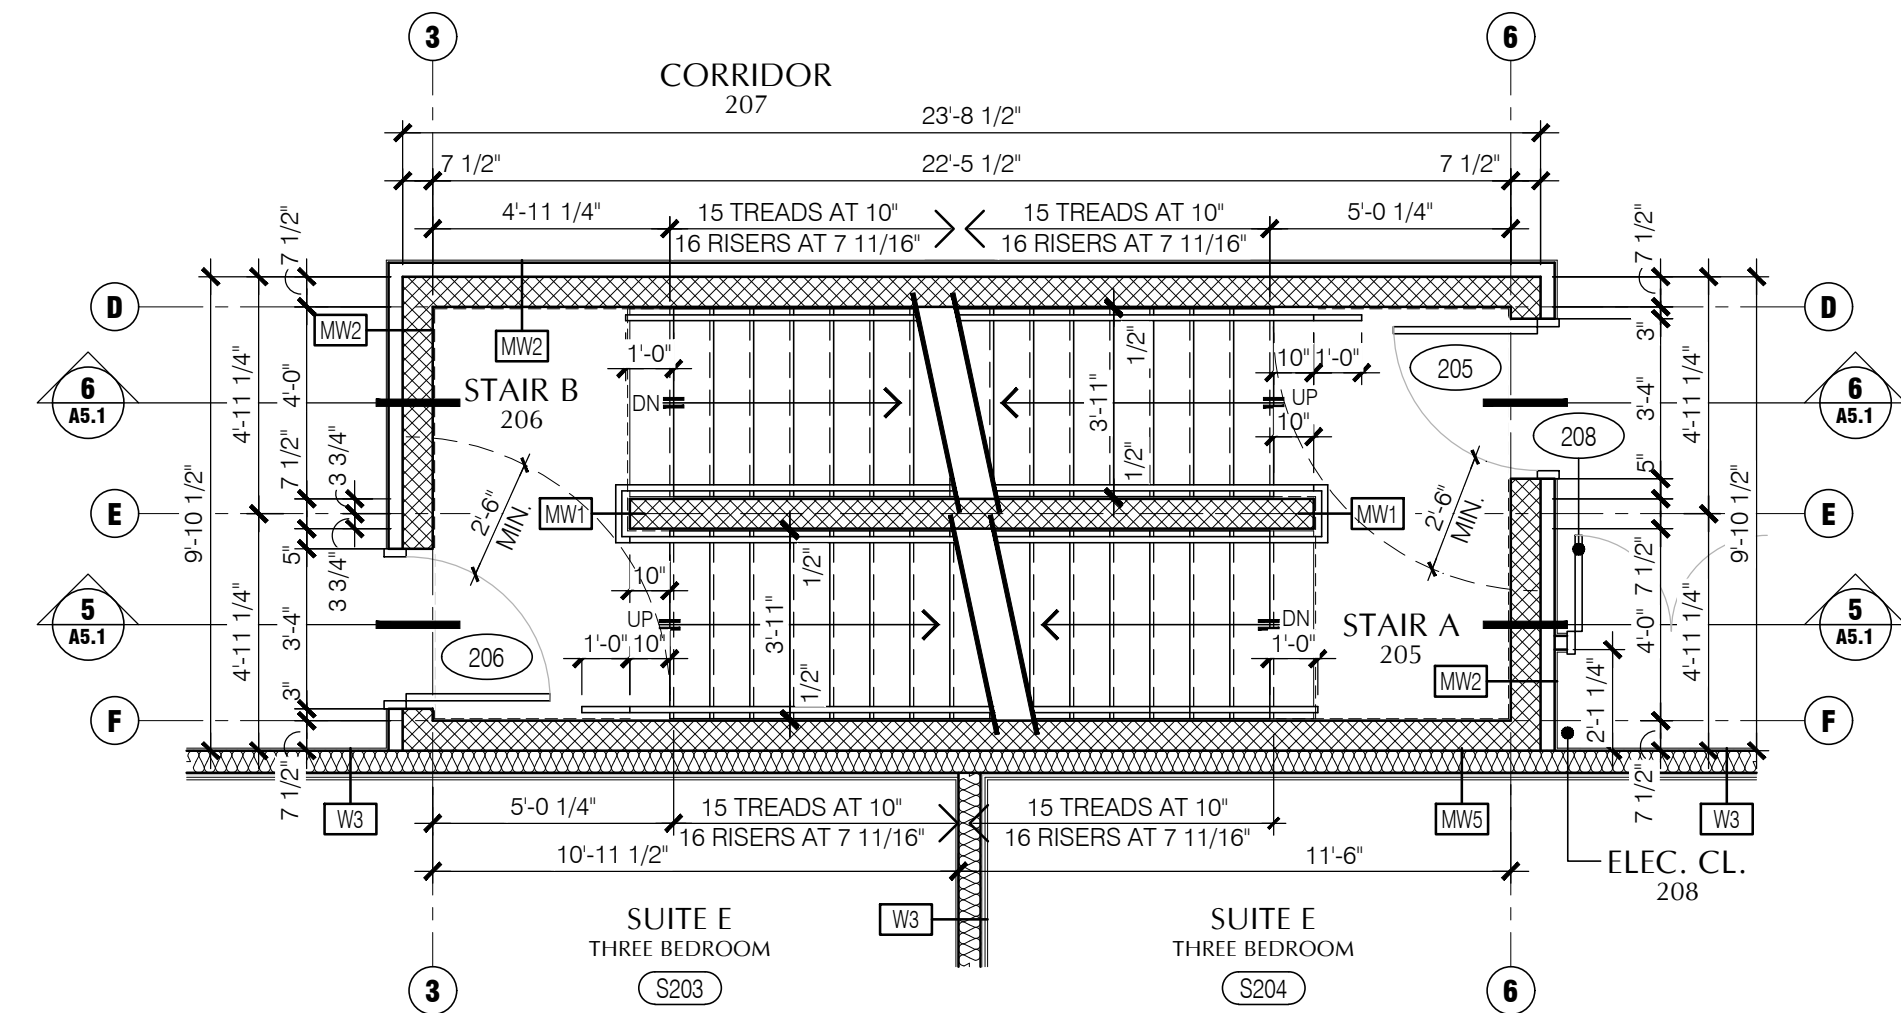


3 SECOND FLOOR STAIRS - ENLARGED PLAN
A5.1 1/4" = 1'-0"

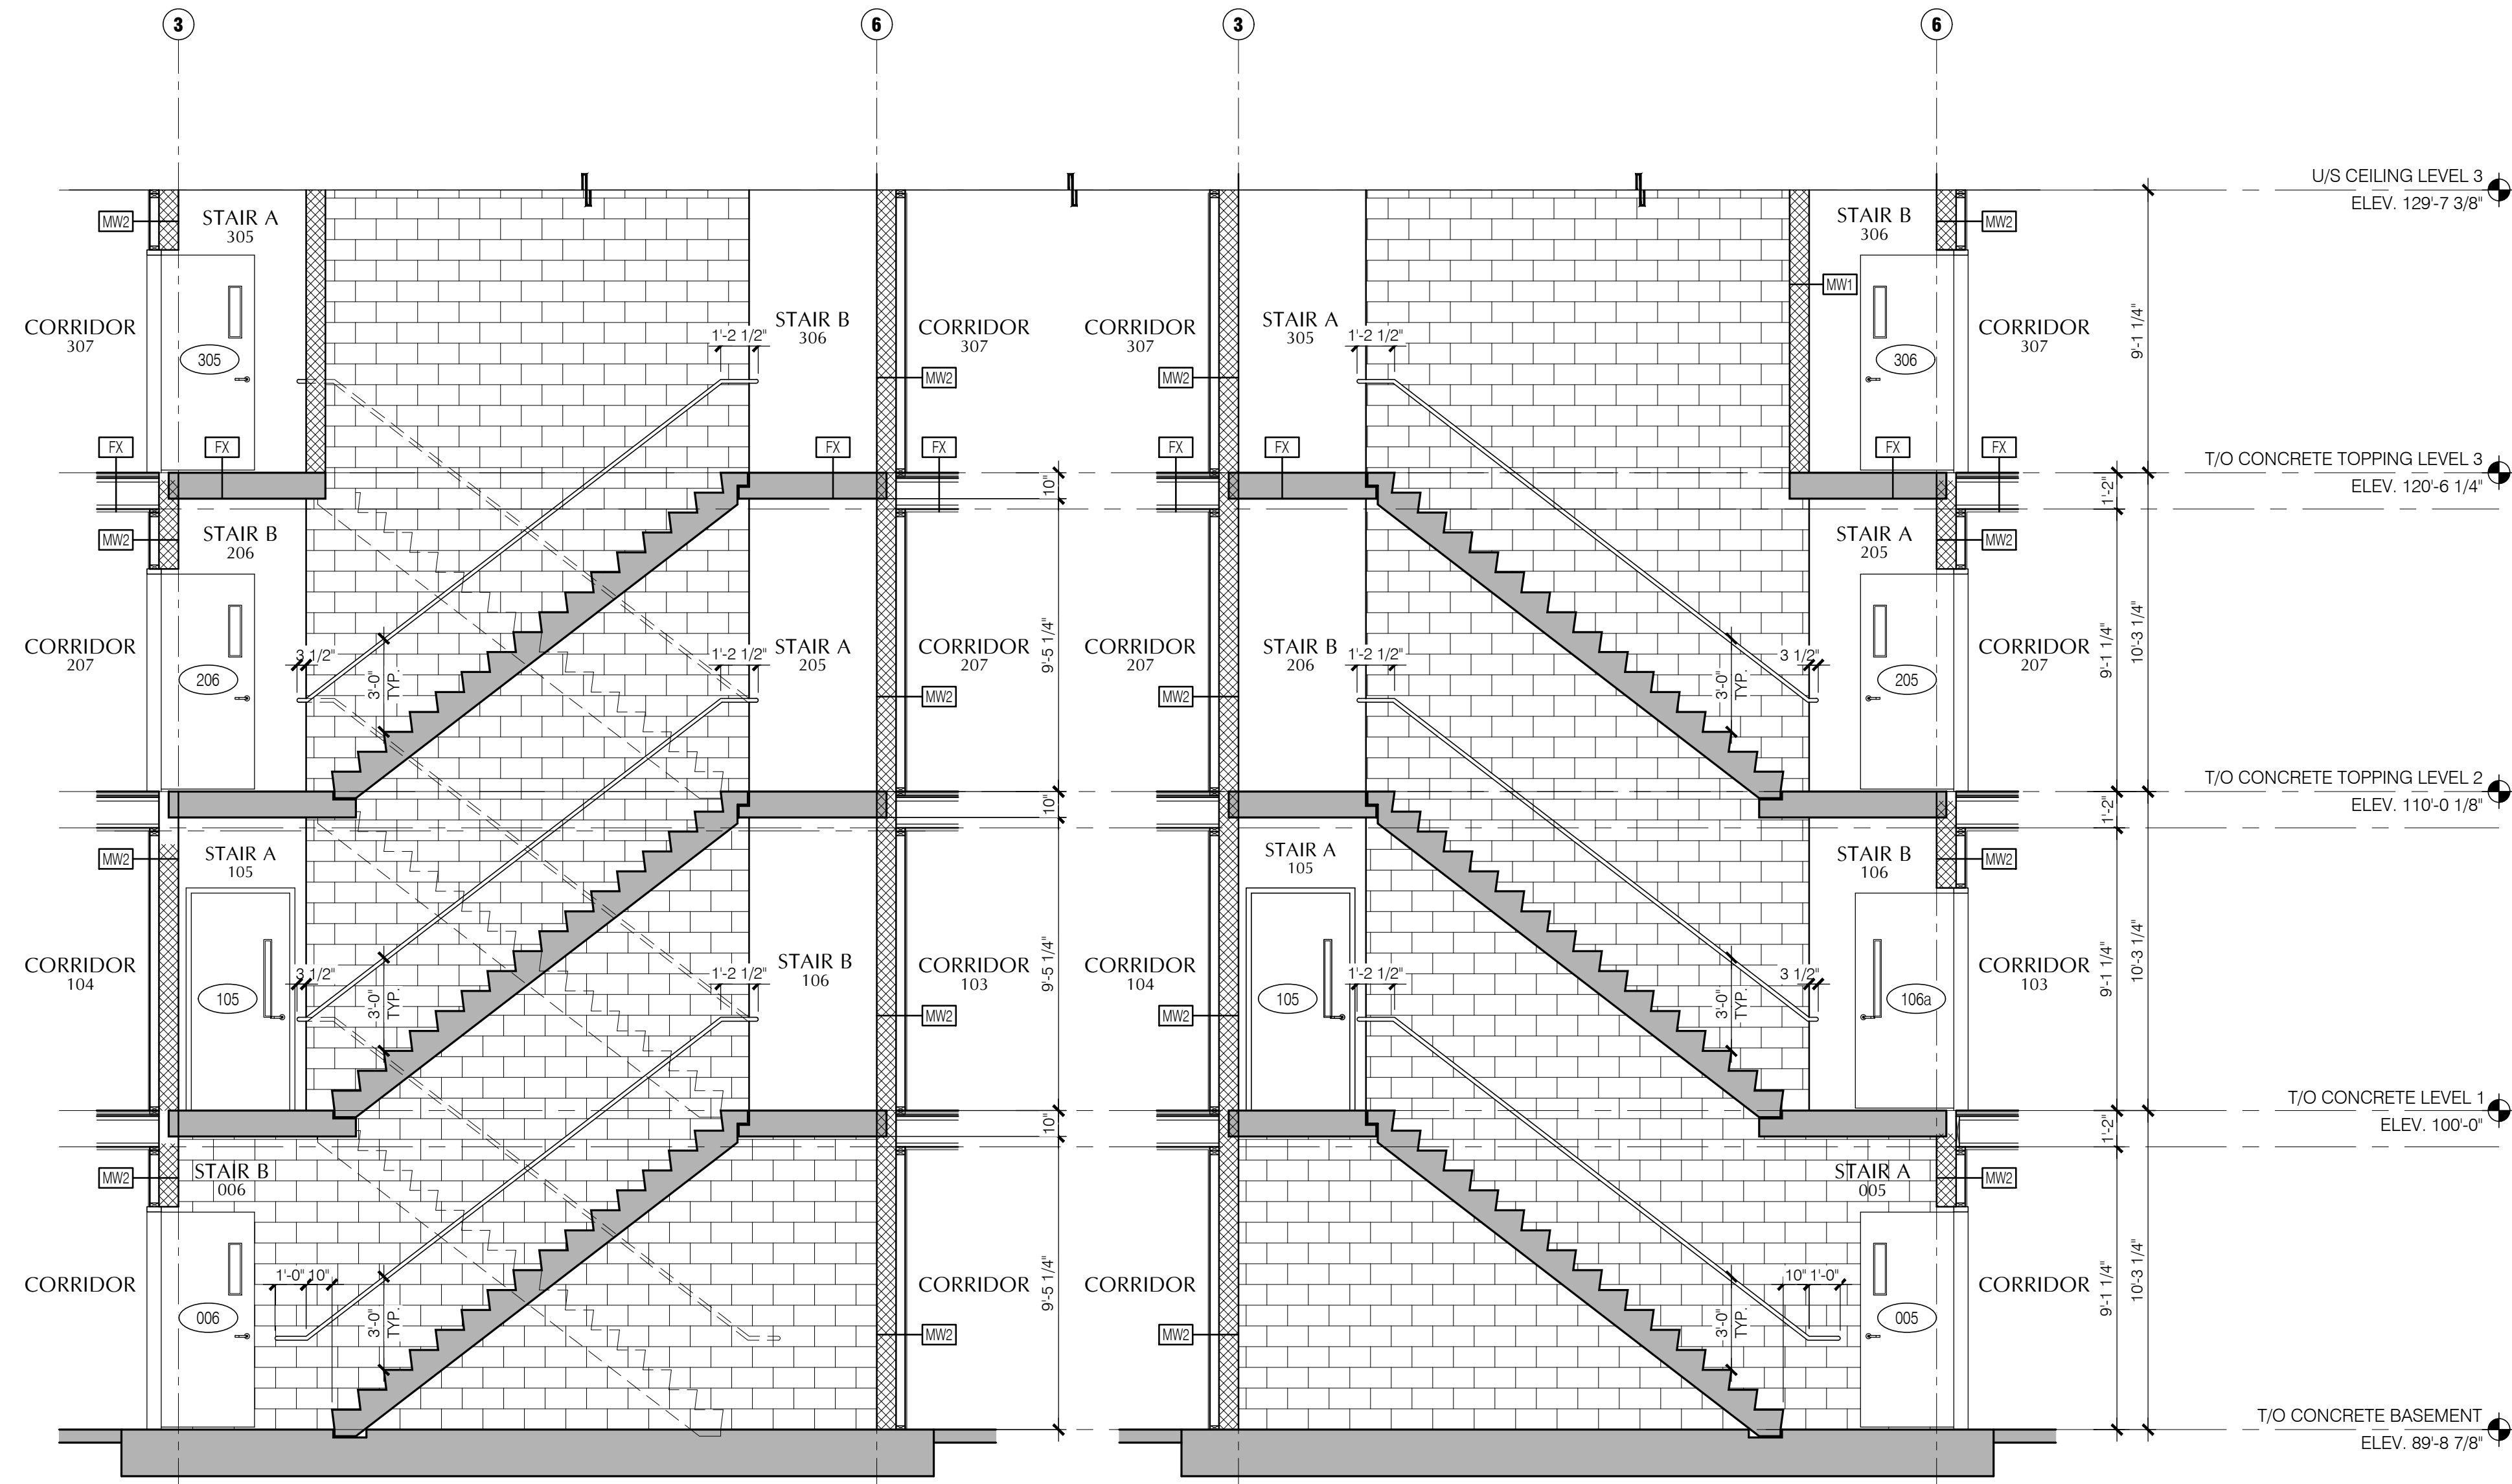


5 STAIR SECTION
A5.1 1/4" = 1'-0"


6 STAIR SECTION
A5.1 1/4" = 1'-0"

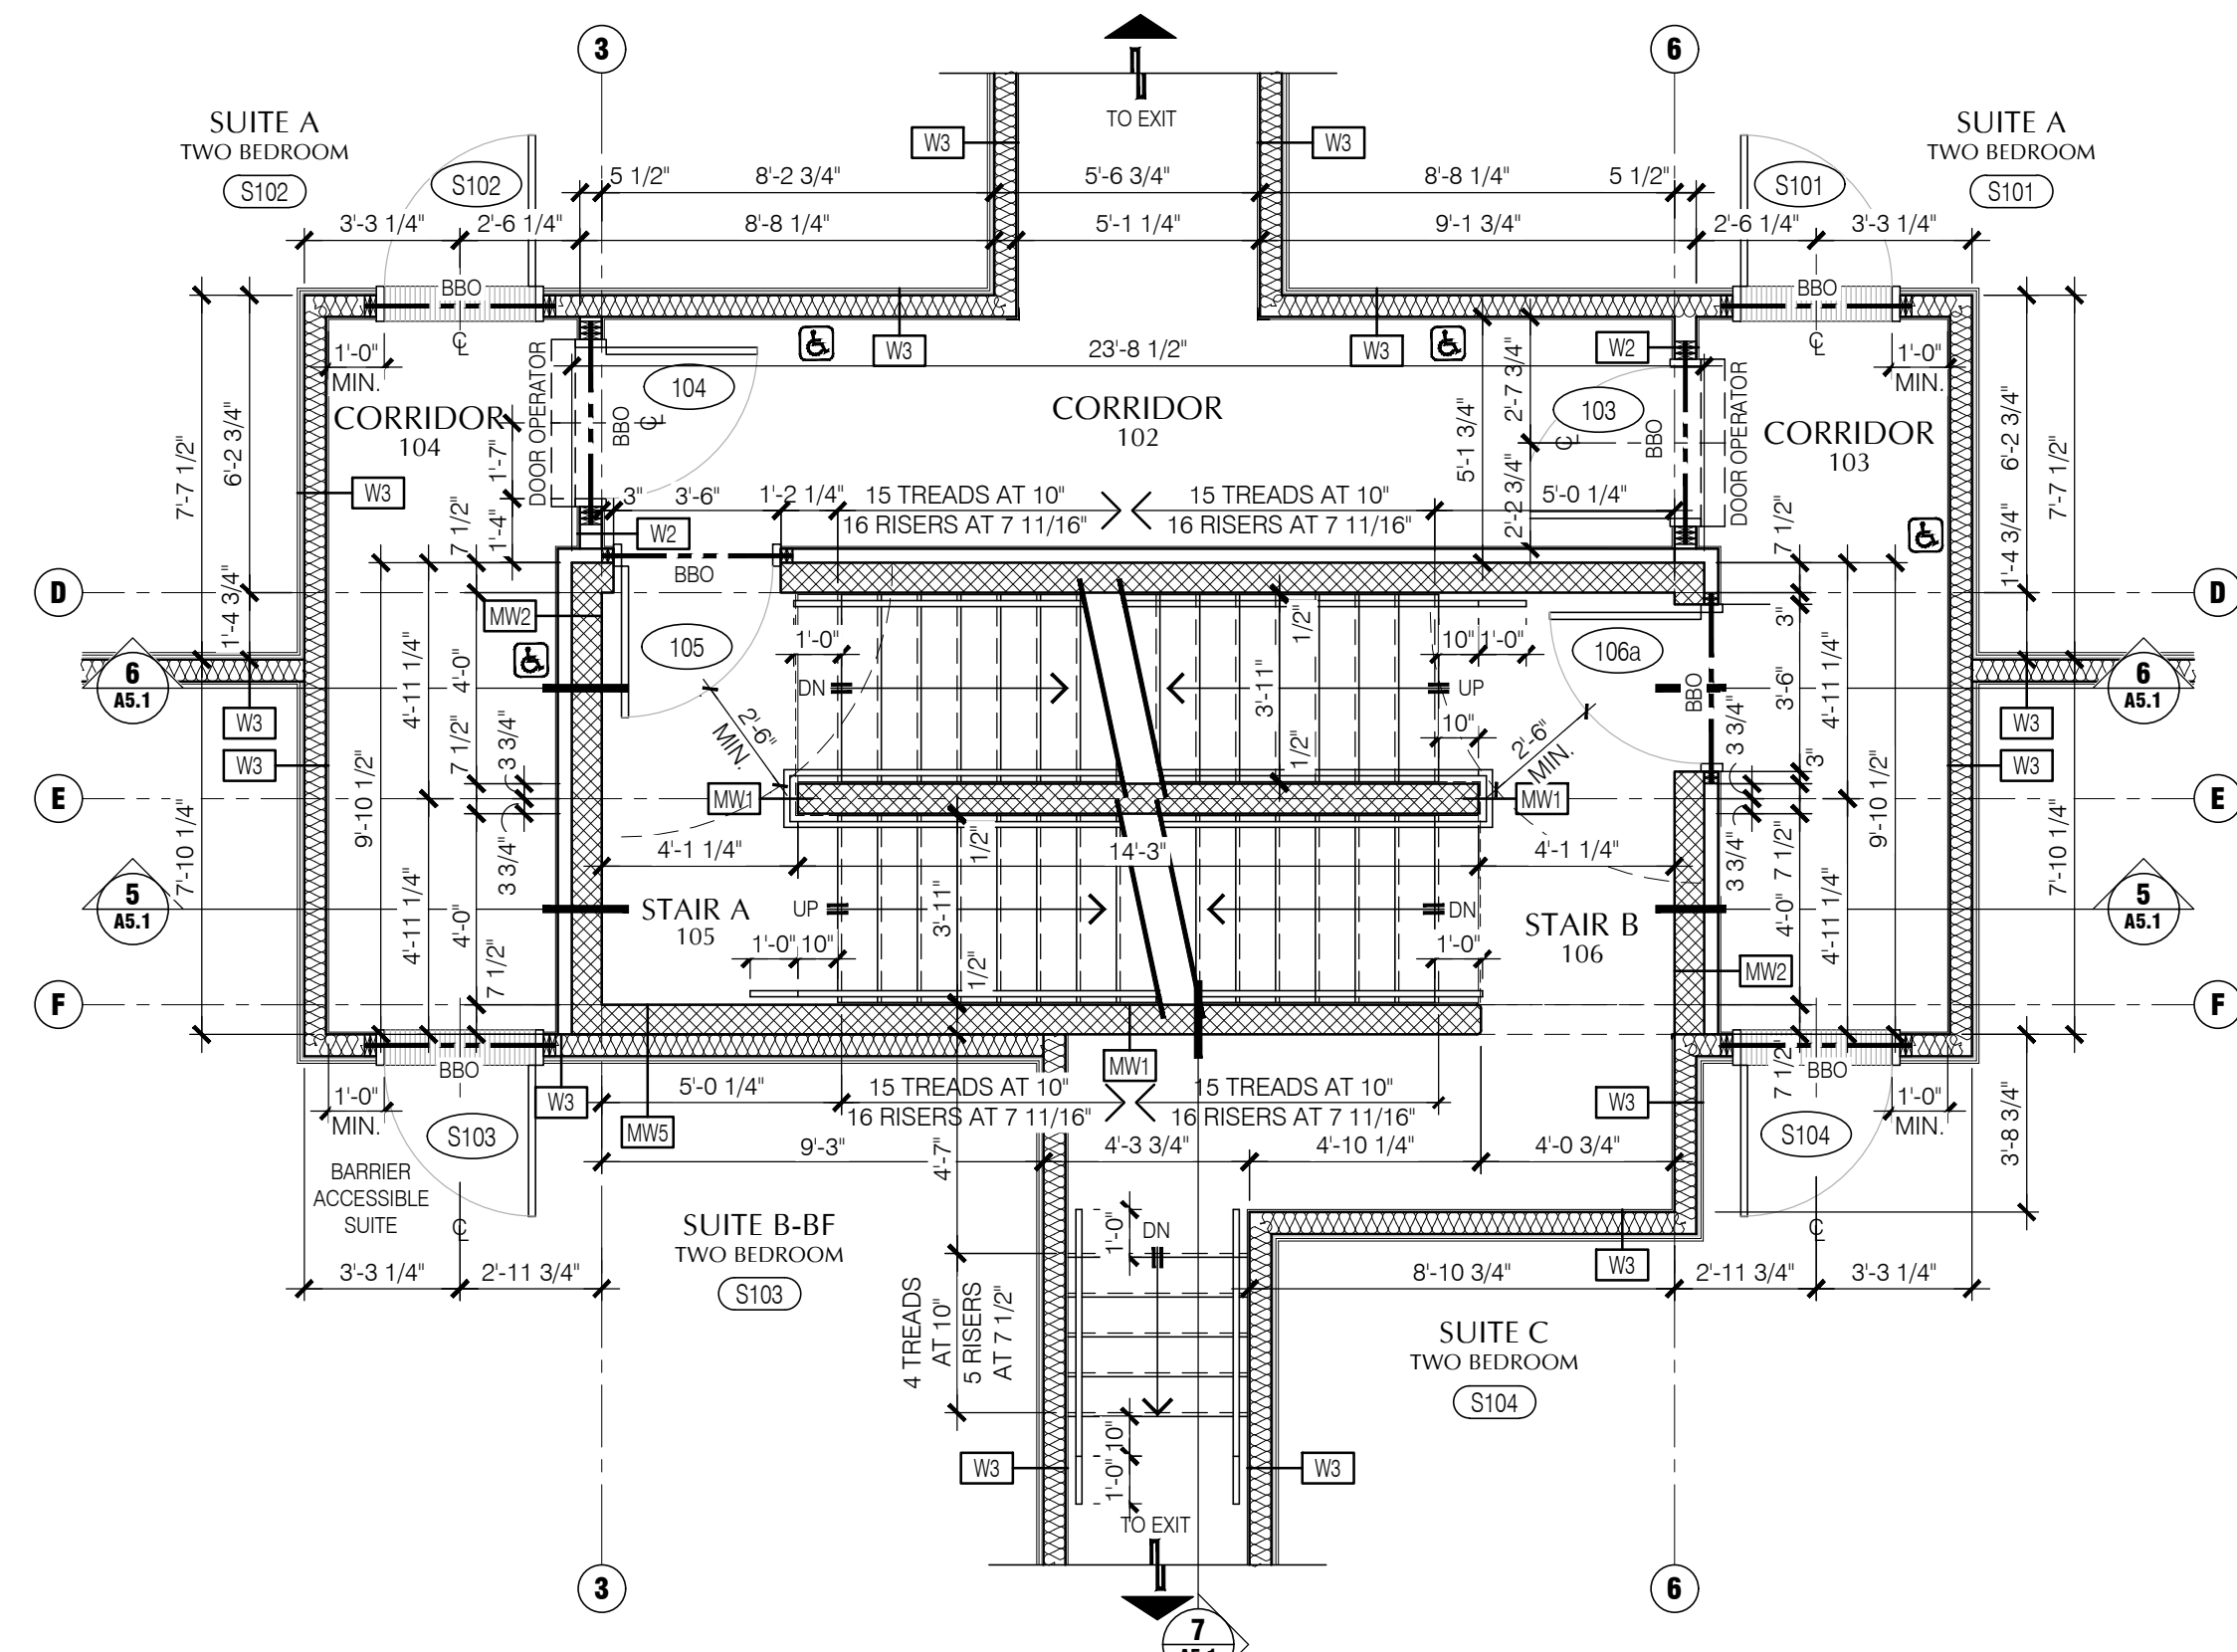

2 MAIN FLOOR STAIRS - ENLARGED PLAN
A5.1 1/4" = 1'-0"

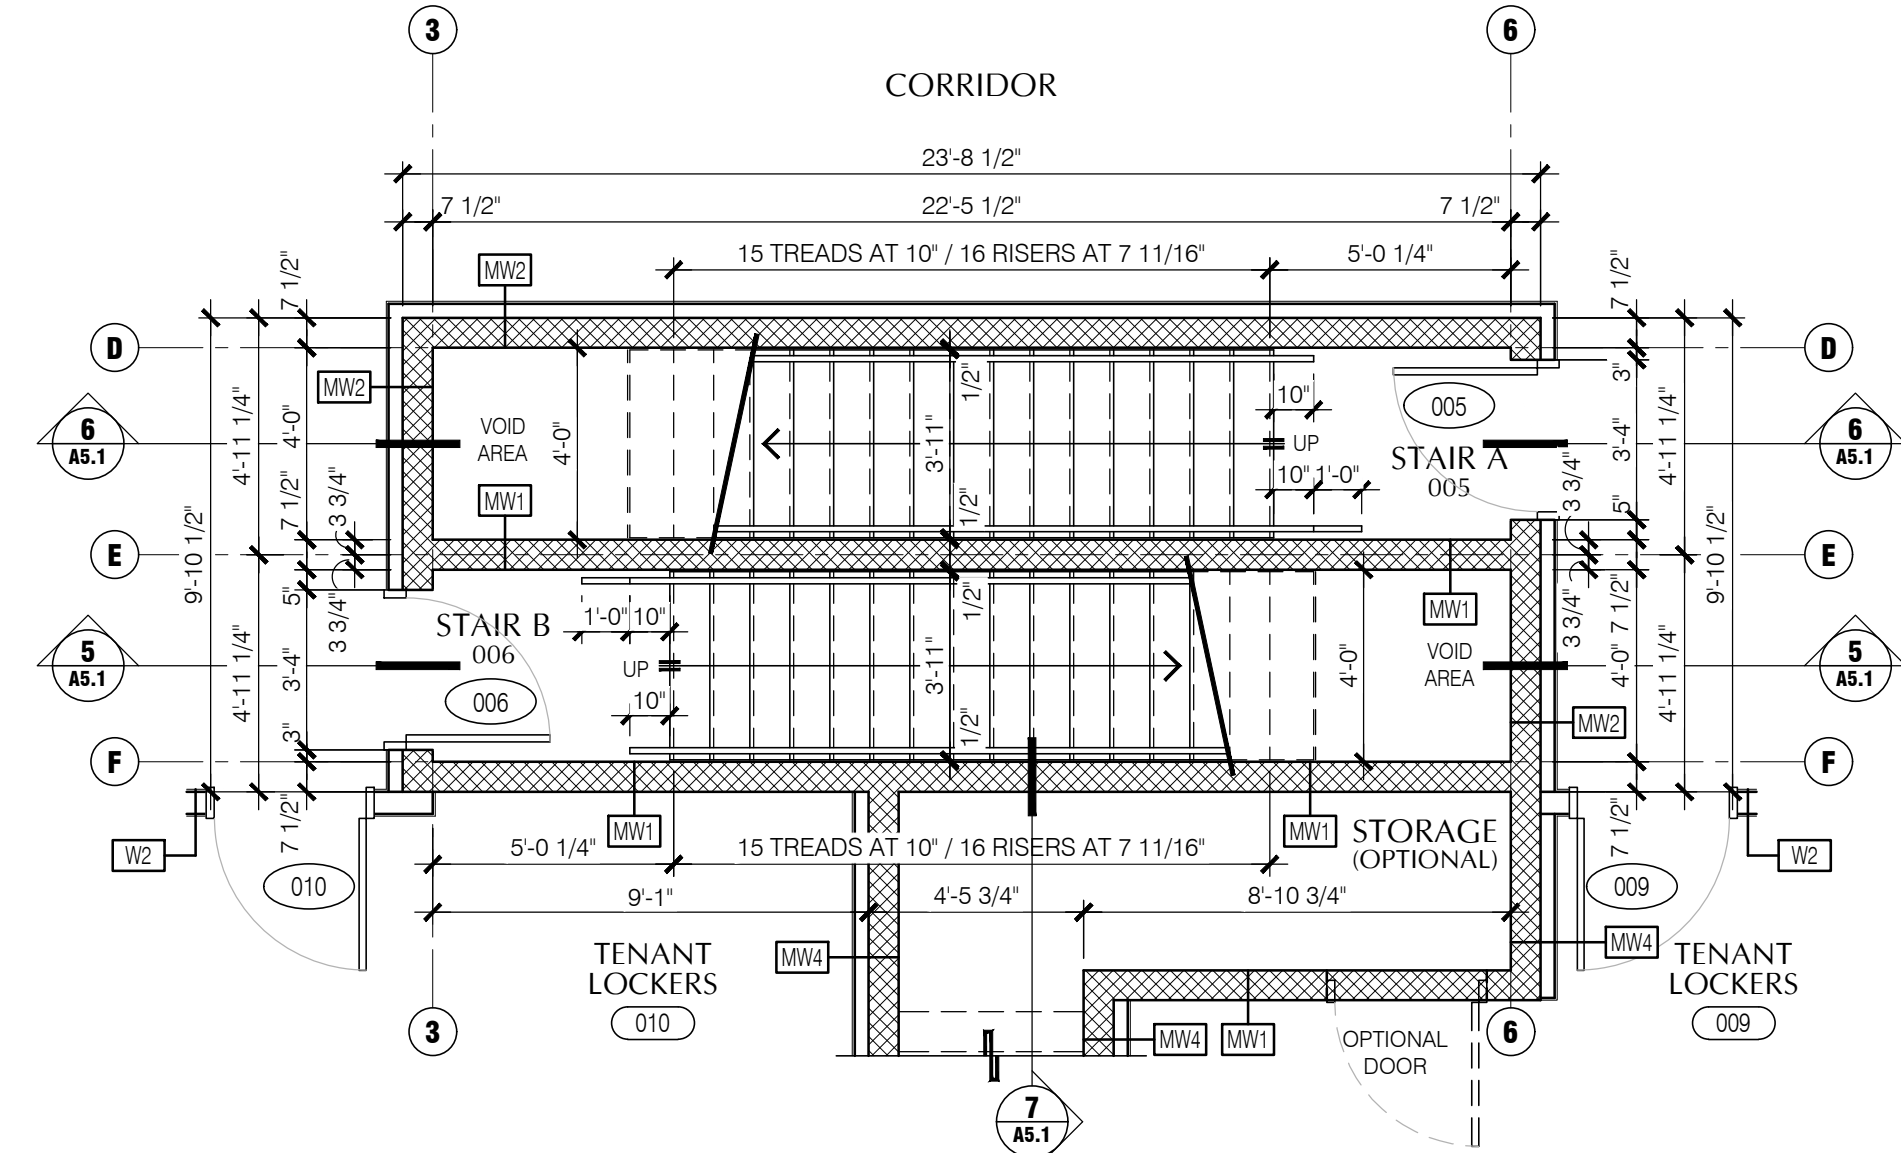


1 BASEMENT STAIRS - ENLARGED PLAN
A5.1 1/4" = 1'-0"

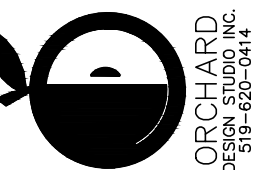


gb architect inc.


430 ONTARIO STREET
STRATFORD, ONTARIO N5A 3Z2
PHONE (519) 272-0073 FAX (519) 272-4433

*Guy R. Bellemeur, B. Arch, OAA, MRAC
Principal Architect of GB ARCHITECT INC. is the
designer for this project with respect to all architectural
work identified on this drawing sheet. The Ontario
Association of Architects (OAA) is the professional
body for architects in Ontario.
Guy R. Bellemeur, B. Arch, OAA, MRAC
EC28 Number 427
as per requirements of the Ministry of Municipal
Affairs & Housing Bill 124.
The Architect above has exercised responsible control with
respect to design activities. The Architect's seal number is their
BCLN's number.

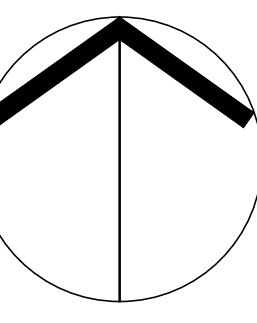

A5.1	No.										
	TITLE	APARTMENT BUILDING BLOCK 17 STAIR PLANS & SECTIONS									
	MILVERTON	ONTARIO									
	SCALE	1/4" = 1'-0"									
	OWN BY	JED									
	DATE	APRIL 2021									
	REVISED										
	21-08-24	1	ISSUED FOR OFFICIAL PLAN AMENDMENT								
	21-09-16	2	ISSUED FOR SPA (1st SUBMISSION)								
	21-11-09	3	REVISED FOR SPA (1st SUBMISSION)								
21-11-24	4	ISSUED TO CONSULTANTS									
21-12-08	5	ISSUED TO CONSULTANTS									
21-12-13	6	ISSUED FOR PERMIT									

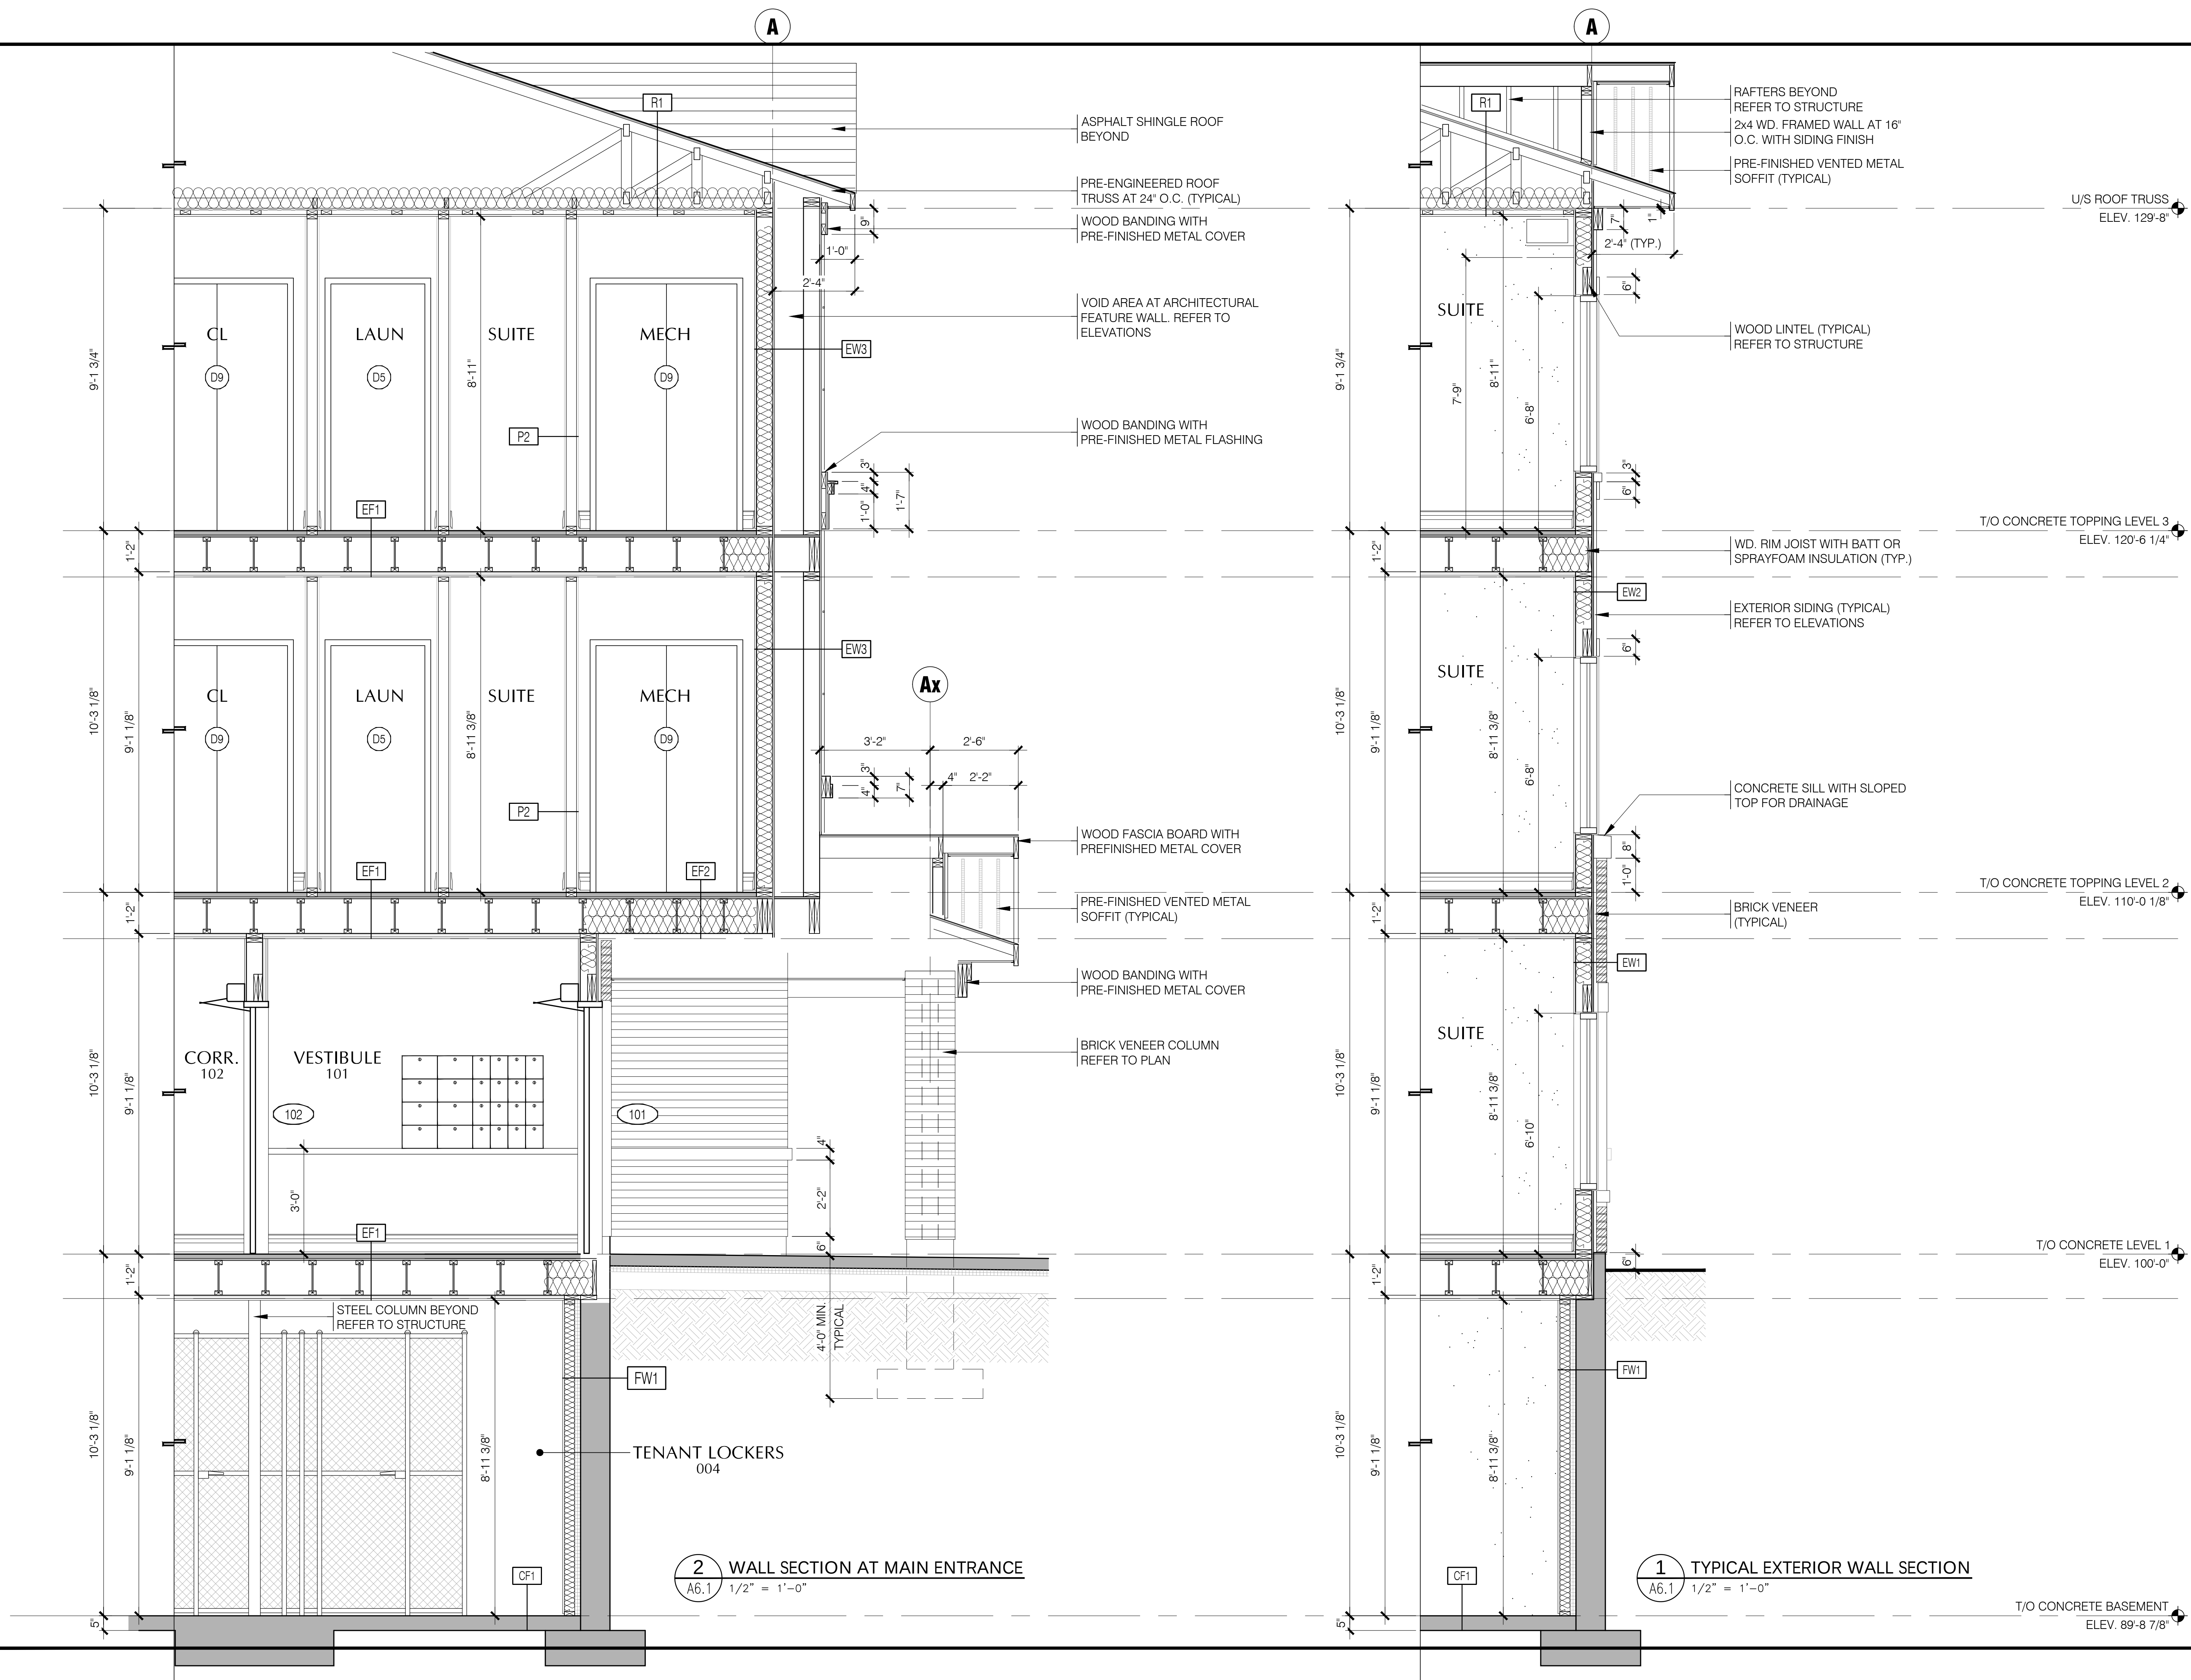

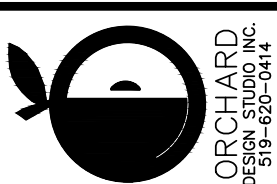

ORCHARD
DESIGN GROUP INC.
300-460-0414

gb architect inc.
430 ONTARIO STREET
STRATFORD, ONTARIO, N5A 3J2
PHONE (519) 272-0073 FAX (519) 272-4433


*Guy R. Bellemeur, B. Arch, OAA, MRAC
Principal Architect of GB ARCHITECT INC. is the
designer for this project with respect to all architectural
work identified on this drawing sheet. The Ontario
Association of Architects (OAA) is the regulatory
body for the architectural profession in Ontario.
Guy R. Bellemeur, B. Arch, OAA, MRAC
B.C.A. Number 487
as per requirements of the Ministry of Municipal
Affairs & Housing Bill 124.
The Architect above has exercised responsible control with
respect to design activities. The Architect's seal number is their
B.C.A. number.

ONTARIO ASSOCIATION
OF ARCHITECTS
GUY ROBERT BELLEMEUR
LICENCE
4217
DECEMBER 13, 2021

STATUS	DESIGN DEVELOPMENT	ISSUED FOR PERMIT	DATE
21-12-13	6	ISSUED FOR PERMIT	21-12-13
21-12-08	5	ISSUED TO CONSULTANTS	21-12-08
21-11-24	4	ISSUED TO CONSULTANTS	21-11-24
21-11-09	3	REVISED FOR SPA (1st SUBMISSION)	21-11-09
21-09-16	2	ISSUED FOR SPA (1st SUBMISSION)	21-09-16
21-08-24	1	ISSUED FOR OFFICIAL PLAN AMENDMENT	21-08-24



PROJECT
MILVERTON APARTMENT BUILDING
MILVERTON ONTARIO
BLOCK 17
WALL SECTIONS

SHEET No.
A6.1

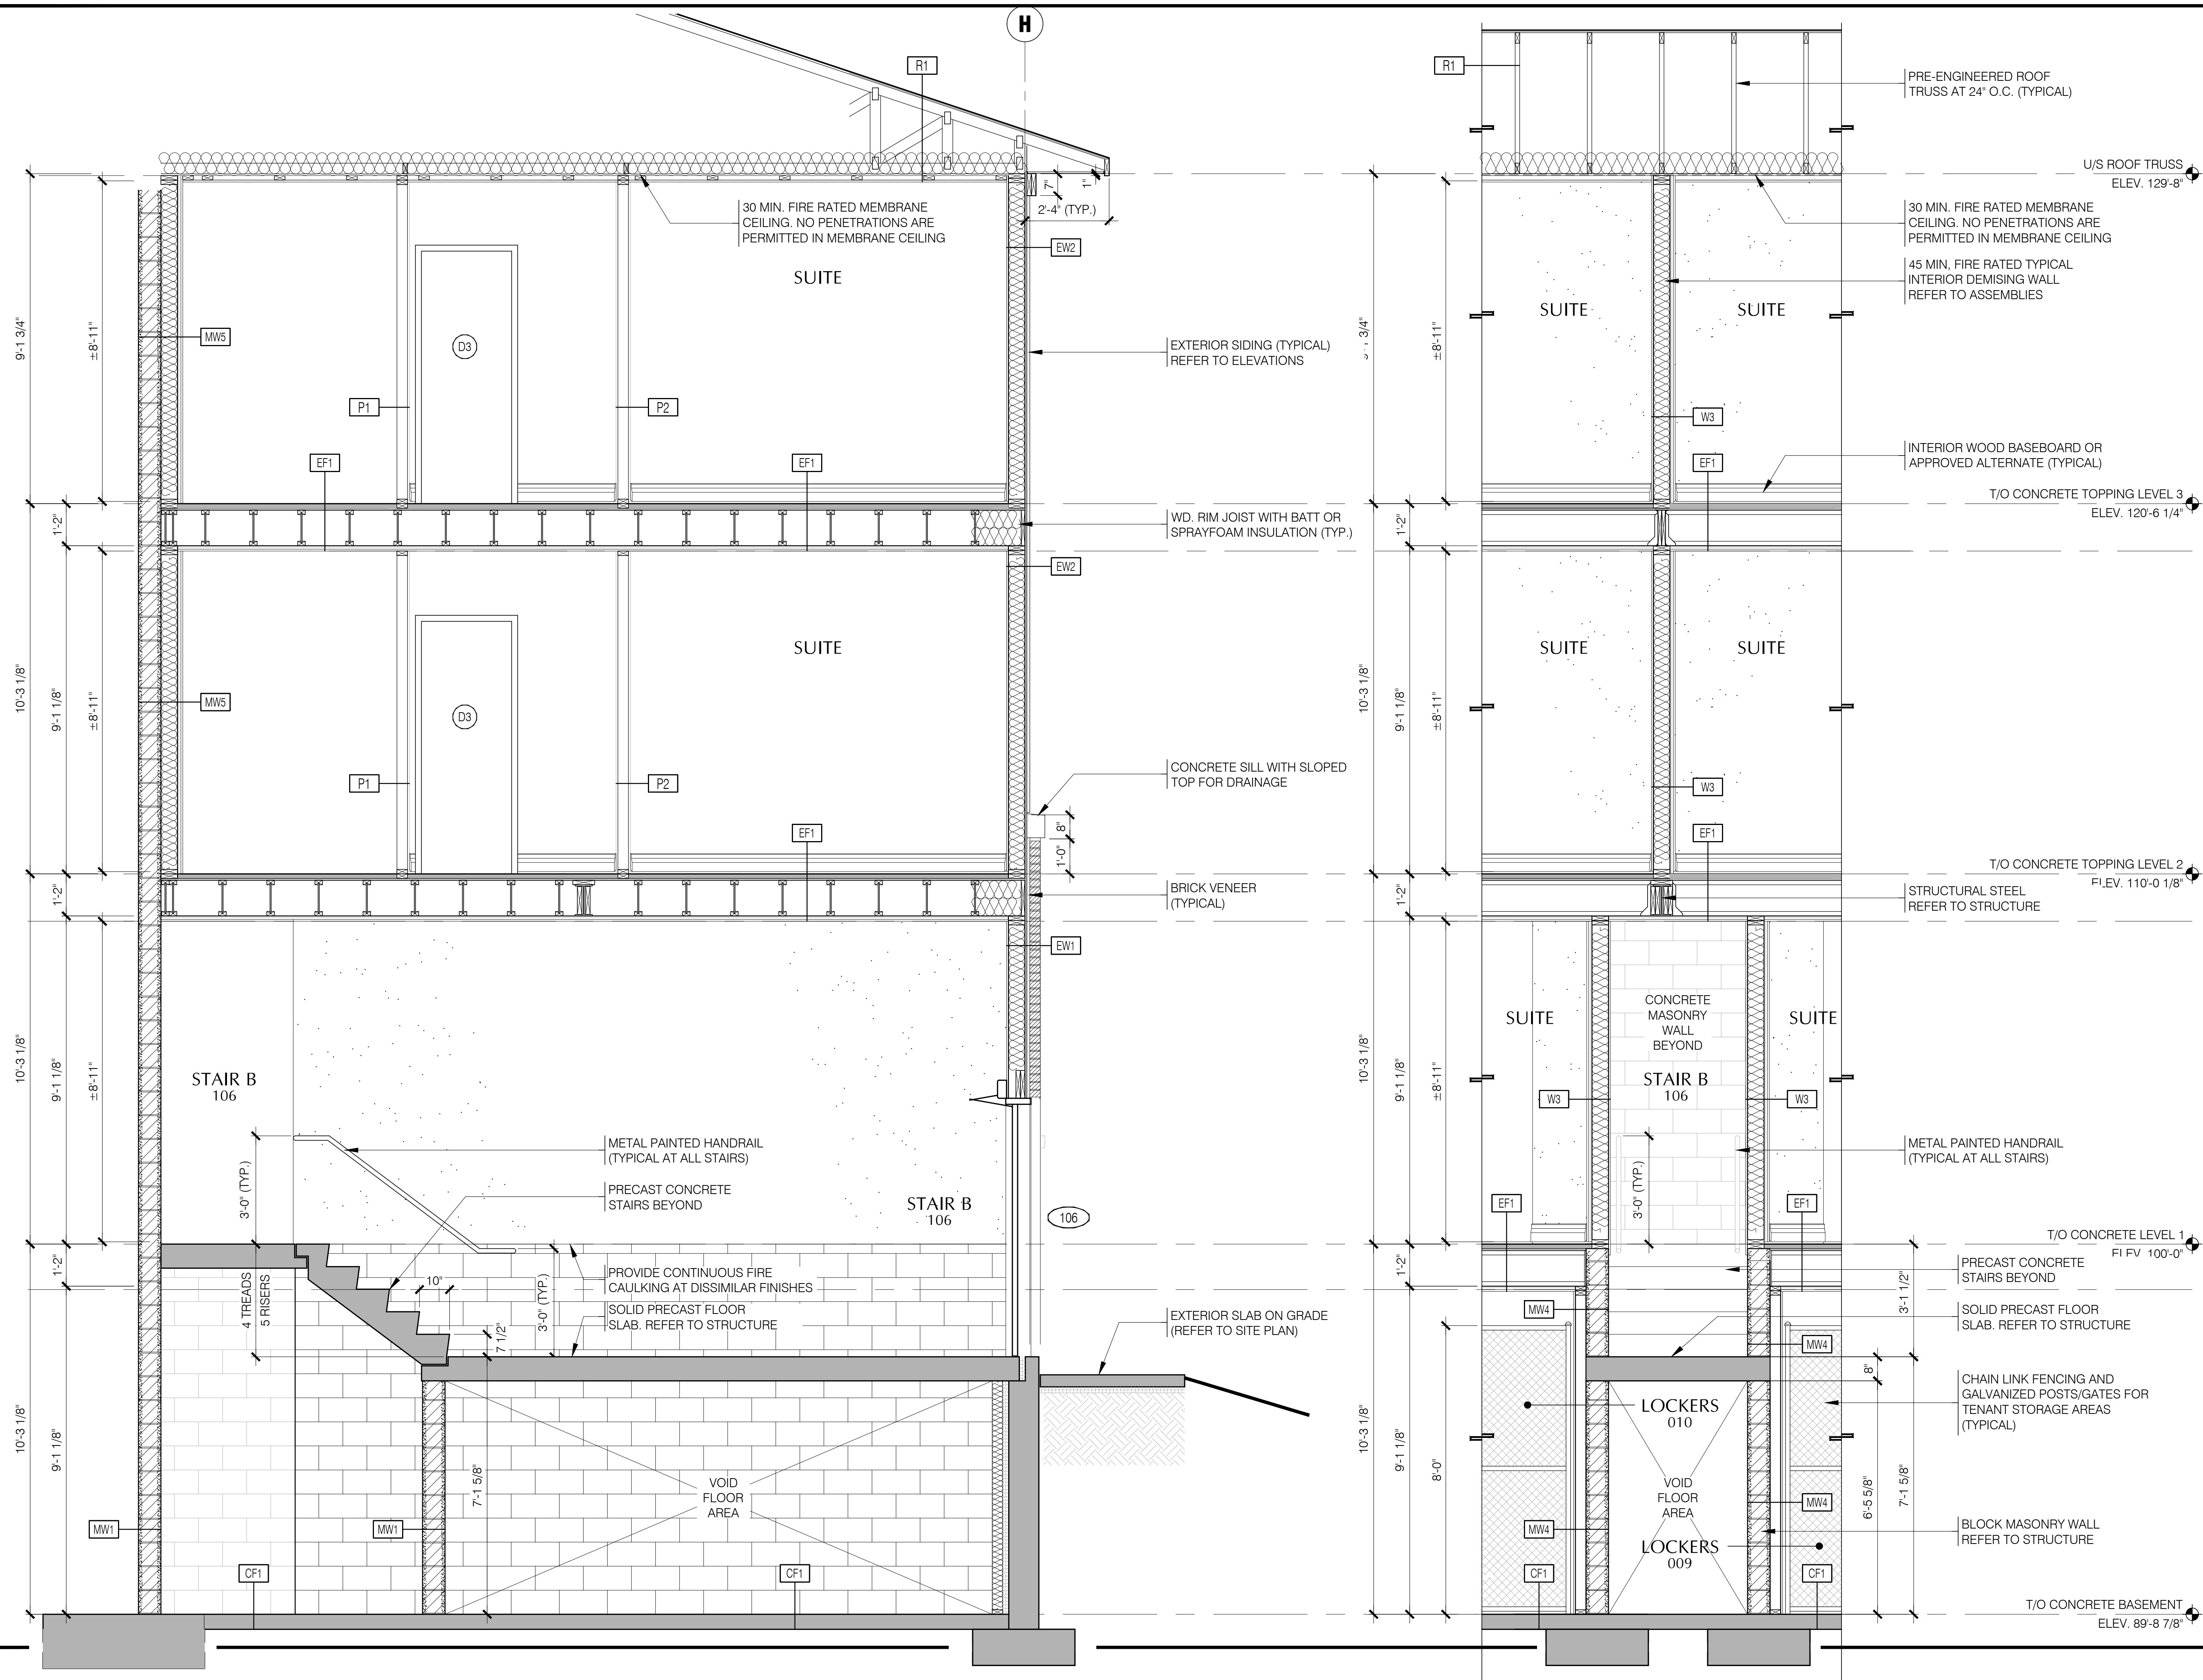

gb architect inc.
430 ONTARIO STREET
STRATFORD, ONTARIO, N5A 3Z2
PHONE (519) 272-0073 FAX (519) 272-4433

*Guy R. Bellemeur, B. Arch, OAA, MRAC
Principal Architect of GB ARCHITECT INC. is the
designer for this project with respect to all architectural
work identified on this drawing sheet. The Ontario
Architectural Association (OAA) has reviewed the
work of Guy R. Bellemeur and GB ARCHITECT INC.
as per requirements of the Ministry of Municipal
Affairs & Housing Bill 124.
The Architect above has exercised responsible control with
respect to design activities. The Architect's seal number is their
B.C.D.S. number.

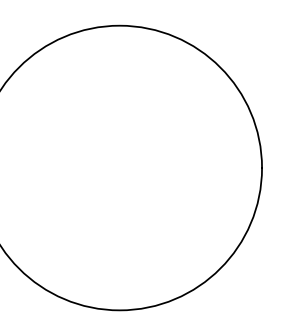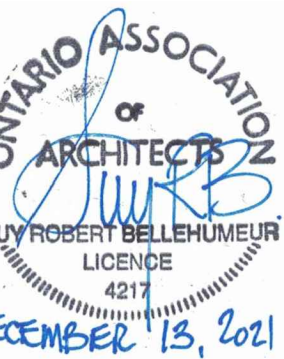

STATUS	DESIGN DEVELOPMENT	ISSUED FOR PERMIT	21-12-13	6
FOLDER	MARTIN-MILVERTON	FILE 14-705-AG-SECT-BLK 17.dwg	21-12-08	5
SCALE	1/4" = 1'-0"	ISSUED TO CONSULTANTS	21-11-24	4
DATE	APRIL 2021	ISSUED TO CONSULTANTS	21-11-09	3
REVISION		REISED FOR SPA (1st SUBMISSION)	21-09-16	2
DATE		ISSUED FOR OFFICIAL PLAN AMENDMENT	21-08-24	1
NO.		REVISION	DATE	

PROJECT	MILVERTON APARTMENT BUILDING
SHEET No.	BLOCK 17 WALL SECTIONS

PROJECT	MILVERTON APARTMENT BUILDING
SHEET No.	BLOCK 17 WALL SECTIONS

A6.2